


异能无人机学园

(施工图册)

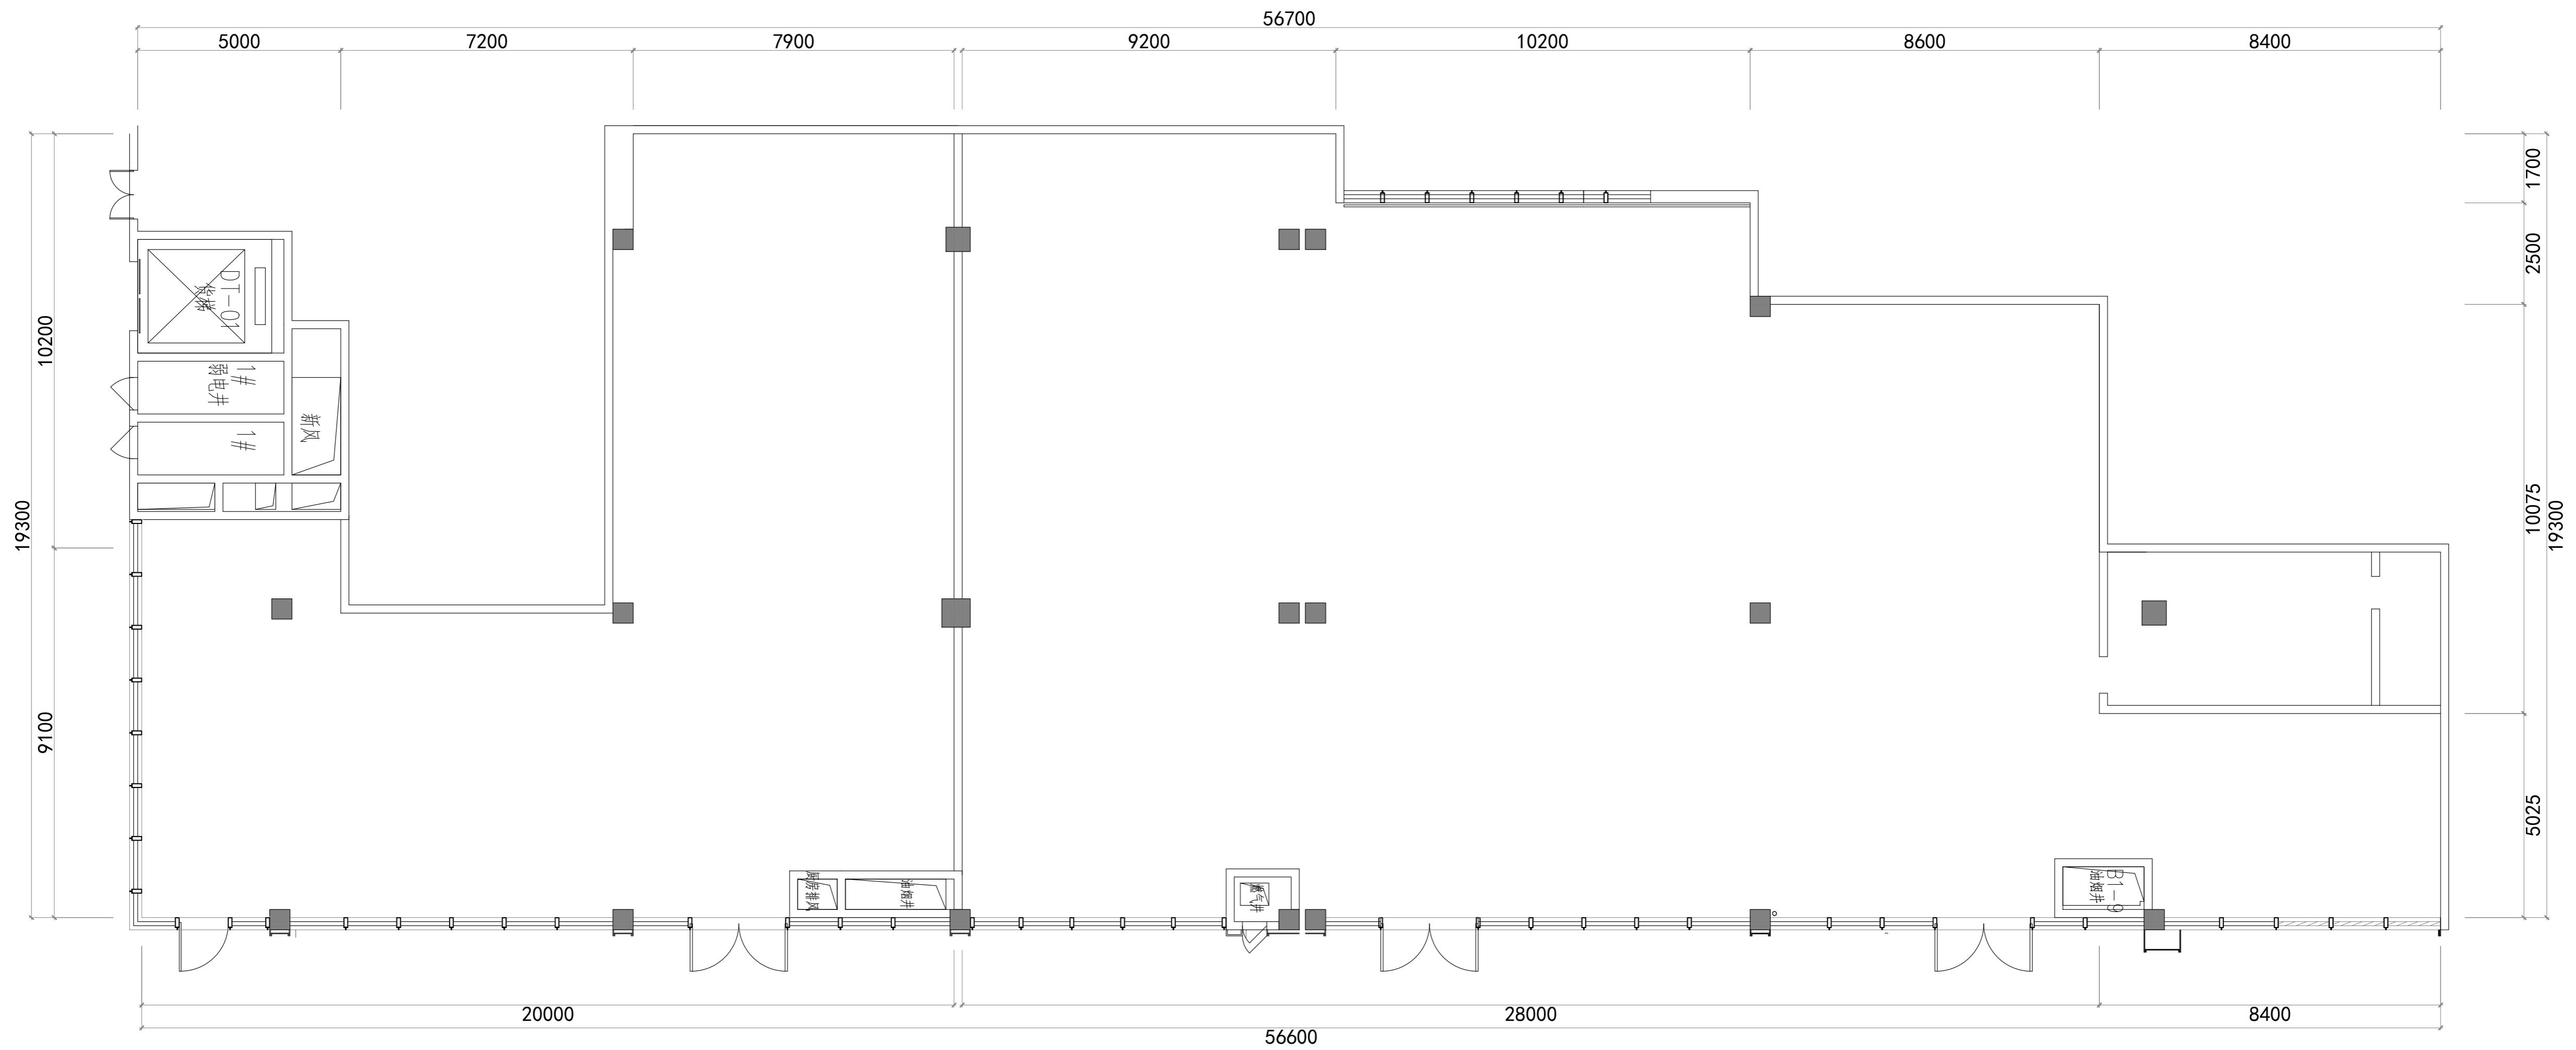

此图版权归本公司，所有尺寸以所注数字为准，并在工地核实无误，使用本图时应参阅其它有关图纸，说明和合同，如有矛盾即通知本公司，设计图若有变更应按下栏最后修改记录或变更通知单为准。
 This drawings & design are copyright and portion may be reproduced without the written permission of the architect. All written dimensions or grid line measurements to existing work to be checked on site. This drawings is to be read in conjunction with the specification & conditions of contract, and with general architectural plans, structural plans and all immediately of any discrepancy found the drawings not showing the last revisions above are to be cancelled.

工程名称
PROJECT NAME

异能无人机学园
原始结构图

次数	NO	修改日期	REVISIONS
△			
△			
△			
△			

设计负责人
PROJECT DIRECTOR

设计
DESIGNED BY

审核
APPROVED BY

业主(甲方)
CLIENT


制图
DRAWN BY

比例
SCALE

图号
DRAWING NO

日期
DATE

P-02

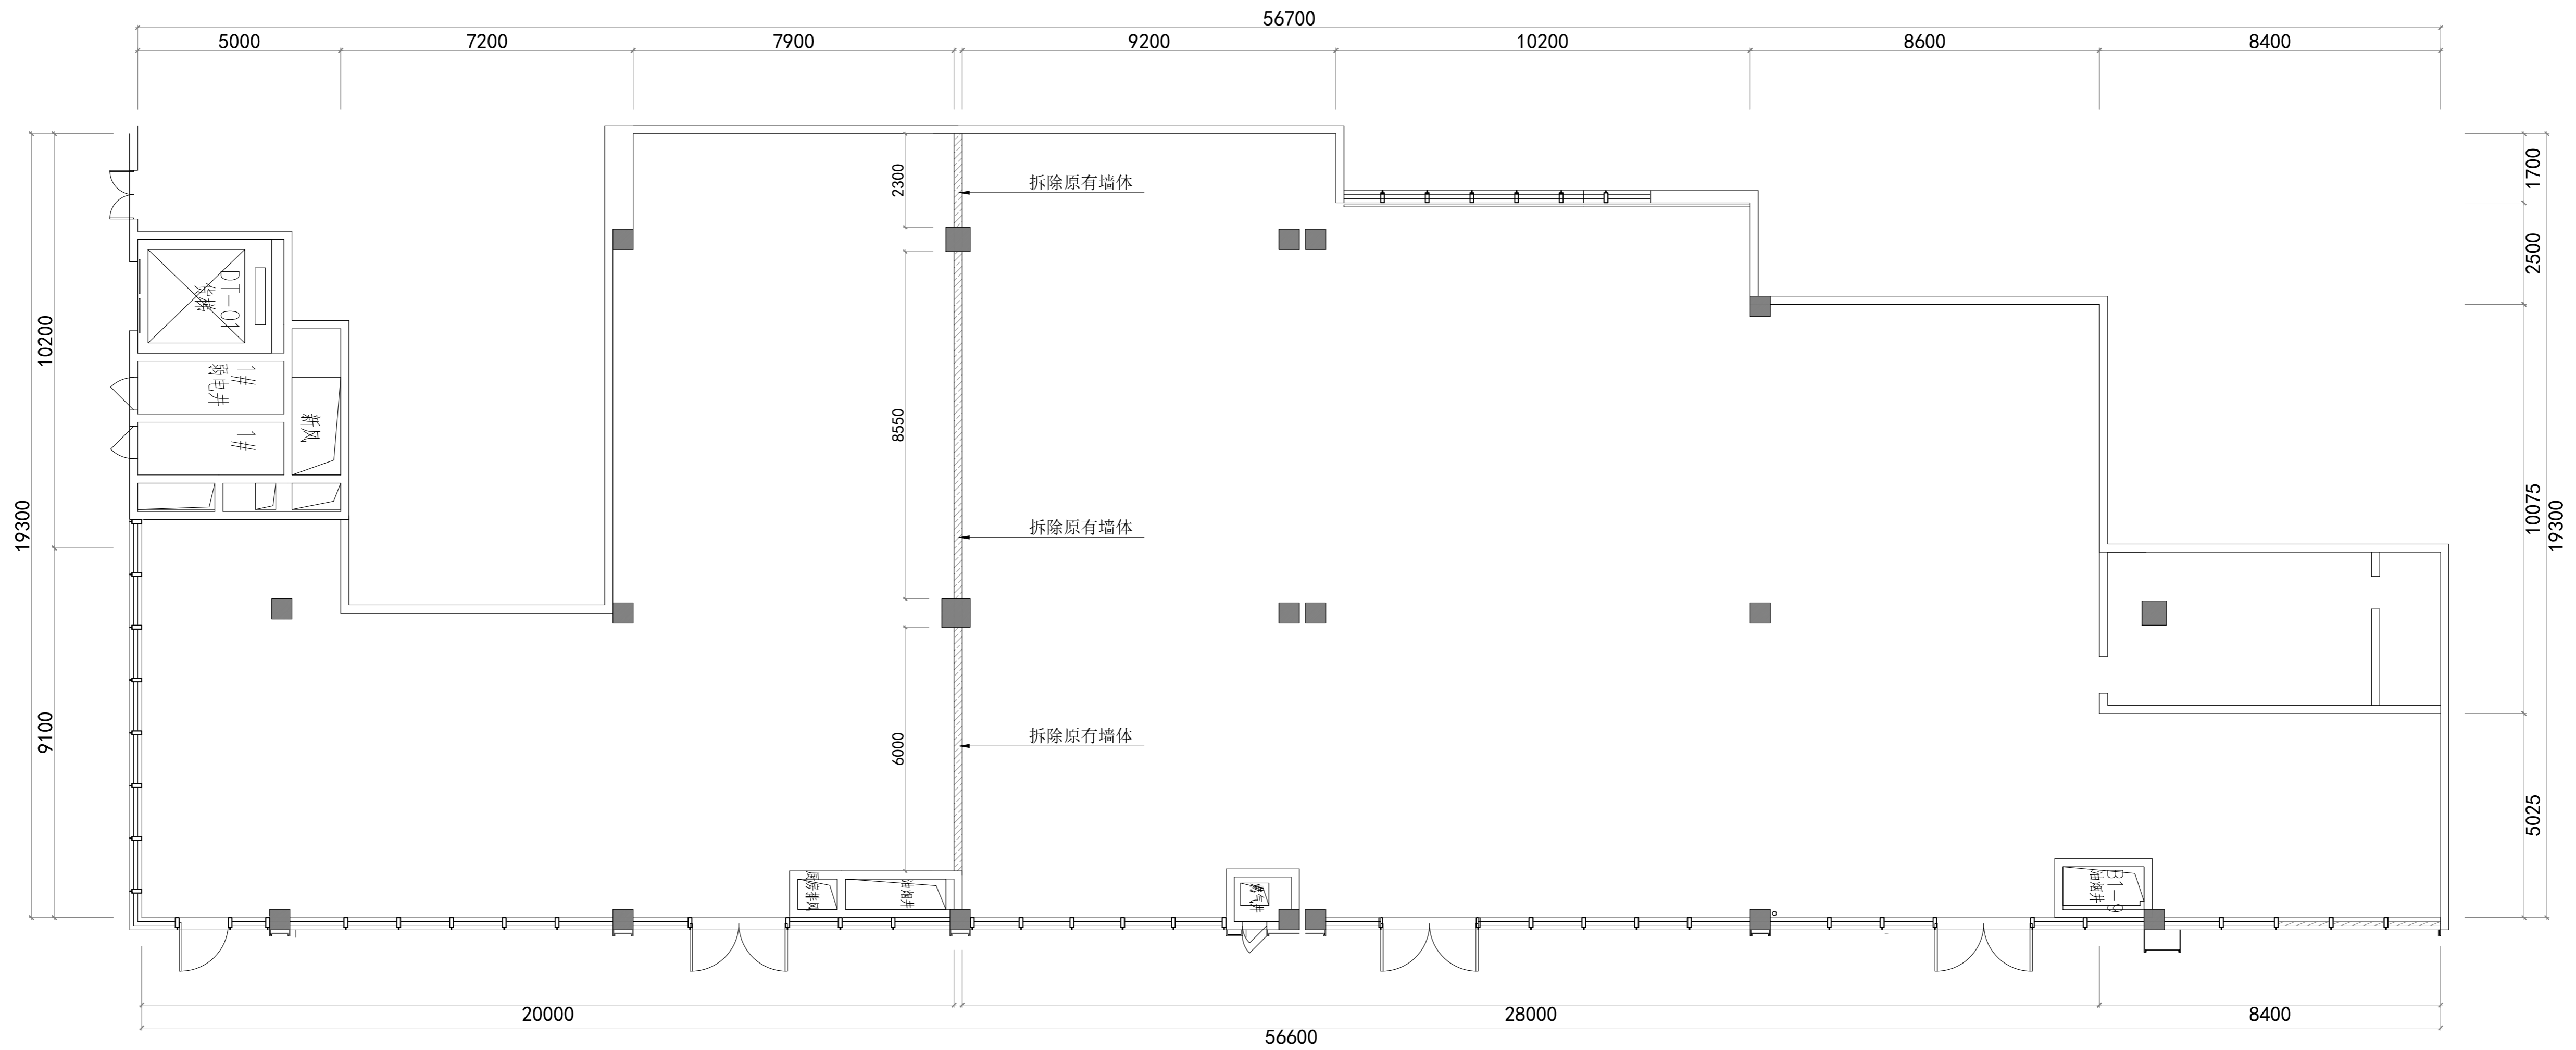

名称	轻质砖隔墙	拆除墙体
图例		

此图版权归本公司，所有尺寸以所注数字为准，并在工地核实无误，使用本图时应参阅其它有关图纸、说明和合同，如有矛盾即通知本公司，设计图若有变更应按下栏最后修改记录或变更通知单为准。

This drawings & design are copyright and portion may be reproduced without the written permission of the architect. All written dimensions or grid line measurements to existing work to be checked on site. This drawings is to be read in conjunction with the specification & conditions of contract, and with general architectural plans, structural plans and all immediately of any discrepancy found the drawings not showing the last revisions above are to be cancelled.

工程名称
PROJECT NAME

图纸名称
DRAWING TITLE

异能无人机学园

拆除墙体图

次数	NO	修改日期	REVISIONS
△			
△			
△			
△			

设计负责人
PROJECT DIRECTOR

设计
DESIGNED BY

审核
APPROVED BY

业主(甲方)
CLIENT



制图
DRAWN BY

比例
SCALE

图号
DRAWING NO

日期
DATE

P-03

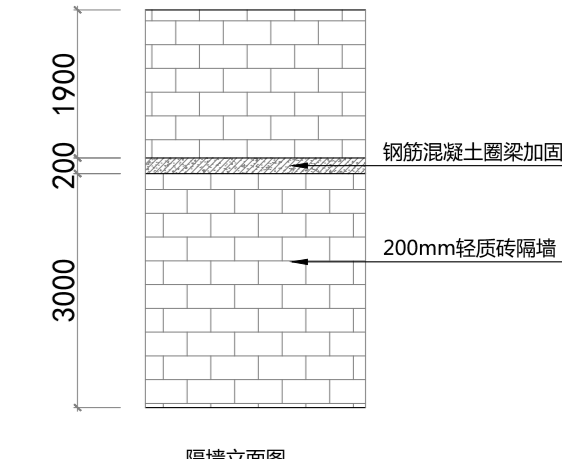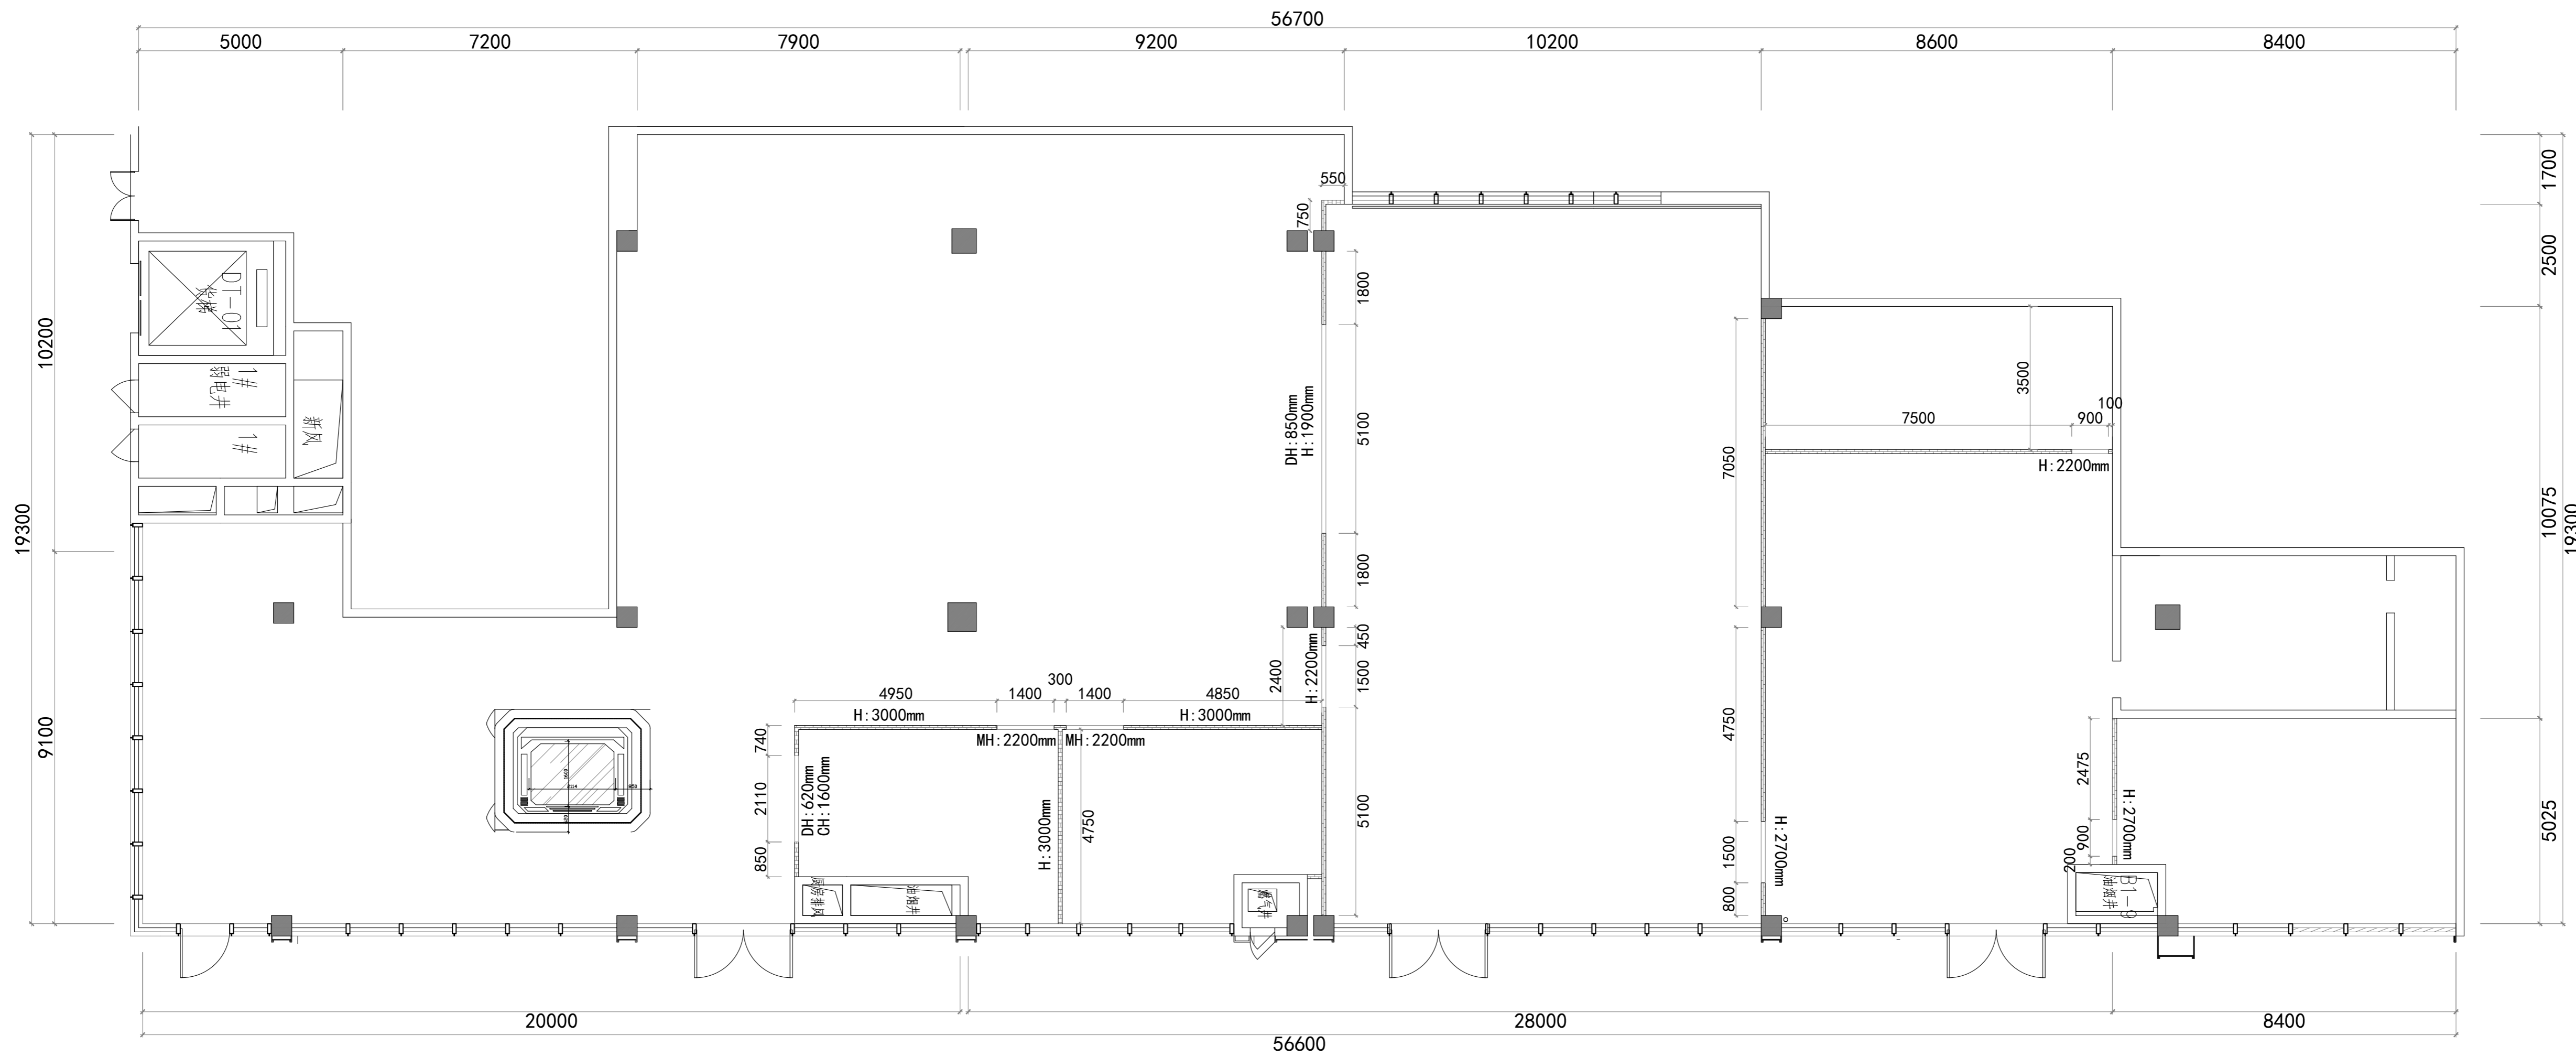

名称	轻质砖隔墙	拆除墙体
图例		


此图版权归本公司，所有尺寸以所注数字为准，并在工地核实无误，使用本图时应参阅其它有关图纸、说明和合同，如有矛盾即通知本公司，设计图若有变更应按下栏最后修改记录或变更通知单为准。
 This drawings & design are copyright and portion may be reproduced without the written permission of the architect. All written dimensions or grid line measurements to existing work to be checked on site. This drawings is to be read in conjunction with the specification & conditions of contract, and with general architectural plans, structural plans and all immediately of any discrepancy found the drawings not showing the last revisions above are to be cancelled.

工程名称 PROJECT NAME	异能无人机学园
图纸名称 DRAWING TITLE	新建墙体图

次数 NO	修改日期	REVISIONS
△		
△		
△		
△		

设计负责人 PROJECT DIRECTOR	业主(甲方) CLIENT
设计 DESIGNED BY	制图 DRAWN BY
审核 APPROVED BY	比例 SCALE

图号 DRAWING NO	P-04
日期 DATE	

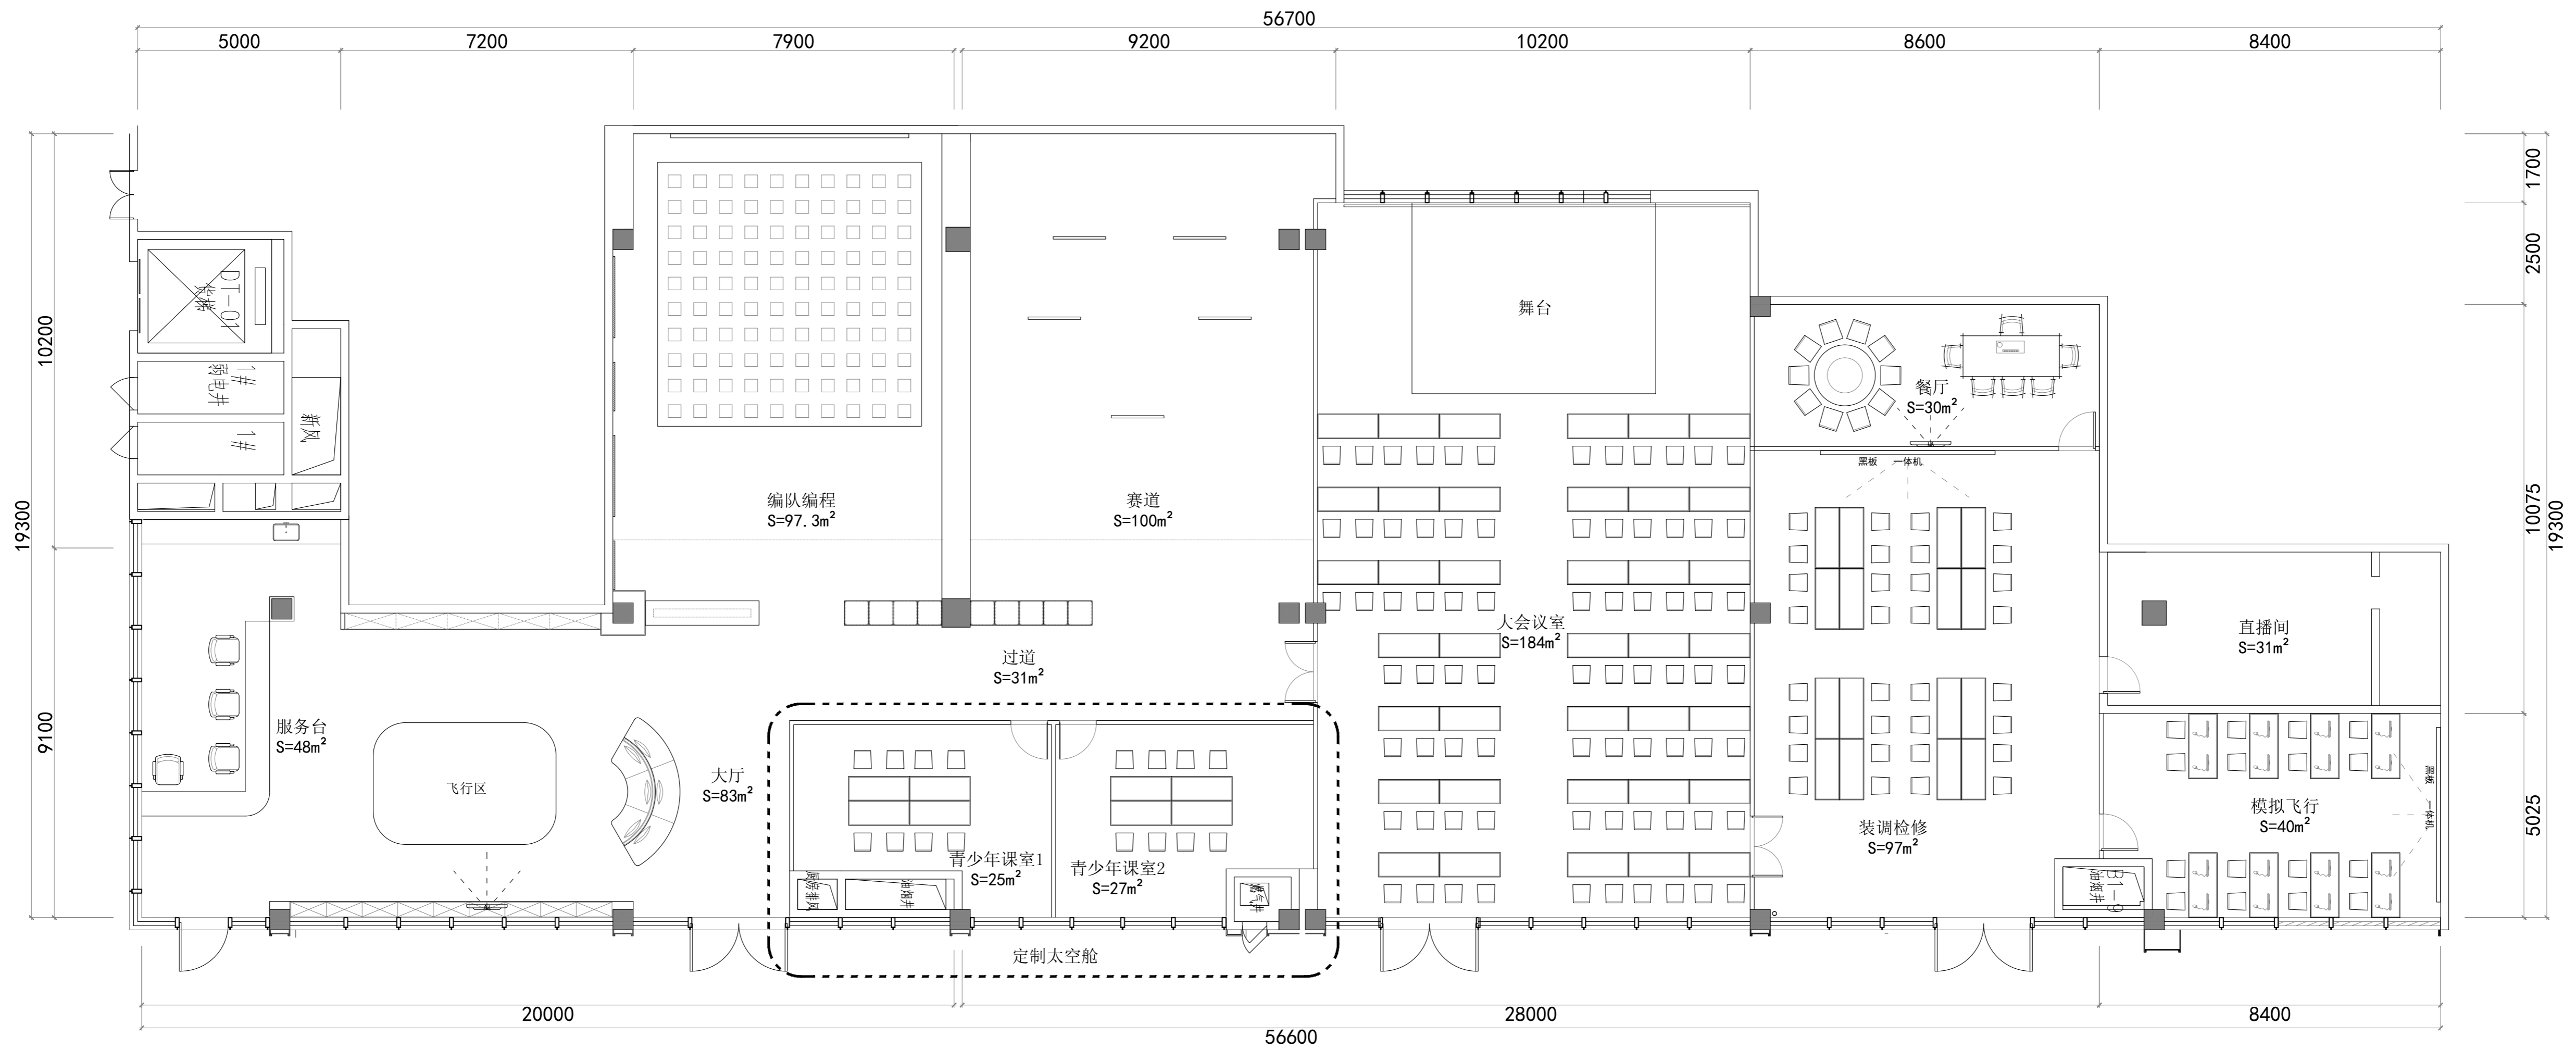

此图版权归本公司，所有尺寸以所注数字为准，并在工地核实无误，使用本图时应参阅其它有关图纸，说明和合同，如有矛盾即通知本公司，设计图若有变更应按下栏最后修改记录或变更通知单为准。
 This drawings & design are copyright and portion may be reproduced without the written permission of the architect. All written dimensions or grid line measurements to existing work to be checked on site. This drawings is to be read in conjunction with the specification & conditions of contract, and with general architectural plans, structural plans and all immediately of any discrepancy found the drawings not showing the last revisions above are to be cancelled.

工程名称
PROJECT NAME

异能无人机学园

平面布置图

次数	NO	修改日期	REVISIONS
△			
△			
△			
△			

设计负责人
PROJECT DIRECTOR

设计
DESIGNED BY

审核
APPROVED BY

业主(甲方)
CLIENT


制图
DRAWN BY

比例
SCALE

图号
DRAWING NO

日期
DATE

P-05

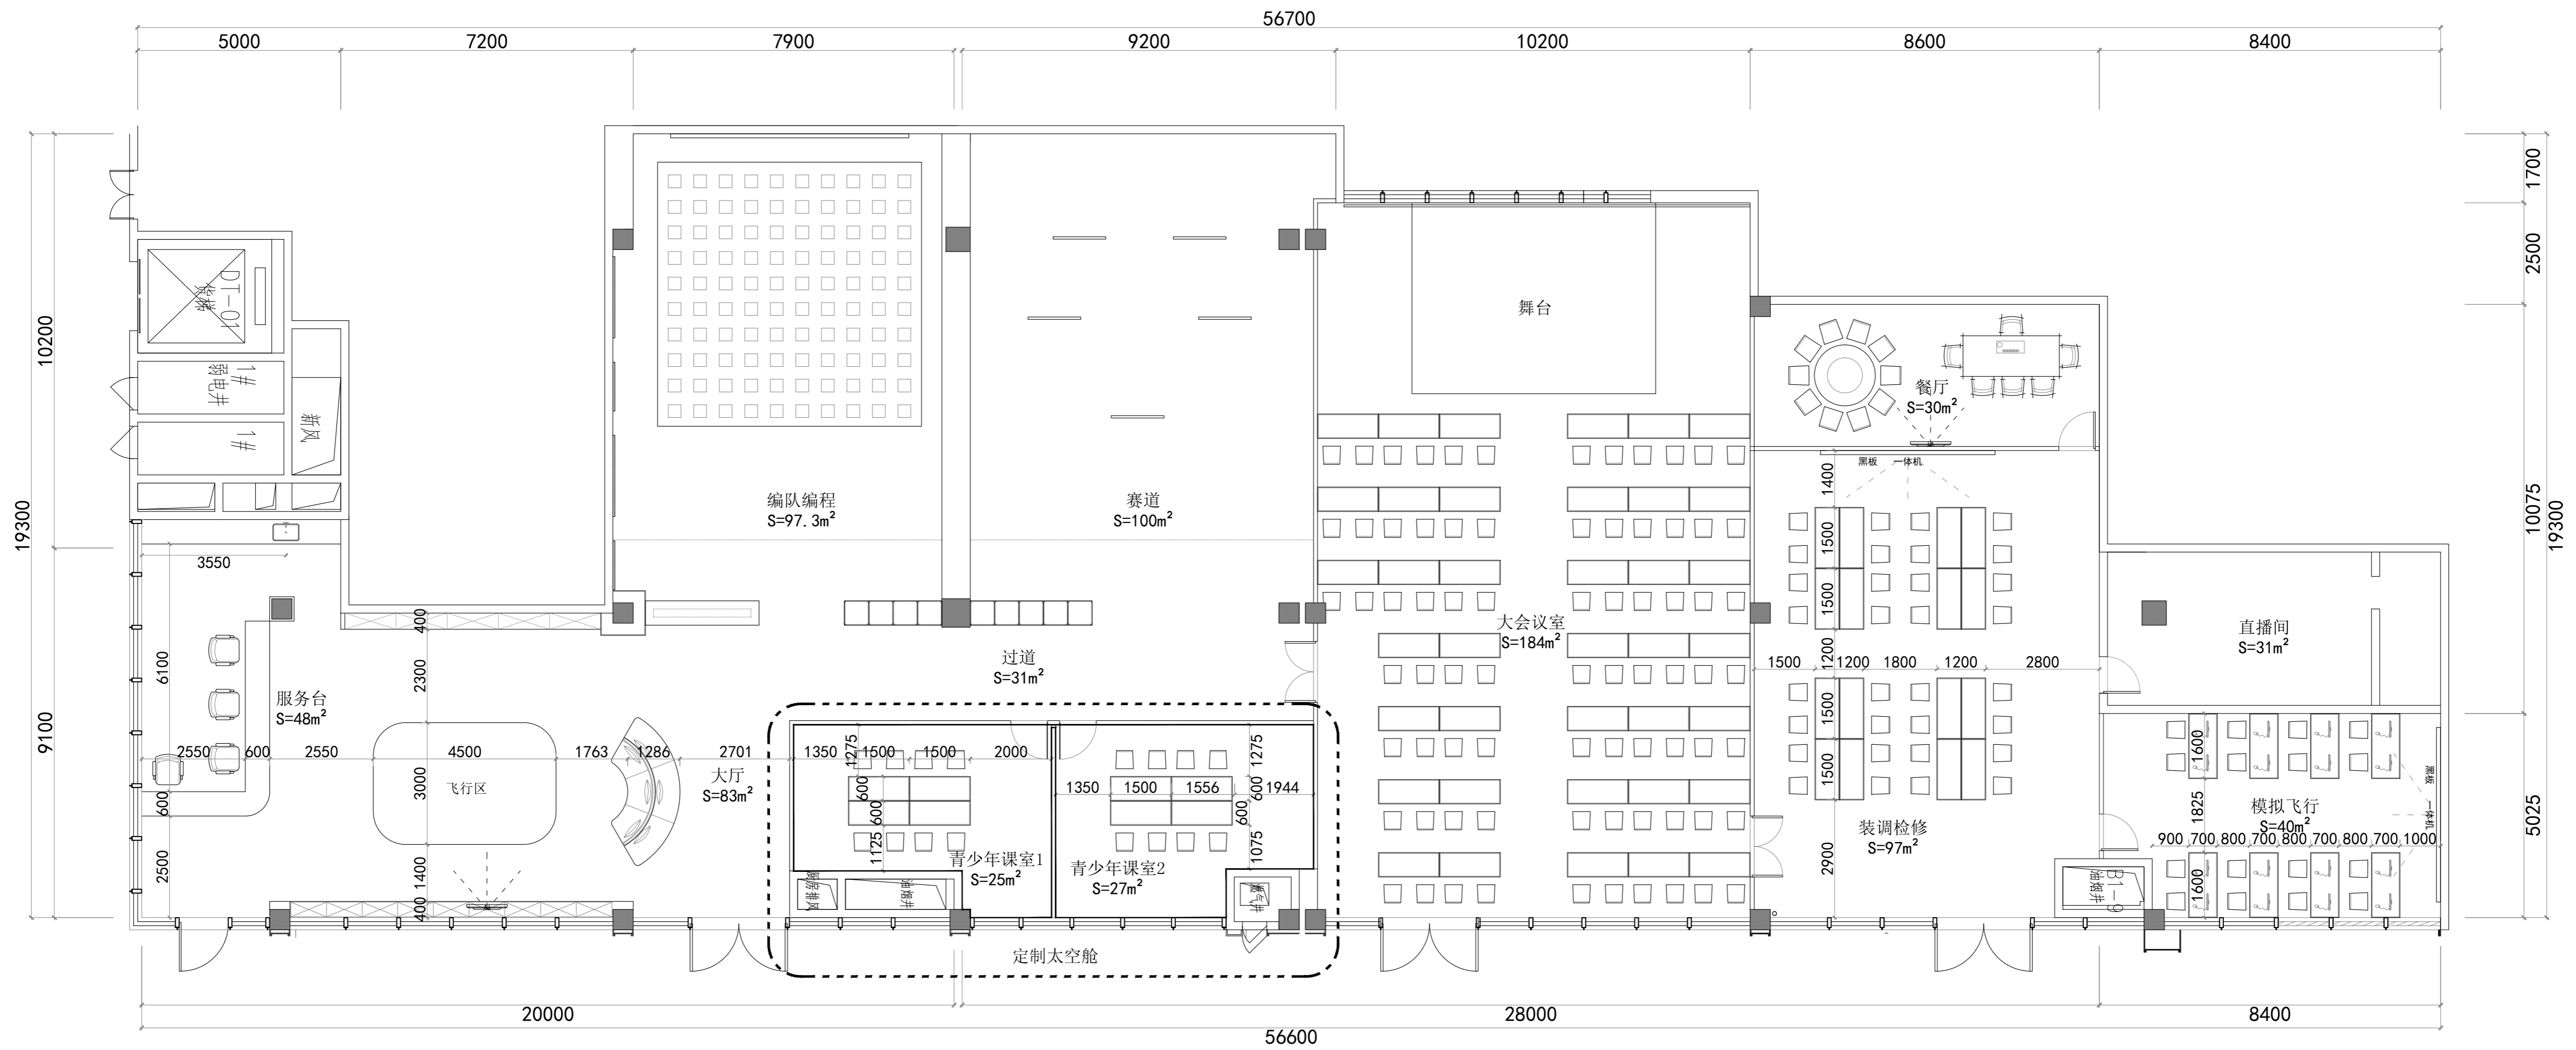

此图版权归本公司，所有尺寸以所注数字为准，并在工地核实无误，使用本图时应参阅其它有关图纸，说明和合同，如有矛盾即通知本公司，设计图若有变更应按下列最后修改记录或变更通知单为准。
 This drawings & design are copyright and portion may be reproduced without the written permission of the architect. All written dimensions or grid line measurements to existing work to be checked on site. This drawings is to be read in conjunction with the specification & conditions of contract, and with general architectural plans, structural plans and all immediately of any discrepancy found the drawings not showing the last revisions above are to be cancelled.

工程名称
PROJECT NAME
图纸名称
DRAWING TITLE

异能无人机学园

平面尺寸图


次数	NO	修改日期	REVISIONS
△			
△			
△			
△			

设计负责人
PROJECT DIRECTOR
设计
DESIGNED BY
审核
APPROVED BY

业主(甲方)
CLIENT
制图
DRAWN BY
比例
SCALE

图号
DRAWING NO
日期
DATE

P-06

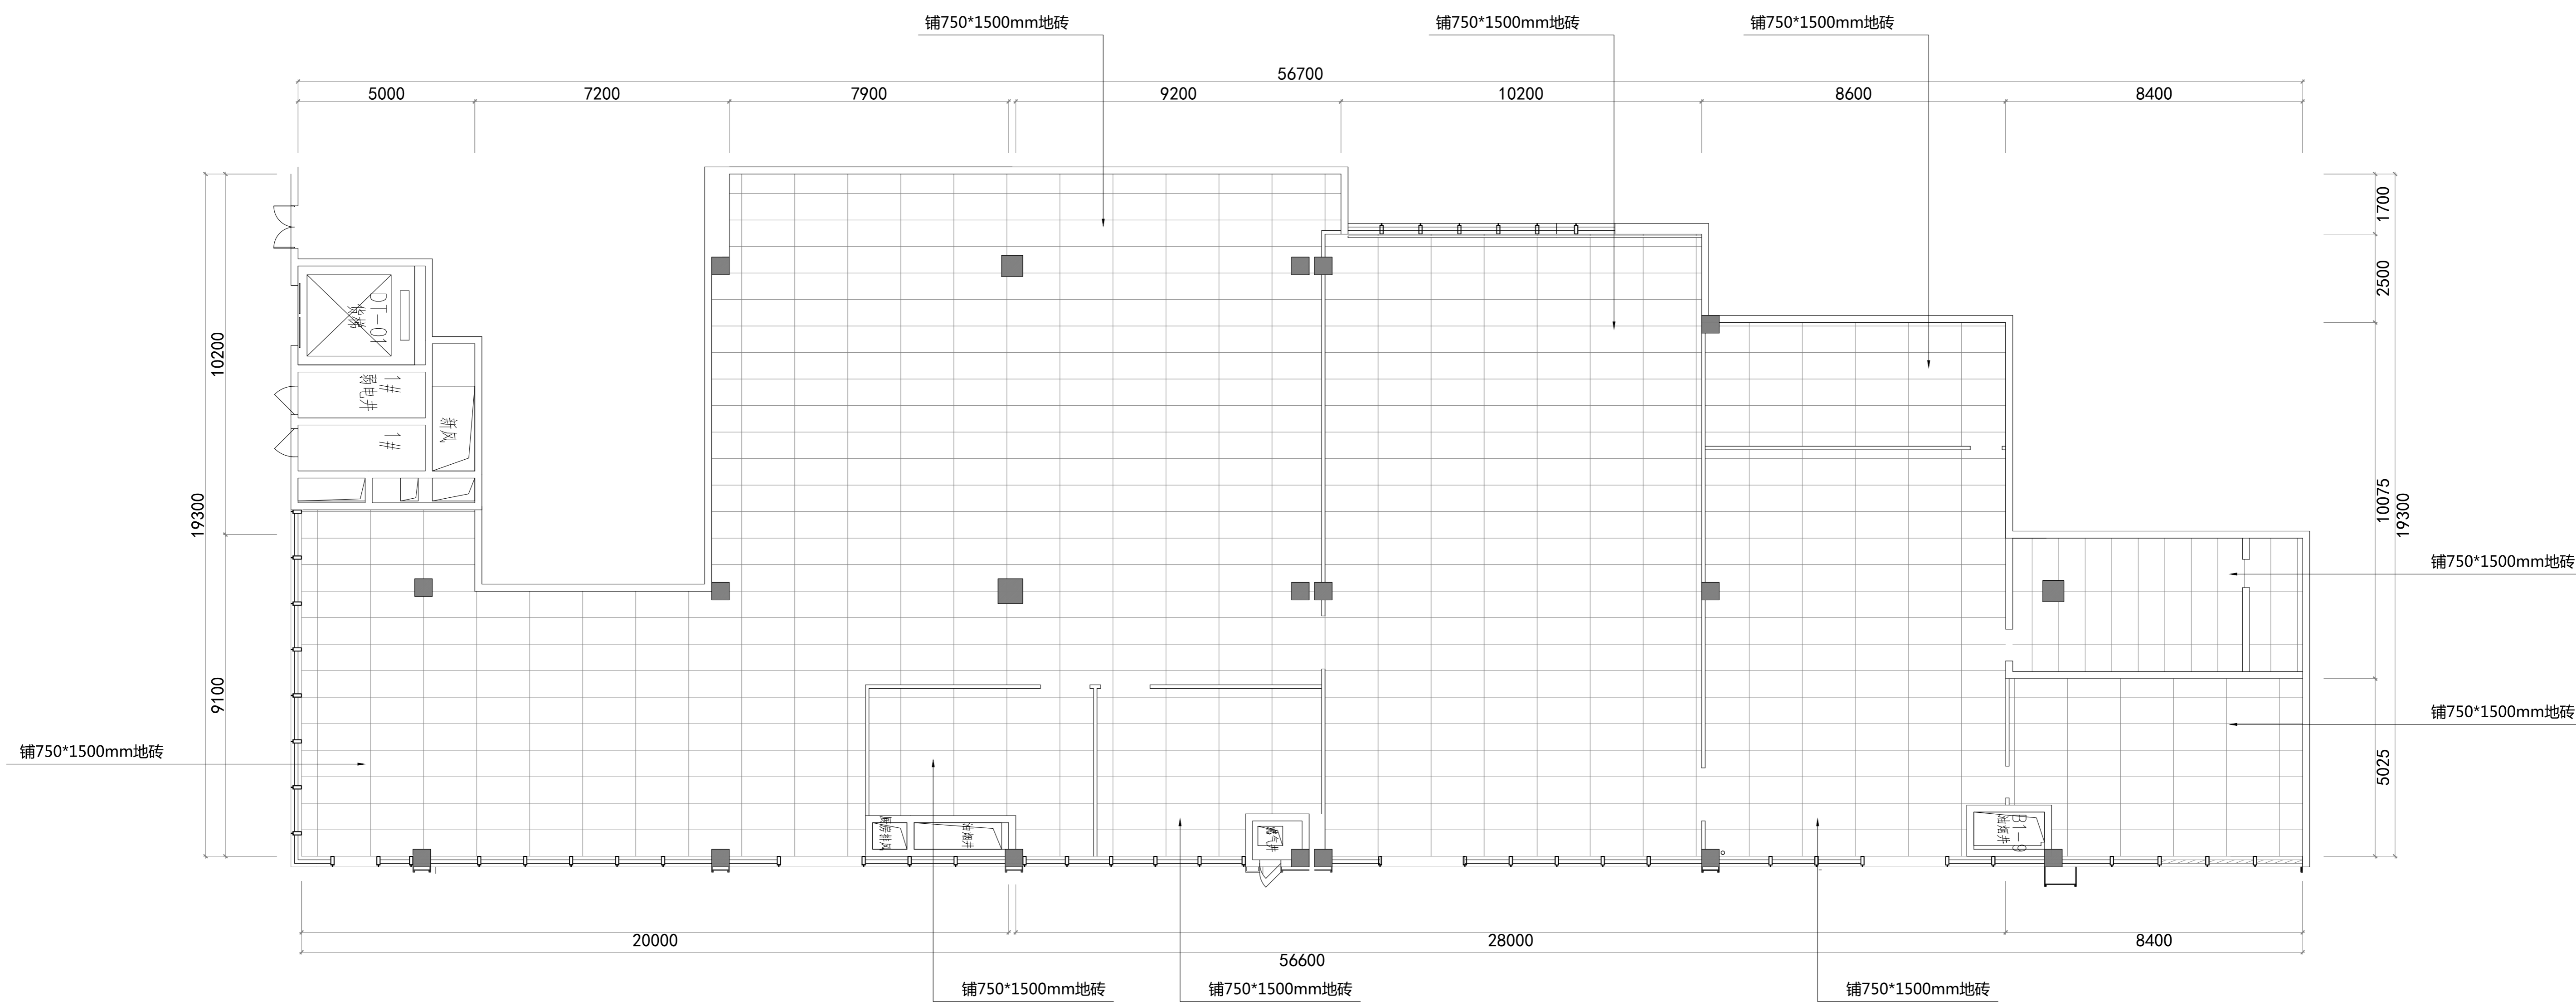

此图版权归本公司，所有尺寸以所注数字为准，并在工地核实无误，使用本图时应参阅其它有关图纸、说明和合同，如有矛盾即通知本公司，设计图若有变更应按下栏最后修改记录或变更通知单为准。
 This drawings & design are copyright and portion may be reproduced without the written permission of the architect. All written dimensions or grid line measurements to existing work to be checked on site. This drawings is to be read in conjunction with the specification & conditions of contract, and with general architectural plans, structural plans and all immediately of any discrepancy found the drawings not showing the last revisions above are to be cancelled.

工程名称
PROJECT NAME
图纸名称
DRAWING TITLE


异能无人机学园
地面布置图

次数	NO	修改日期	REVISIONS
△			
△			
△			
△			

设计负责人
PROJECT DIRECTOR
设计
DESIGNED BY
审核
APPROVED BY

业主(甲方)
CLIENT
制图
DRAWN BY
比例
SCALE

图号
DRAWING NO
日期
DATE
P-07

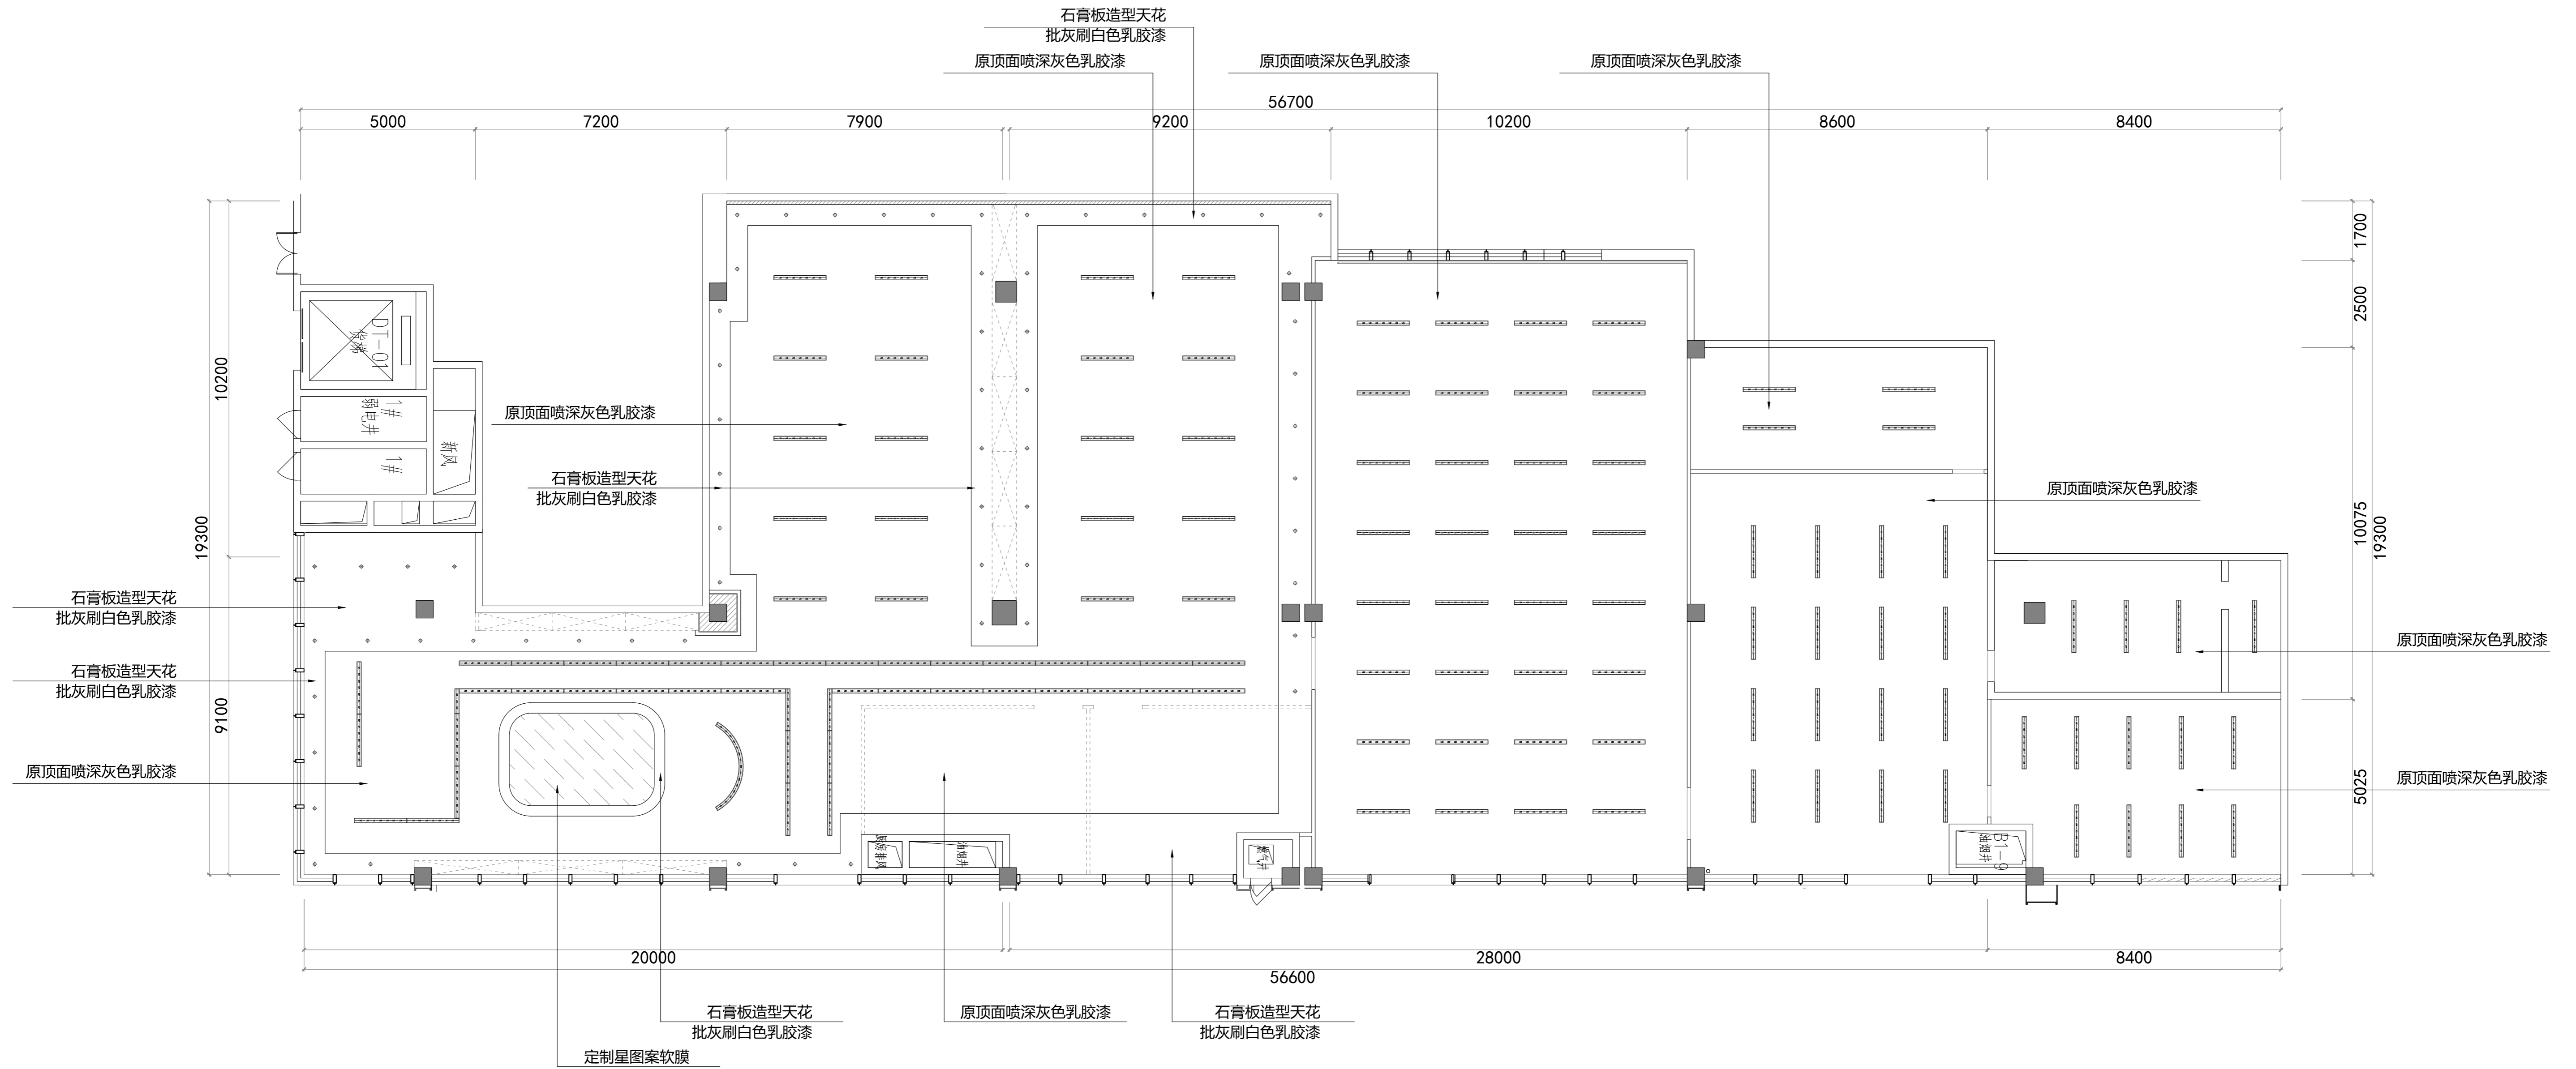

名称	明装筒灯	LED吊线平板灯	嵌入式筒灯	600*600mm灯盘
图例				

此图版权归本公司，所有尺寸以所注数字为准，并在工地核实无误，使用本图时应参阅其它有关图纸，说明和合同，如有矛盾即通知本公司，设计图若有变更应按下栏最后修改记录或变更通知单为准。
This drawings & design are copyright and portion may be reproduced without the written permission of the architect. Written dimensions or grid line measurements to existing work to be checked on site. This drawings is to be read in conjunction with the specification & conditions of contract, and with general architectural plans, structural plans and all immediately of any discrepancy found the drawings not showing the last revisions above are to be cancelled.

工程名称
PROJECT NAME
图纸名称
DRAWING TITLE


异能无人机学园 天花布置图

次数	NO	修改日期	REVISIONS
△			
△			
△			
△			

设计负责人
PROJECT DIRECTOR
设计
DESIGNED BY
审核
APPROVED BY

业主(甲方)
CLIENT
制图
DRAWN BY
比例
SCALE

图号
DRAWING NO
日期
DATE
P-08

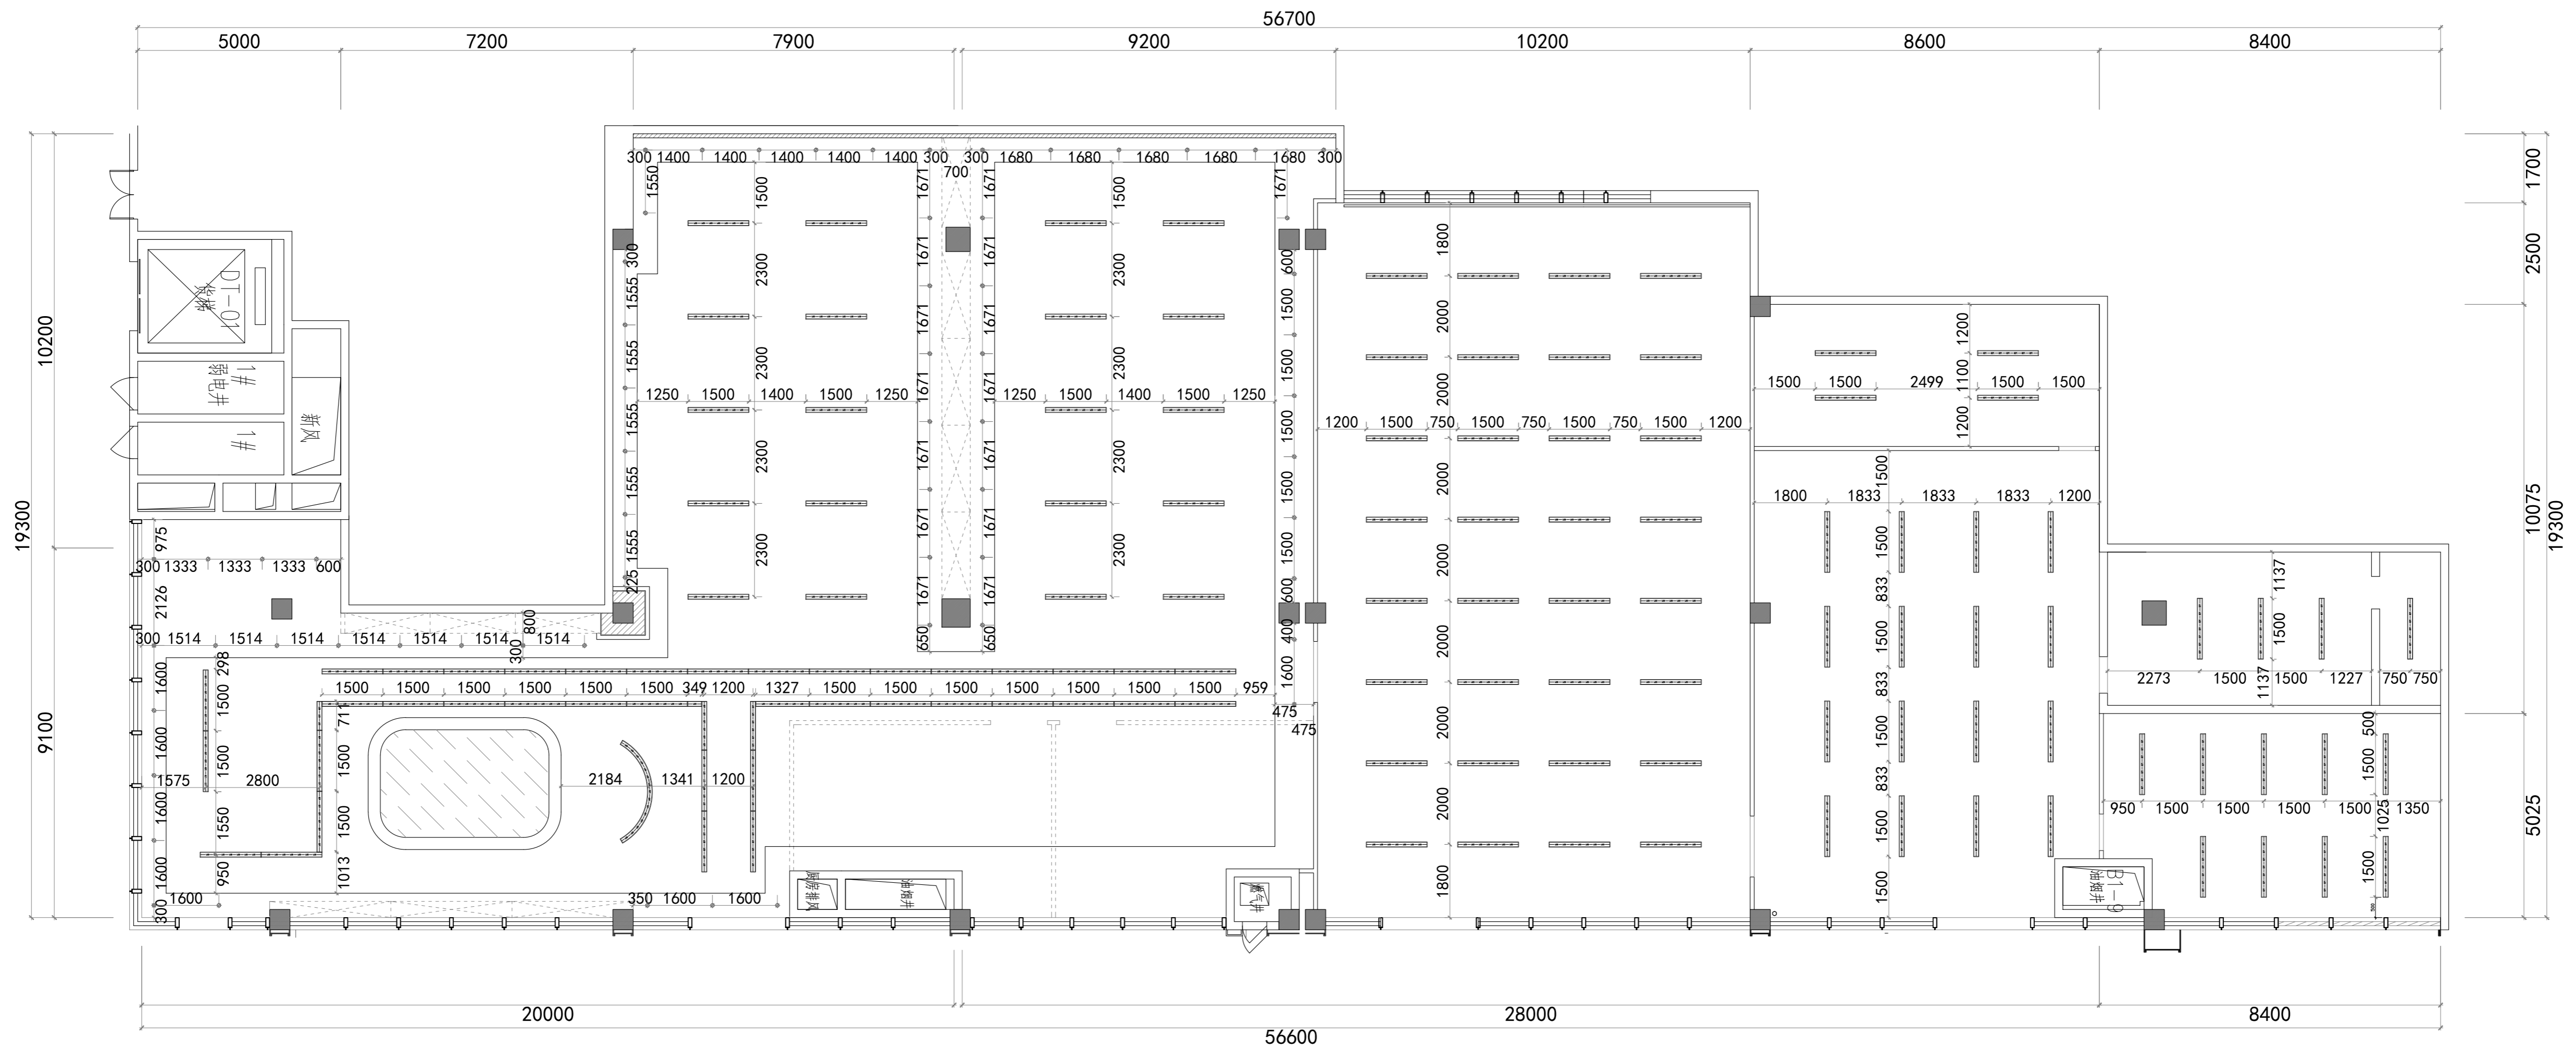

名称	明装筒灯	LED吊线平板灯	嵌入式筒灯	600*600mm灯盘
图例				

此图版权归本公司，所有尺寸以所注数字为准，并在工地核实无误，使用本图时应参阅其它有关图纸、说明和合同，如有矛盾即通知本公司，设计图若有变更应按下栏最后修改记录或变更通知单为准。
 This drawings & design are copyright and portion may be reproduced without the written permission of the architect. The written dimensions or grid line measurements to existing work to be checked on site. This drawings is to be read in conjunction with the specification & conditions of contract, and with general architectural plans, structural plans and all immediately of any discrepancy found the drawings not showing the last revisions above are to be cancelled.

工程名称
PROJECT NAME
异形无人机学园

图纸名称
DRAWING TITLE
灯具定位图

异形无人机学园 灯具定位图

次数	NO	修改日期	REVISIONS
△			
△			
△			
△			

设计负责人
PROJECT DIRECTOR

设计
DESIGNED BY

审核
APPROVED BY


业主(甲方)
CLIENT

制图
DRAWN BY

比例
SCALE

图号
DRAWING NO
P-10

日期
DATE

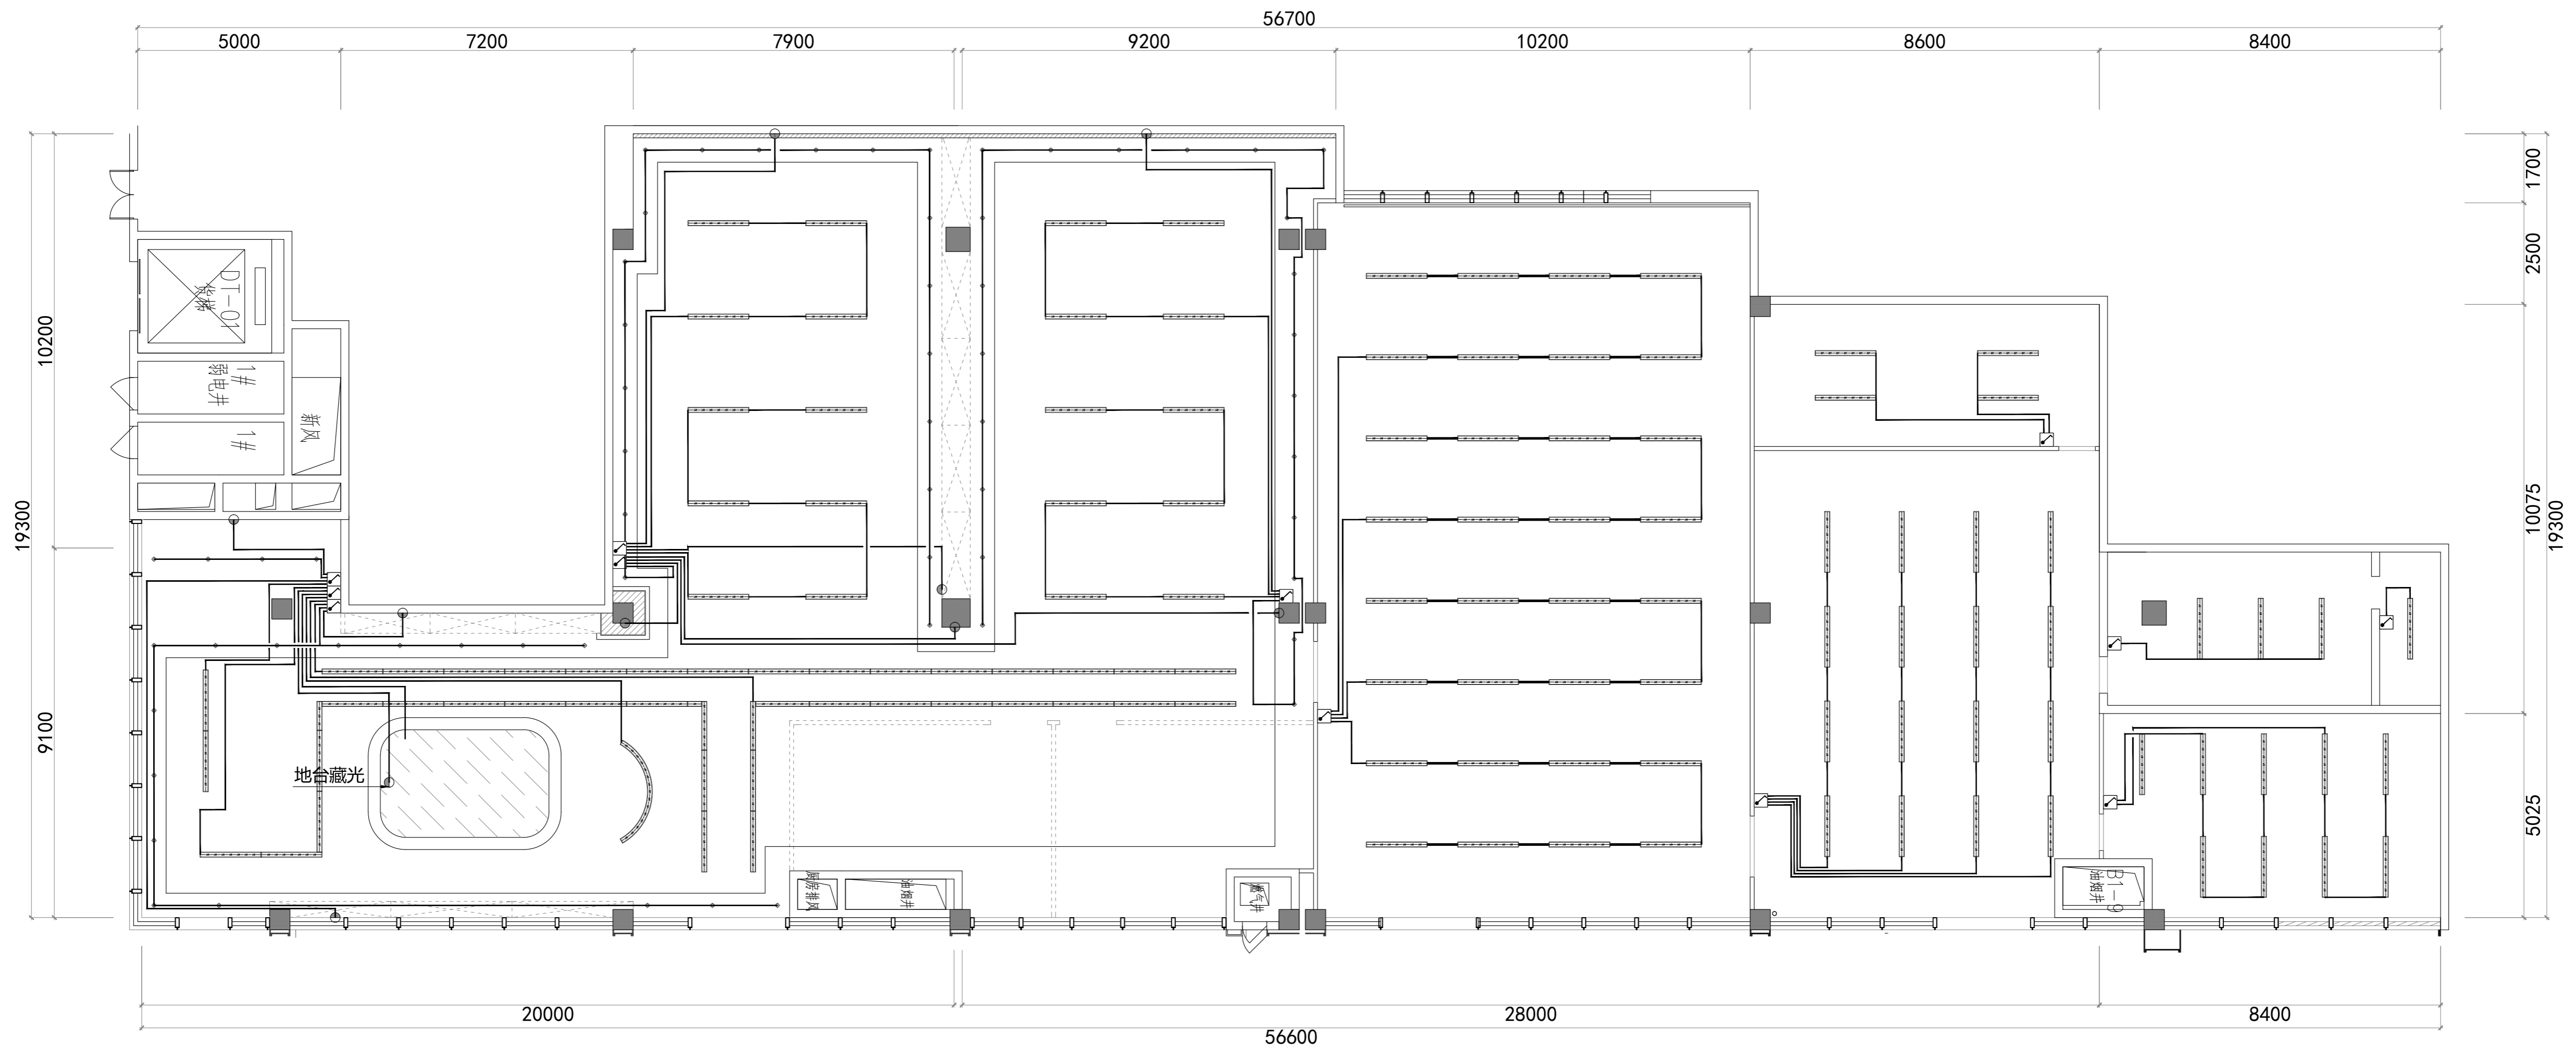

名称	单联单控开关	墙面暗藏光
图例		

此图版权归本公司，所有尺寸以所注数字为准，并在工地核实无误，使用本图时应参阅其它有关图纸、说明和合同，如有矛盾即通知本公司，设计图若有变更应按下栏最后修改记录或变更通知单为准。
 This drawings & design are copyright and portion may be reproduced without the written permission of the architect. The written dimensions or grid line measurements to existing work to be checked on site. This drawings is to be read in conjunction with the specification & conditions of contract, and with general architectural plans, structural plans and all immediately of any discrepancy found the drawings not showing the last revisions above are to be cancelled.

工程名称
PROJECT NAME

图纸名称
DRAWING TITLE

异能无人机学园

开关布置图

次数	NO	修改日期	REVISIONS
△			
△			
△			
△			

设计负责人
PROJECT DIRECTOR

设计
DESIGNED BY

审核
APPROVED BY

业主(甲方)
CLIENT


制图
DRAWN BY

比例
SCALE

图号
DRAWING NO

日期
DATE

P-11

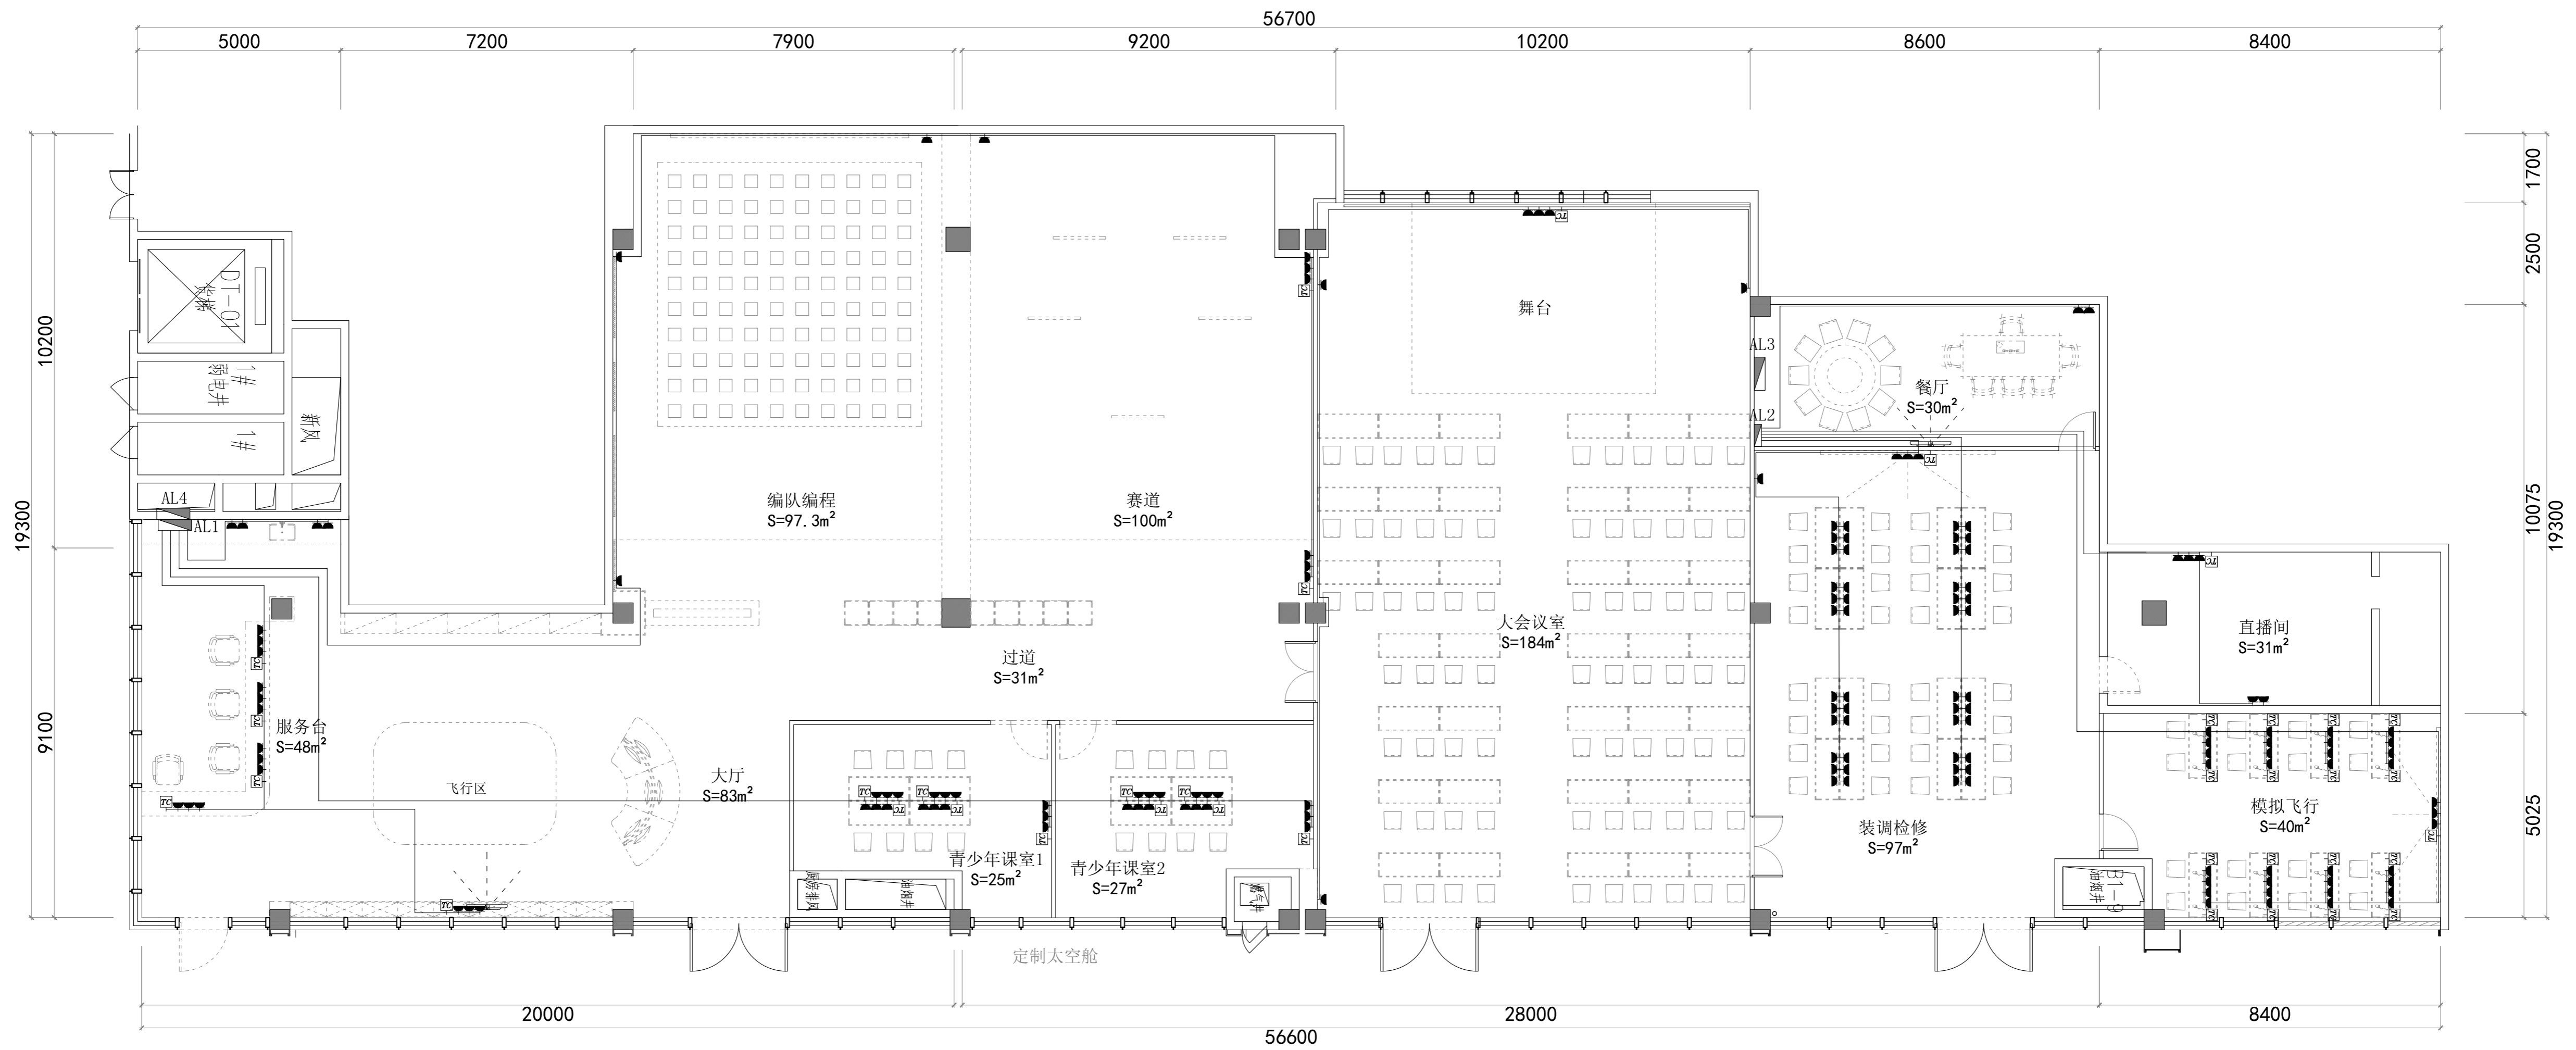


名称	网络插座	普通插座	配电箱
图例			

此图版权归本公司，所有尺寸以所注数字为准，并在工地核实无误，使用本图时应参阅其它有关图纸，说明和合同，如有矛盾即通知本公司，设计图若有变更应按下栏最后修改记录或变更通知单为准。
This drawings & design are copyright and portion may be reproduced without the written permission of the architect. All written dimensions or grid line measurements to existing work to be checked on site. This drawings is to be read in conjunction with the specification & conditions of contract, and with general architectural plans, structural plans and all immediately of any discrepancy found the drawings not showing the last revisions above are to be cancelled.

工程名称 PROJECT NAME	异能无人机学园		
图纸名称 DRAWING TITLE	插座布置图		
次数 NO	修改日期	REVISIONS	
△			
△			
△			
△			

设计负责人 PROJECT DIRECTOR	业主(甲方) CLIENT		
设计 DESIGNED BY	制图 DRAWN BY	图号 DRAWING NO	P-12
审核 APPROVED BY	比例 SCALE	日期 DATE	

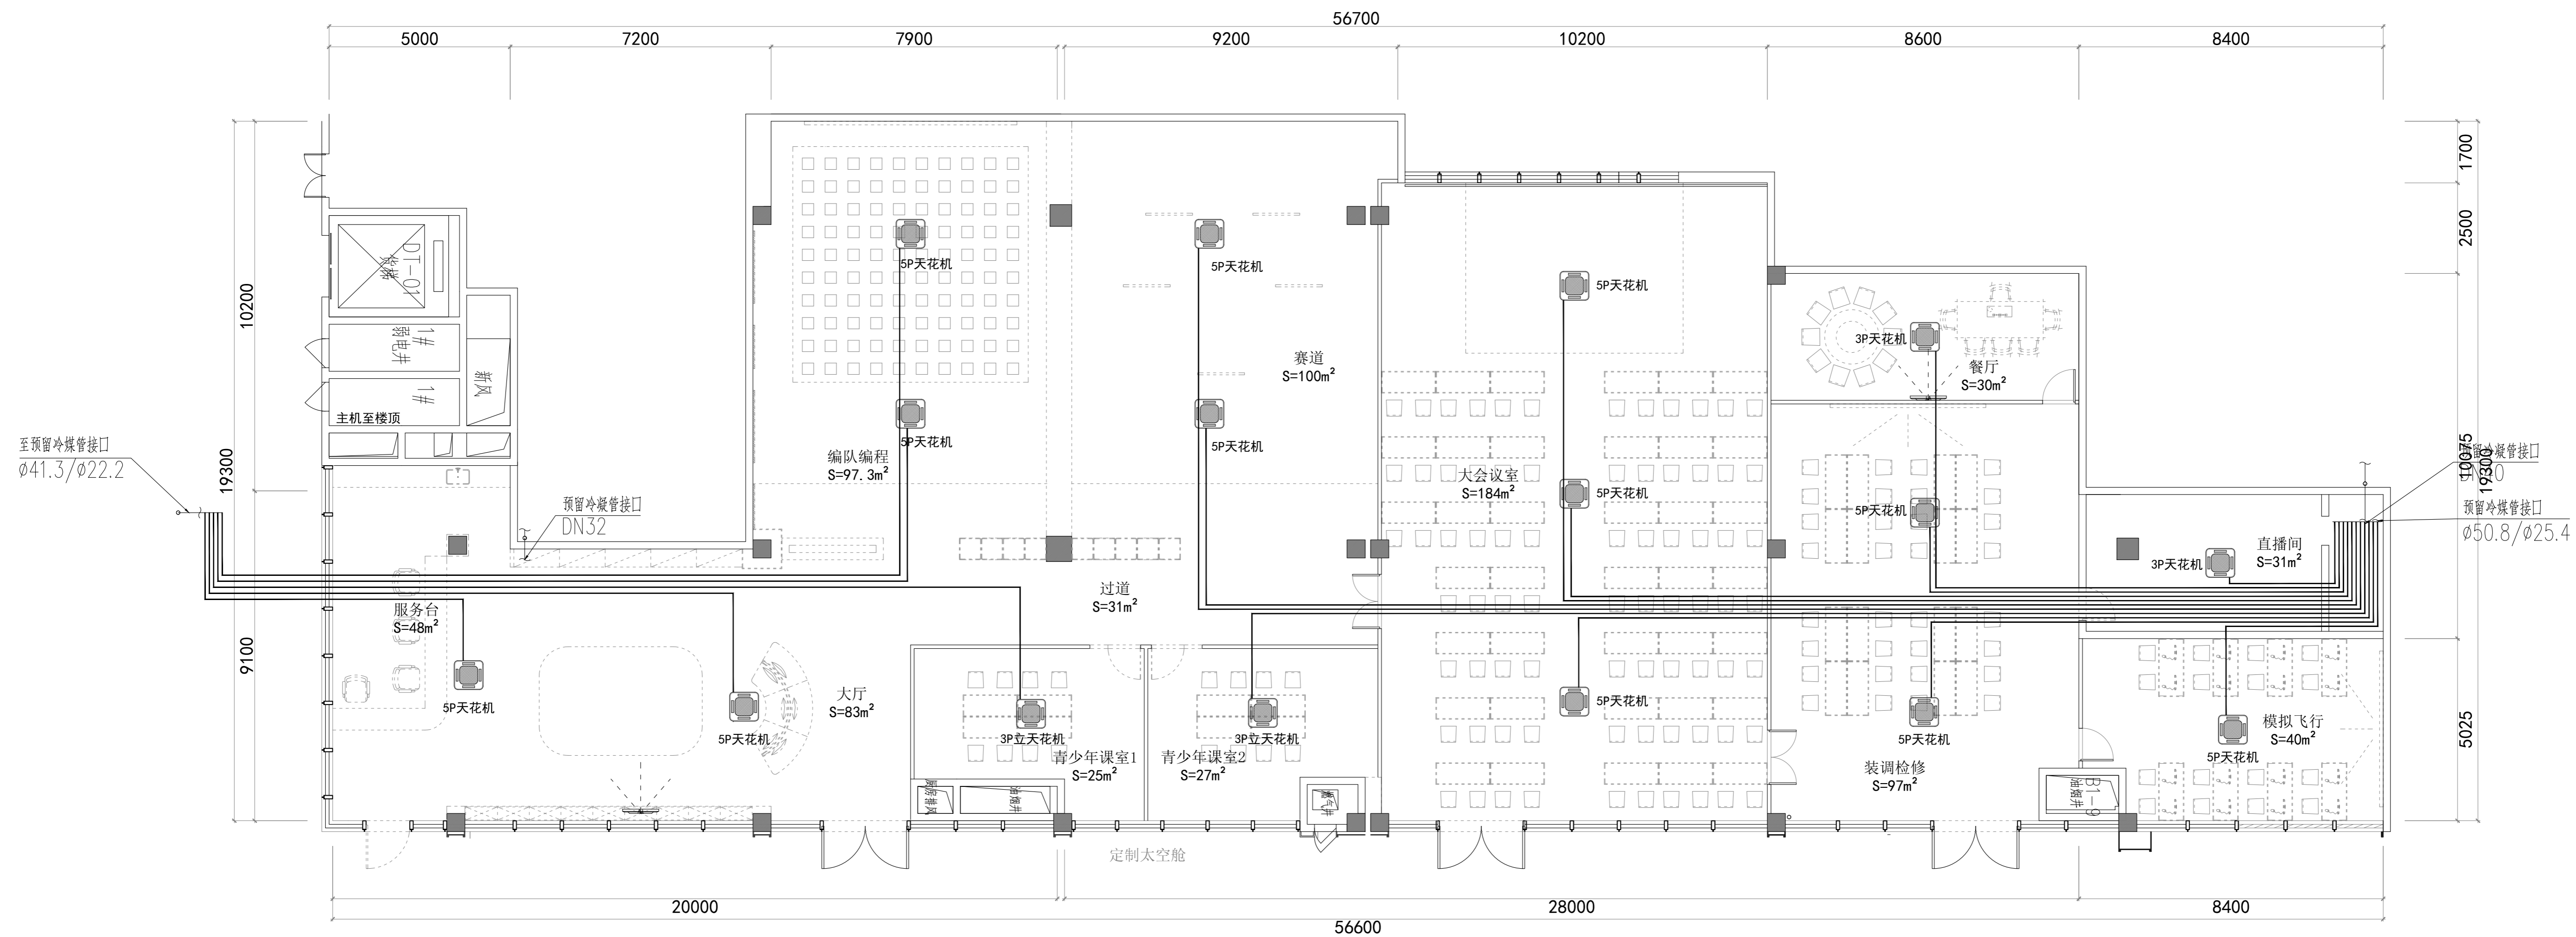

此图版权归本公司，所有尺寸以所注数字为准，并在工地核实无误，使用本图时应参阅其它有关图纸，说明和合同，如有矛盾即通知本公司，设计图若有变更应按下列最后修改记录或变更通知单为准。
 This drawings & design are copyright and portion may be reproduced without the written permission of the architect. All written dimensions or grid line measurements to existing work to be checked on site. This drawings is to be read in conjunction with the specification & conditions of contract, and with general architectural plans, structural plans and all immediately of any discrepancy found the drawings not showing the last revisions above are to be cancelled.

工程名称
PROJECT NAME

图纸名称
DRAWING TITLE

异能无人机学园
空调布置图

次数	NO	修改日期	REVISIONS
△			
△			
△			
△			

设计负责人
PROJECT DIRECTOR

设计
DESIGNED BY


审核
APPROVED BY

业主(甲方)
CLIENT

制图
DRAWN BY

比例
SCALE

图号 DRAWING NO	P-13
日期 DATE	

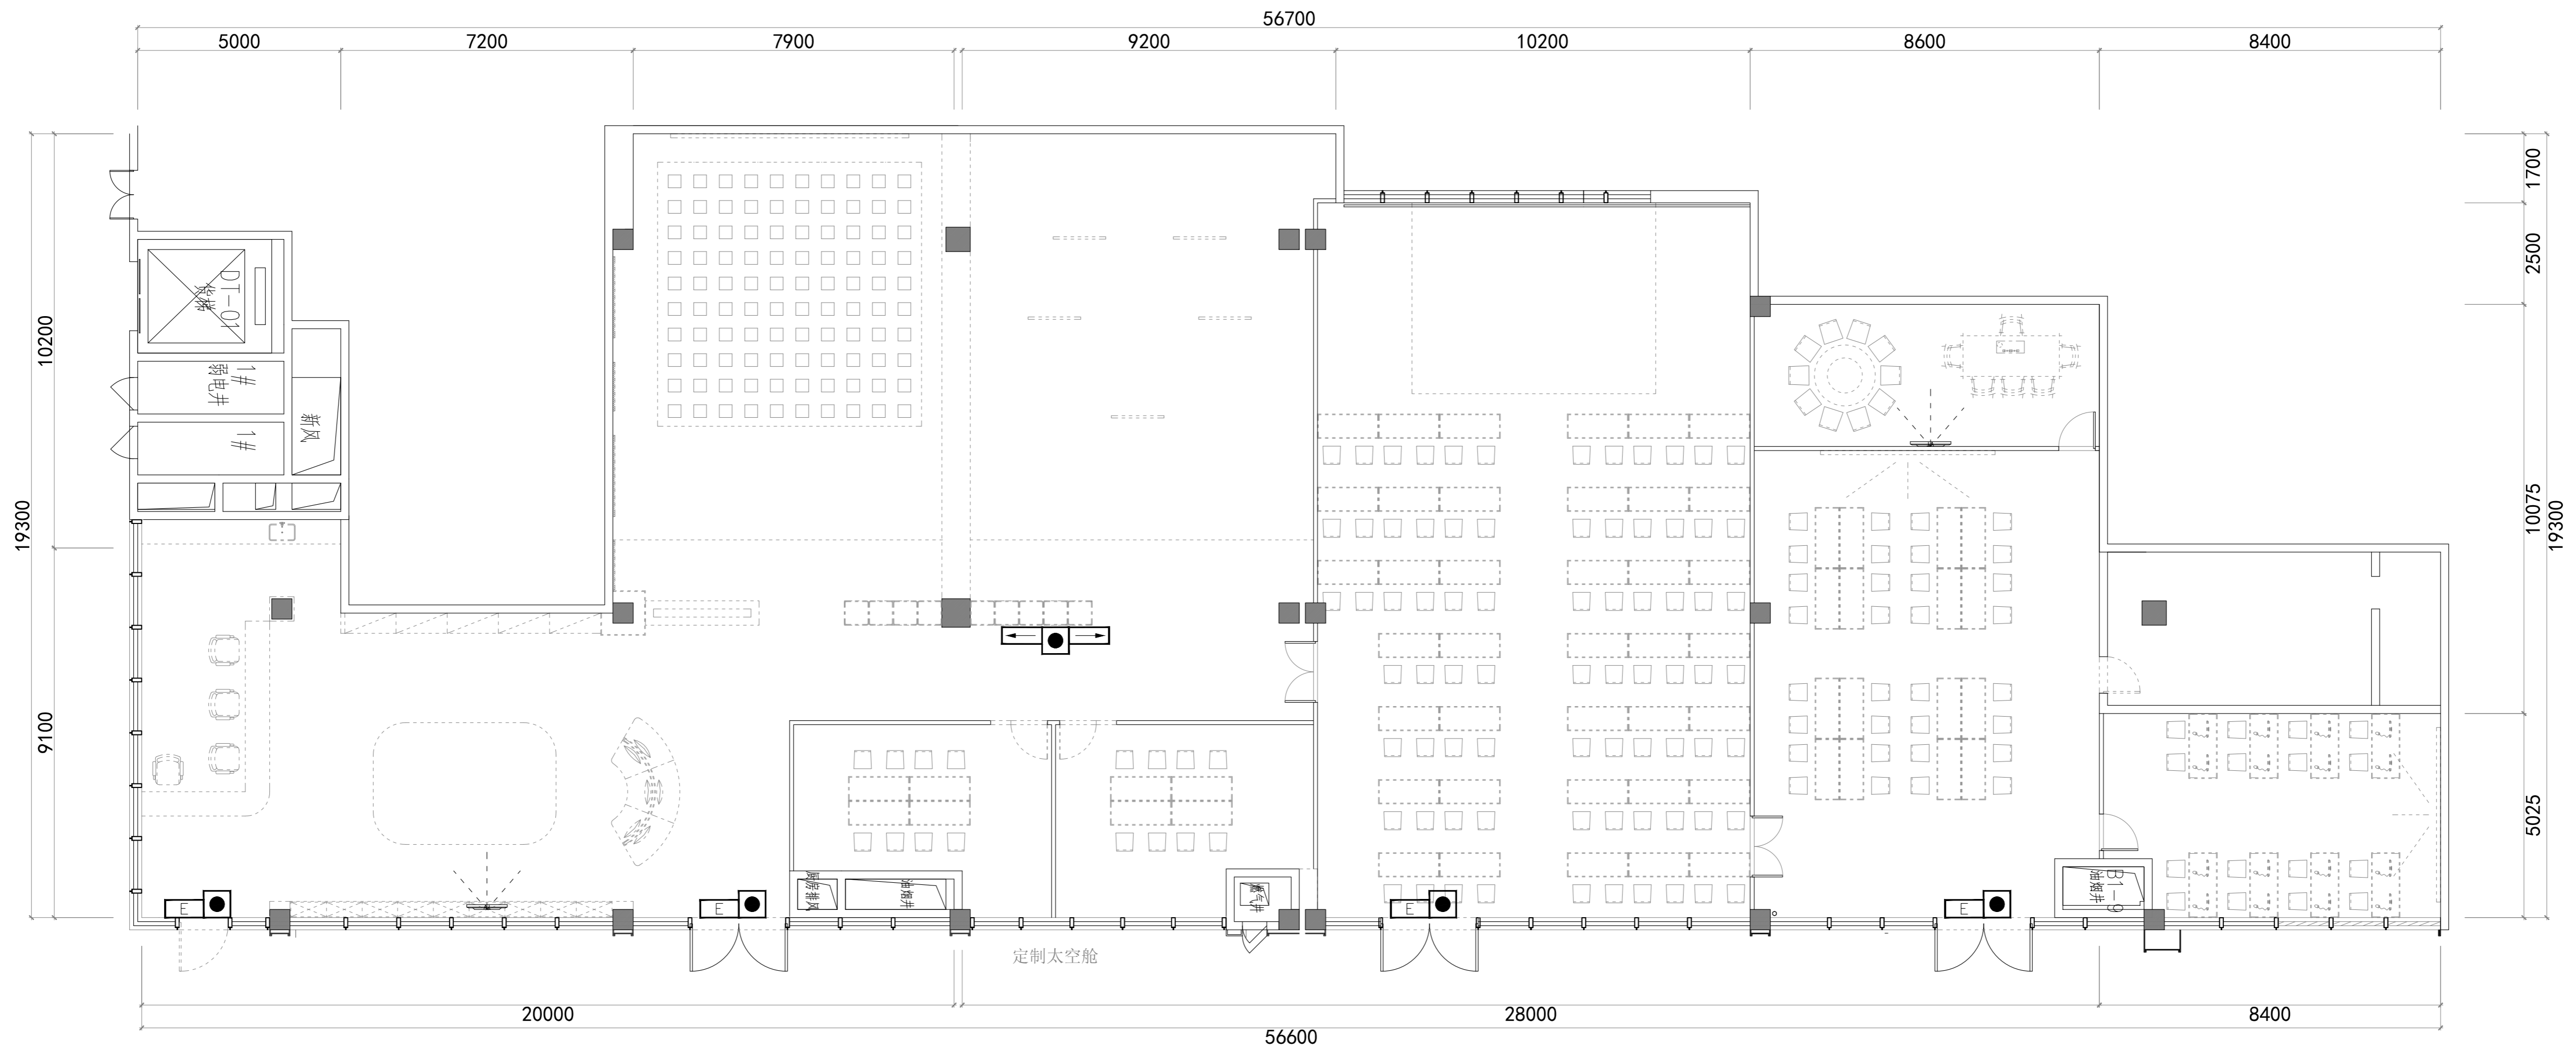

名称	应急出口标志灯	疏散指示灯	双头应急灯
图例			

此图版权归本公司，所有尺寸以所注数字为准，并在工地核实无误，使用本图时应参阅其它有关图纸、说明和合同，如有矛盾即通知本公司，设计图若有变更应按下栏最后修改记录或变更通知单为准。
 This drawings & design are copyright and portion may be reproduced without the written permission of the architect. All written dimensions or grid line measurements to existing work to be checked on site. This drawings is to be read in conjunction with the specification & conditions of contract, and with general architectural plans, structural plans and all immediately of any discrepancy found the drawings not showing the last revisions above are to be cancelled.

工程名称
PROJECT NAME

图纸名称
DRAWING TITLE

异能无人机学园

应急照明图

次数	NO	修改日期	REVISIONS
△			
△			
△			
△			

设计负责人
PROJECT DIRECTOR

设计
DESIGNED BY

审核
APPROVED BY

业主(甲方)
CLIENT


制图
DRAWN BY

比例
SCALE

图号
DRAWING NO

日期
DATE

P-14

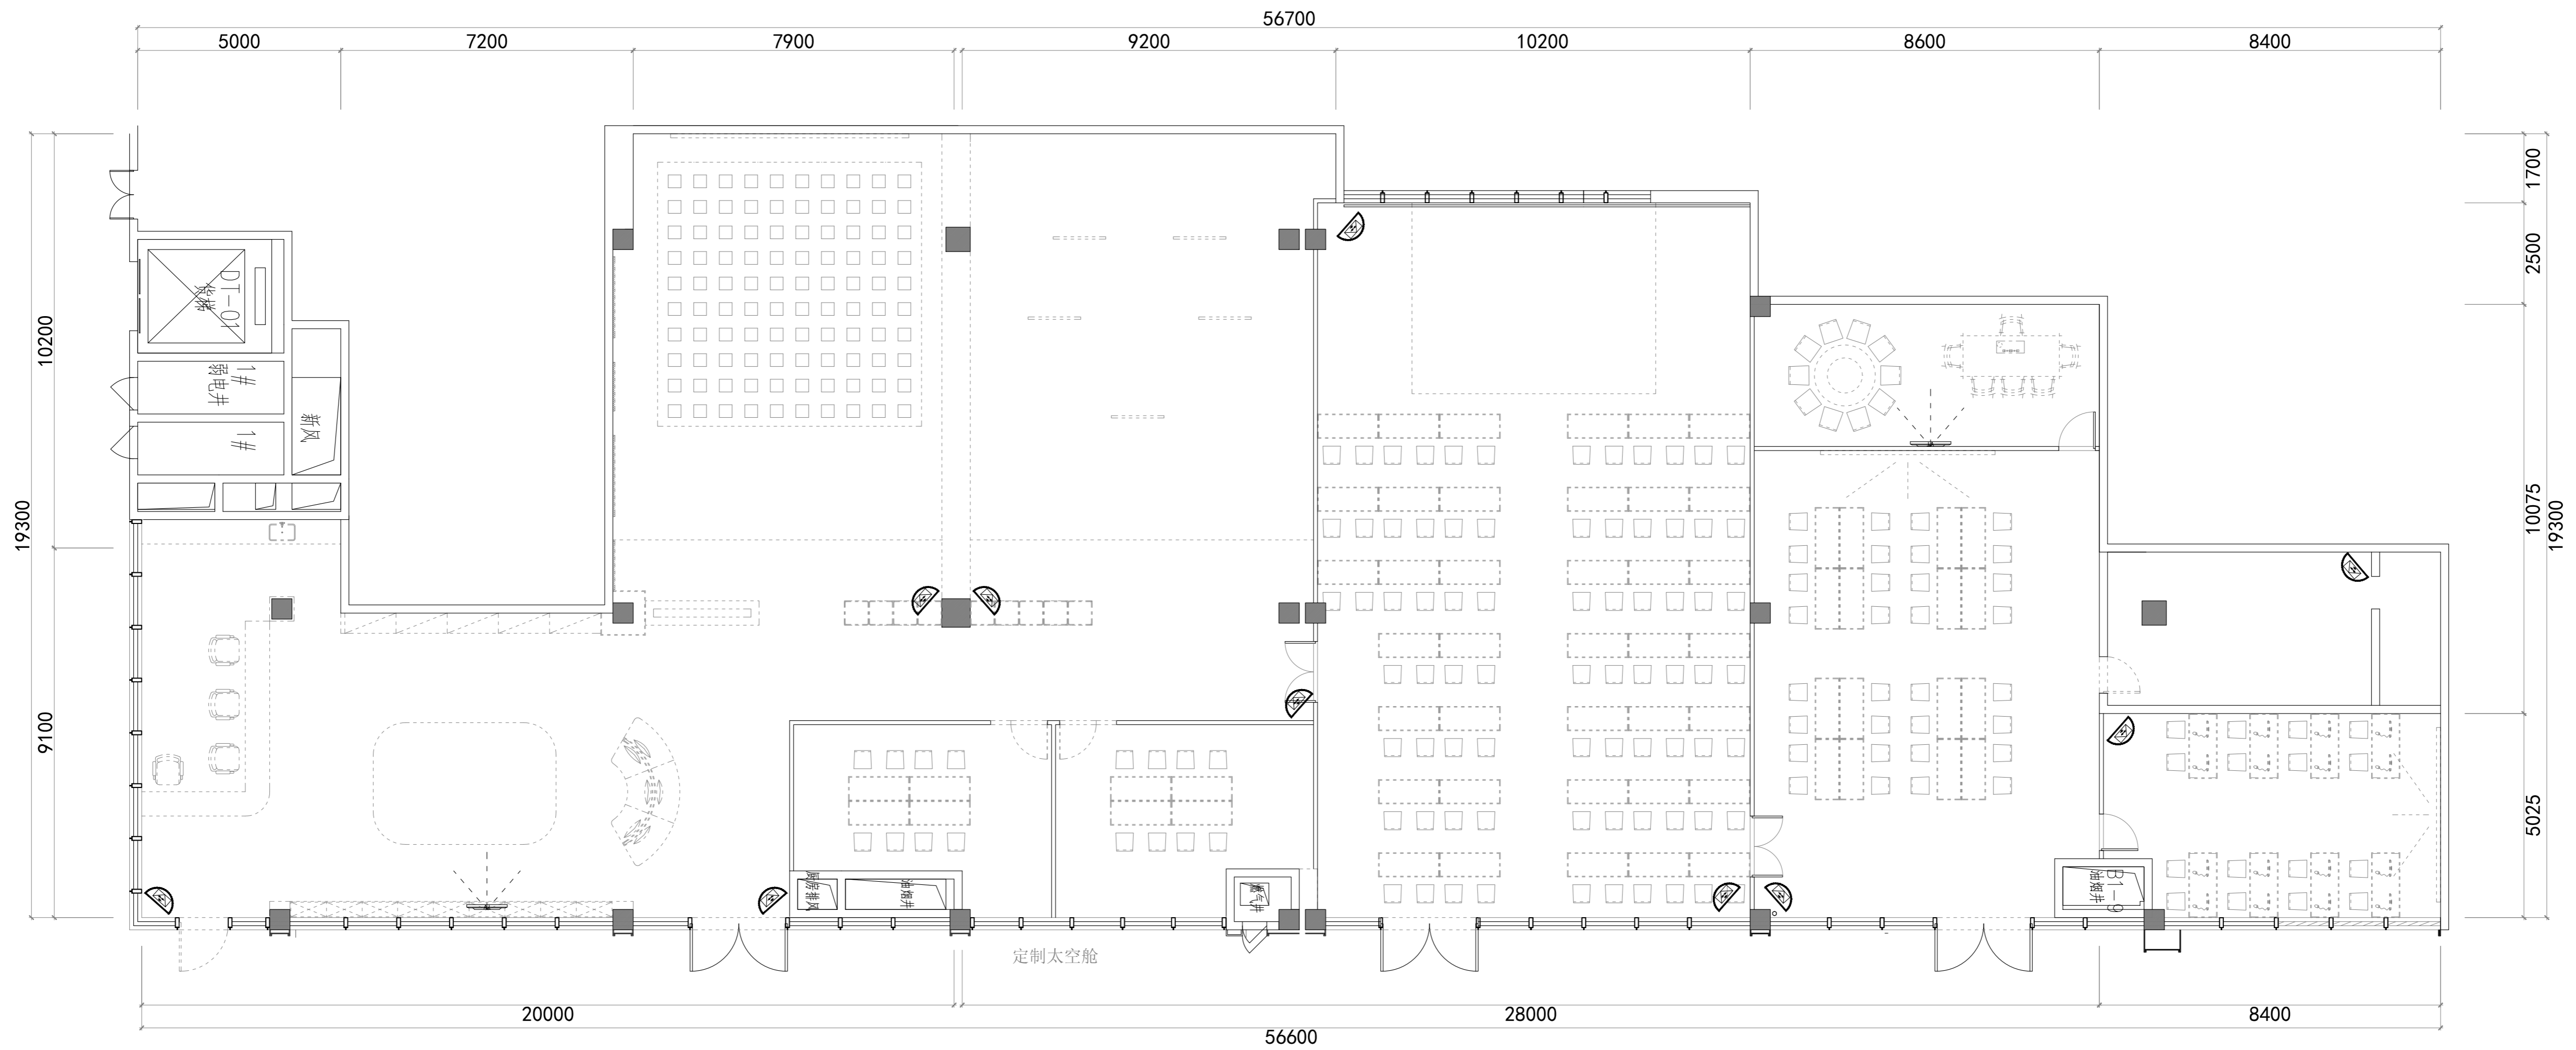

名称	摄像头
图例	

此图版权归本公司，所有尺寸以所注数字为准，并在工地核实无误，使用本图时应参阅其它有关图纸、说明和合同，如有矛盾即通知本公司，设计图若有变更应按下栏最后修改记录或变更通知单为准。
 This drawings & design are copyright and portion may be reproduced without the written permission of the architect. All written dimensions or grid line measurements to existing work to be checked on site. This drawings is to be read in conjunction with the specification & conditions of contract, and with general architectural plans, structural plans and all immediately of any discrepancy found the drawings not showing the last revisions above are to be cancelled.

工程名称
PROJECT NAME

异能无人机学园

监控布置图

次数	NO	修改日期	REVISIONS
△			
△			
△			
△			

设计负责人
PROJECT DIRECTOR

设计
DESIGNED BY

审核
APPROVED BY

业主(甲方)
CLIENT


制图
DRAWN BY

比例
SCALE

图号
DRAWING NO

日期
DATE

P-15

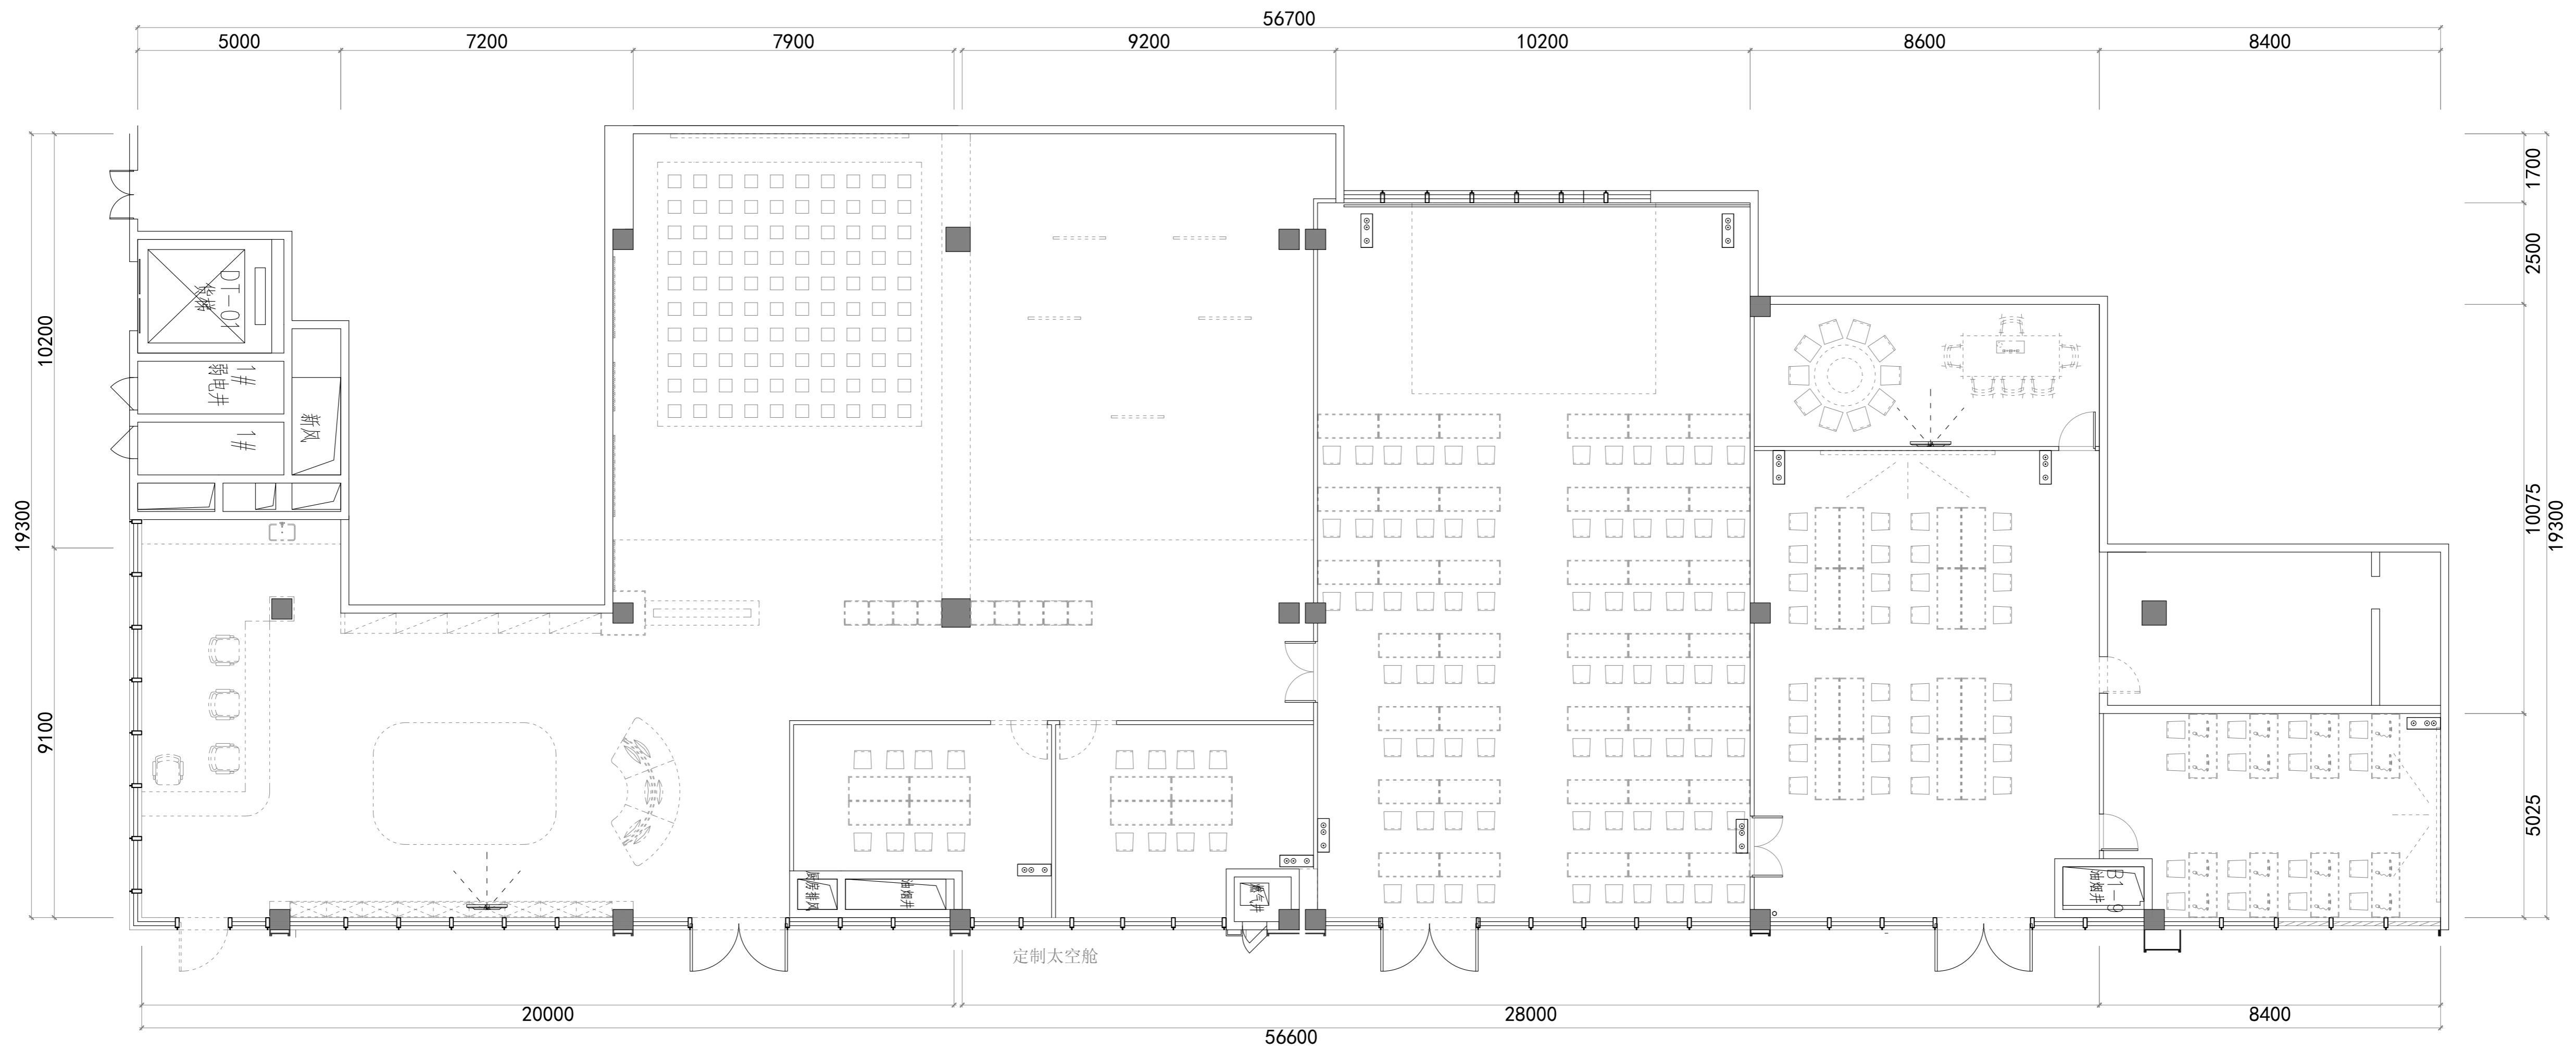

名称	音响
图例	⊗ ⊙

此图版权归本公司，所有尺寸以所注数字为准，并在工地核实无误，使用本图时应参阅其它有关图纸、说明和合同，如有矛盾即通知本公司，设计图若有变更应按下栏最后修改记录或变更通知单为准。
 This drawings & design are copyright and portion may be reproduced without the written permission of the architect. The written dimensions or grid line measurements to existing work to be checked on site. This drawings is to be read in conjunction with the specification & conditions of contract, and with general architectural plans, structural plans and all immediately of any discrepancy found the drawings not showing the last revisions above are to be cancelled.

工程名称
PROJECT NAME

异能无人机学园

监控布置图

次数	NO	修改日期	REVISIONS
△			
△			
△			
△			

设计负责人
PROJECT DIRECTOR

设计
DESIGNED BY

审核
APPROVED BY

业主(甲方)
CLIENT


制图
DRAWN BY

比例
SCALE

图号
DRAWING NO

日期
DATE

P-16

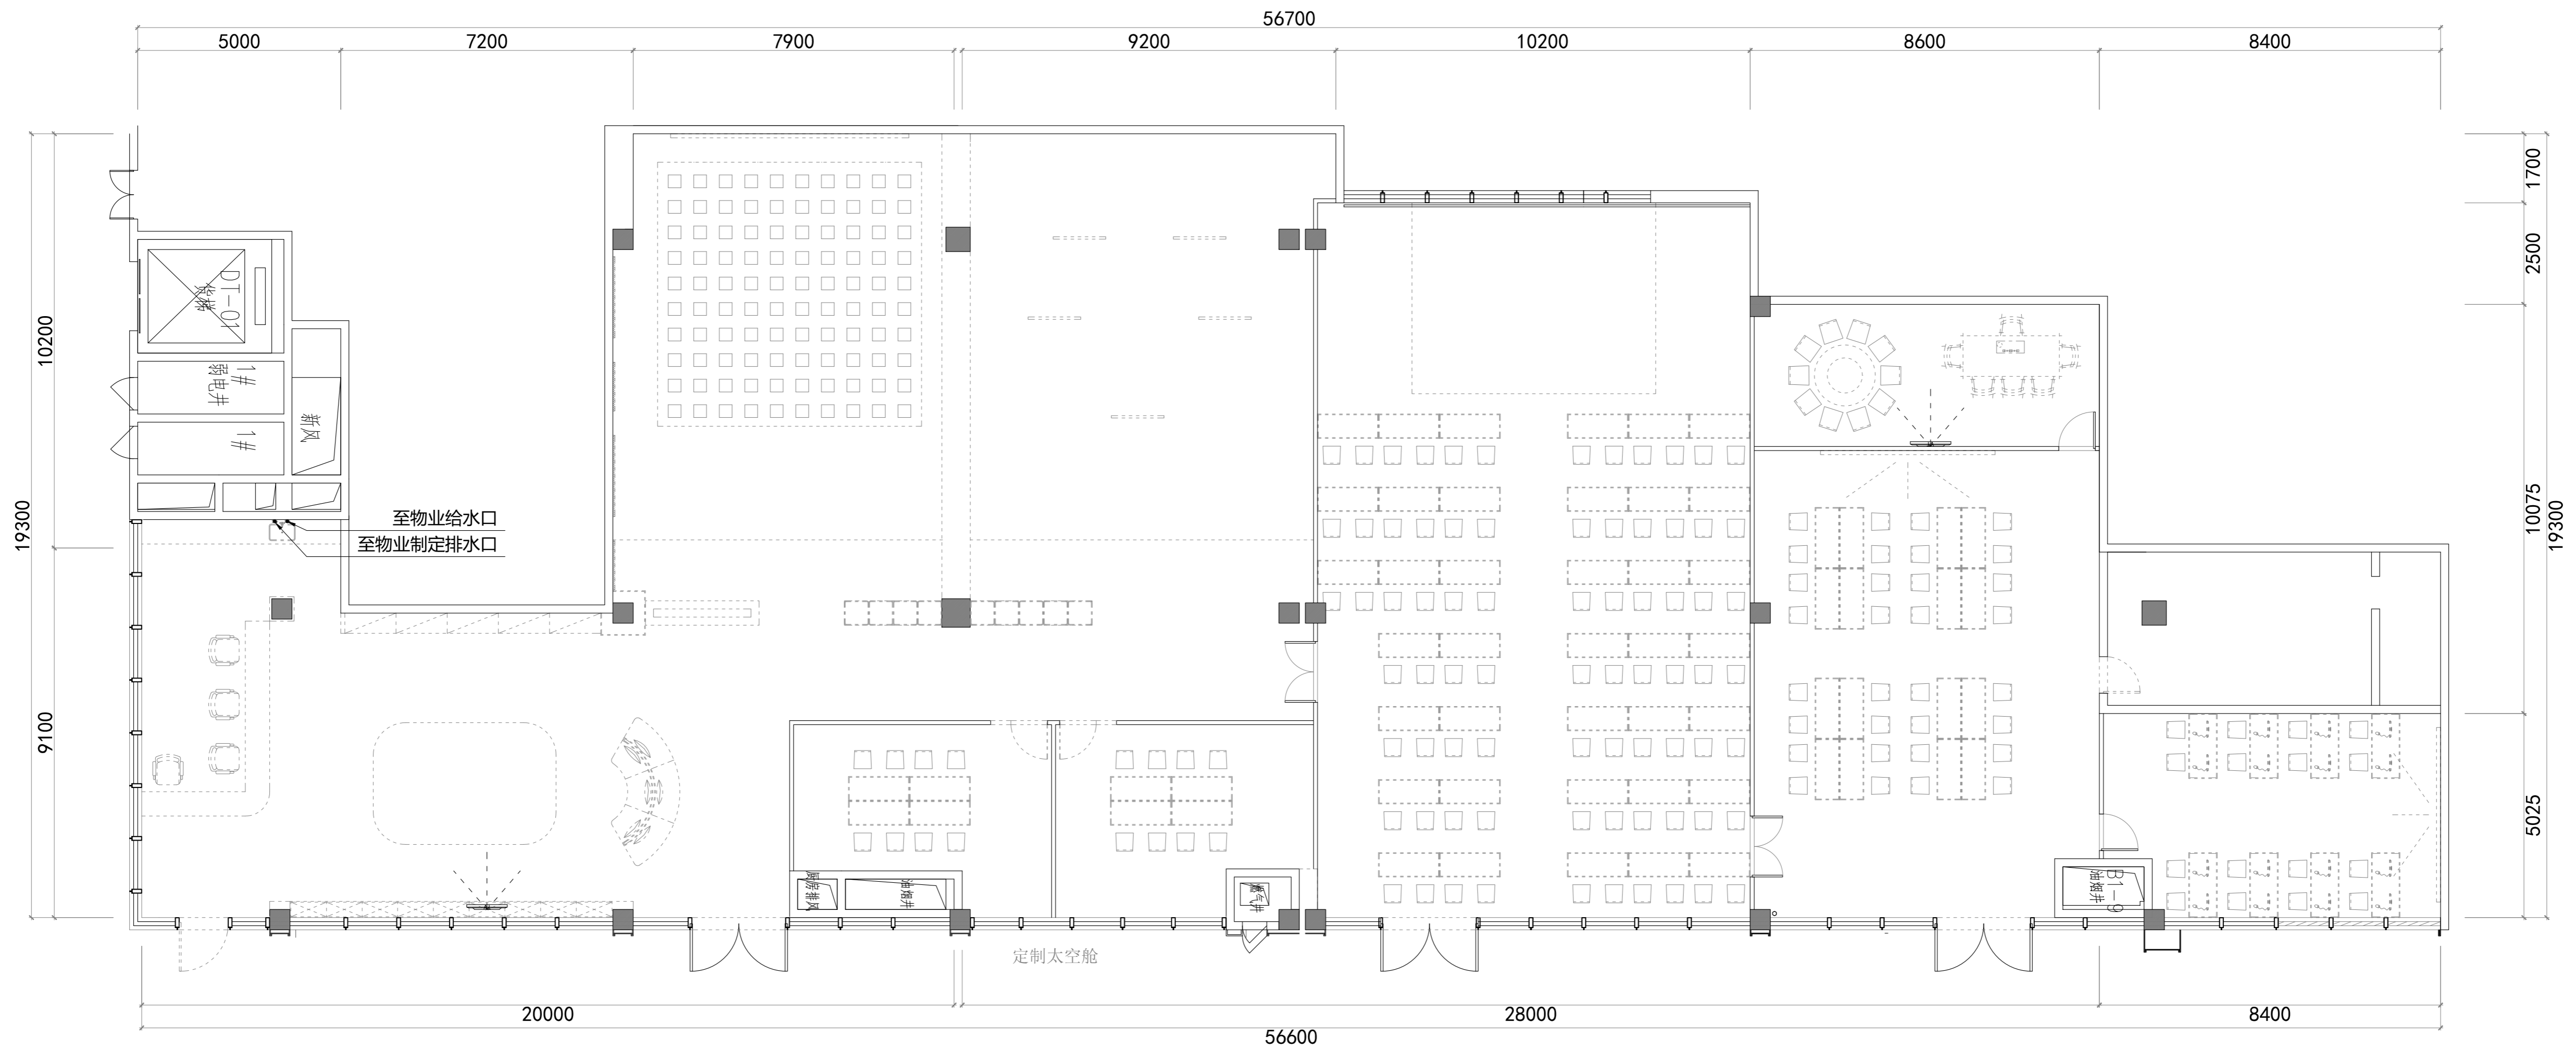

名称	音响
图例	☉ ☉

此图版权归本公司，所有尺寸以所注数字为准，并在工地核实无误，使用本图时应参阅其它有关图纸、说明和合同，如有矛盾即通知本公司，设计图若有变更应按下栏最后修改记录或变更通知单为准。
 This drawings & design are copyright and portion may be reproduced without the written permission of the architect. All written dimensions or grid line measurements to existing work to be checked on site. This drawings is to be read in conjunction with the specification & conditions of contract, and with general architectural plans, structural plans and all immediately of any discrepancy found the drawings not showing the last revisions above are to be cancelled.

工程名称
PROJECT NAME

图纸名称
DRAWING TITLE

异能无人机学园

水路布置图

次数	NO	修改日期	REVISIONS
△			
△			
△			
△			

设计负责人
PROJECT DIRECTOR

设计
DESIGNED BY

审核
APPROVED BY

业主(甲方)
CLIENT




制图
DRAWN BY

比例
SCALE

图号
DRAWING NO

日期
DATE

P-17

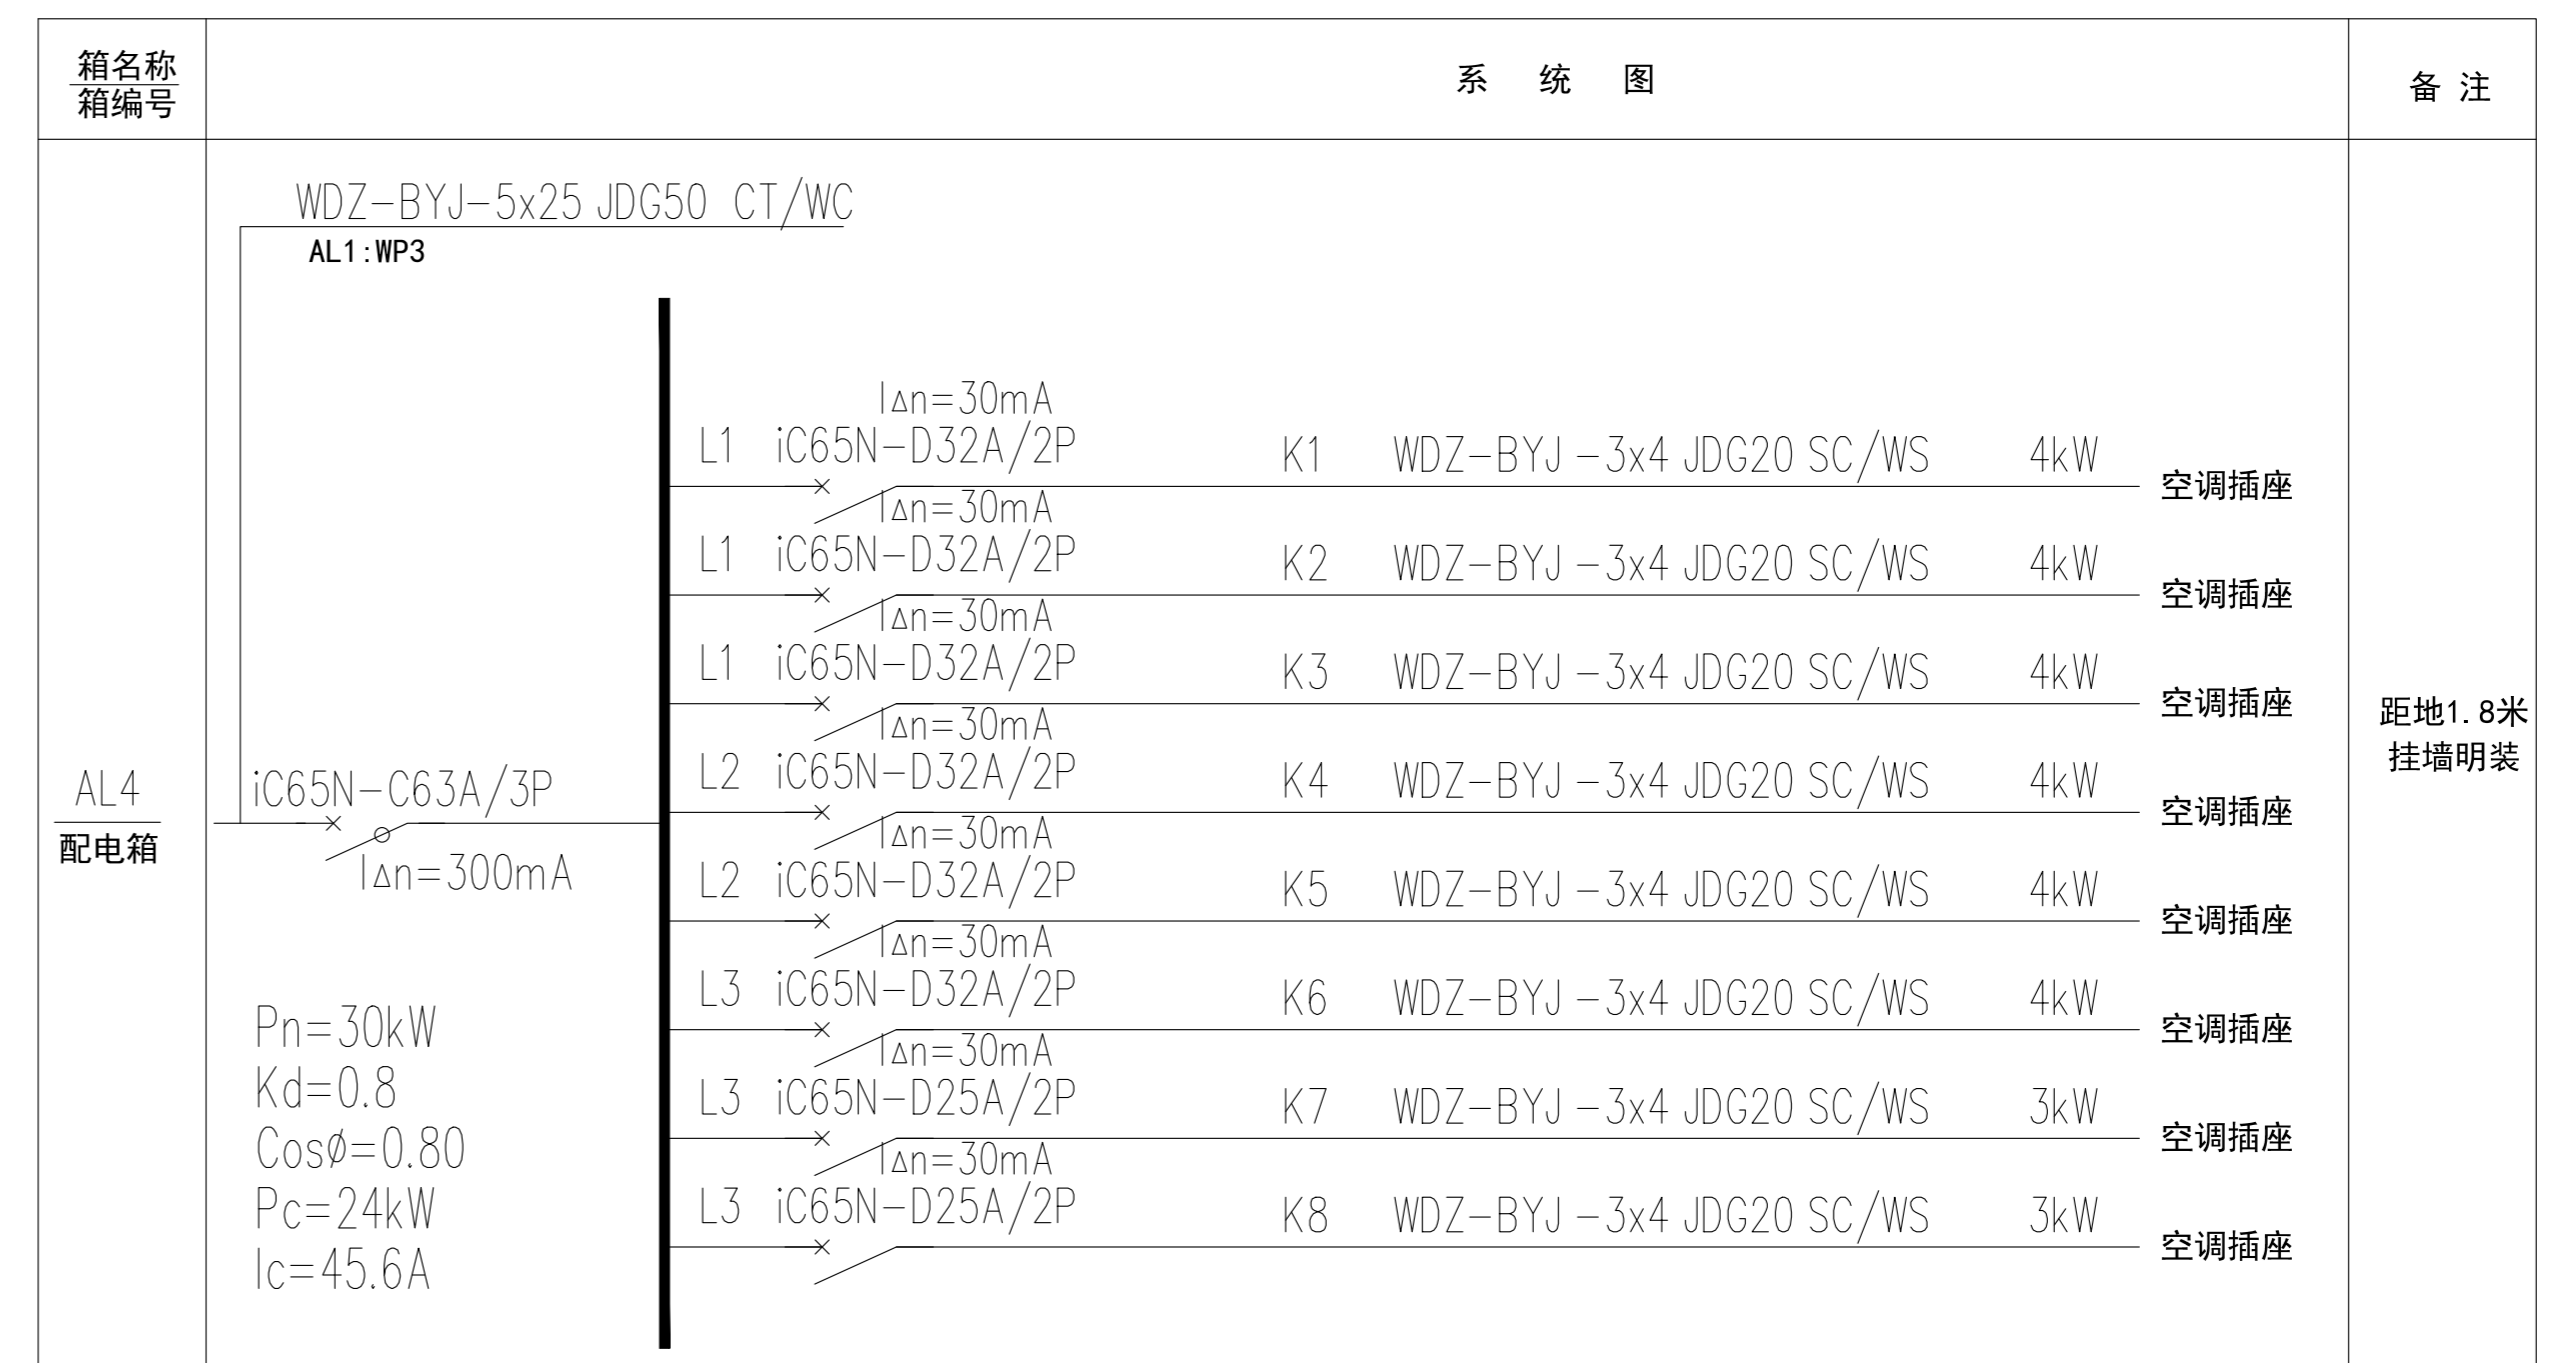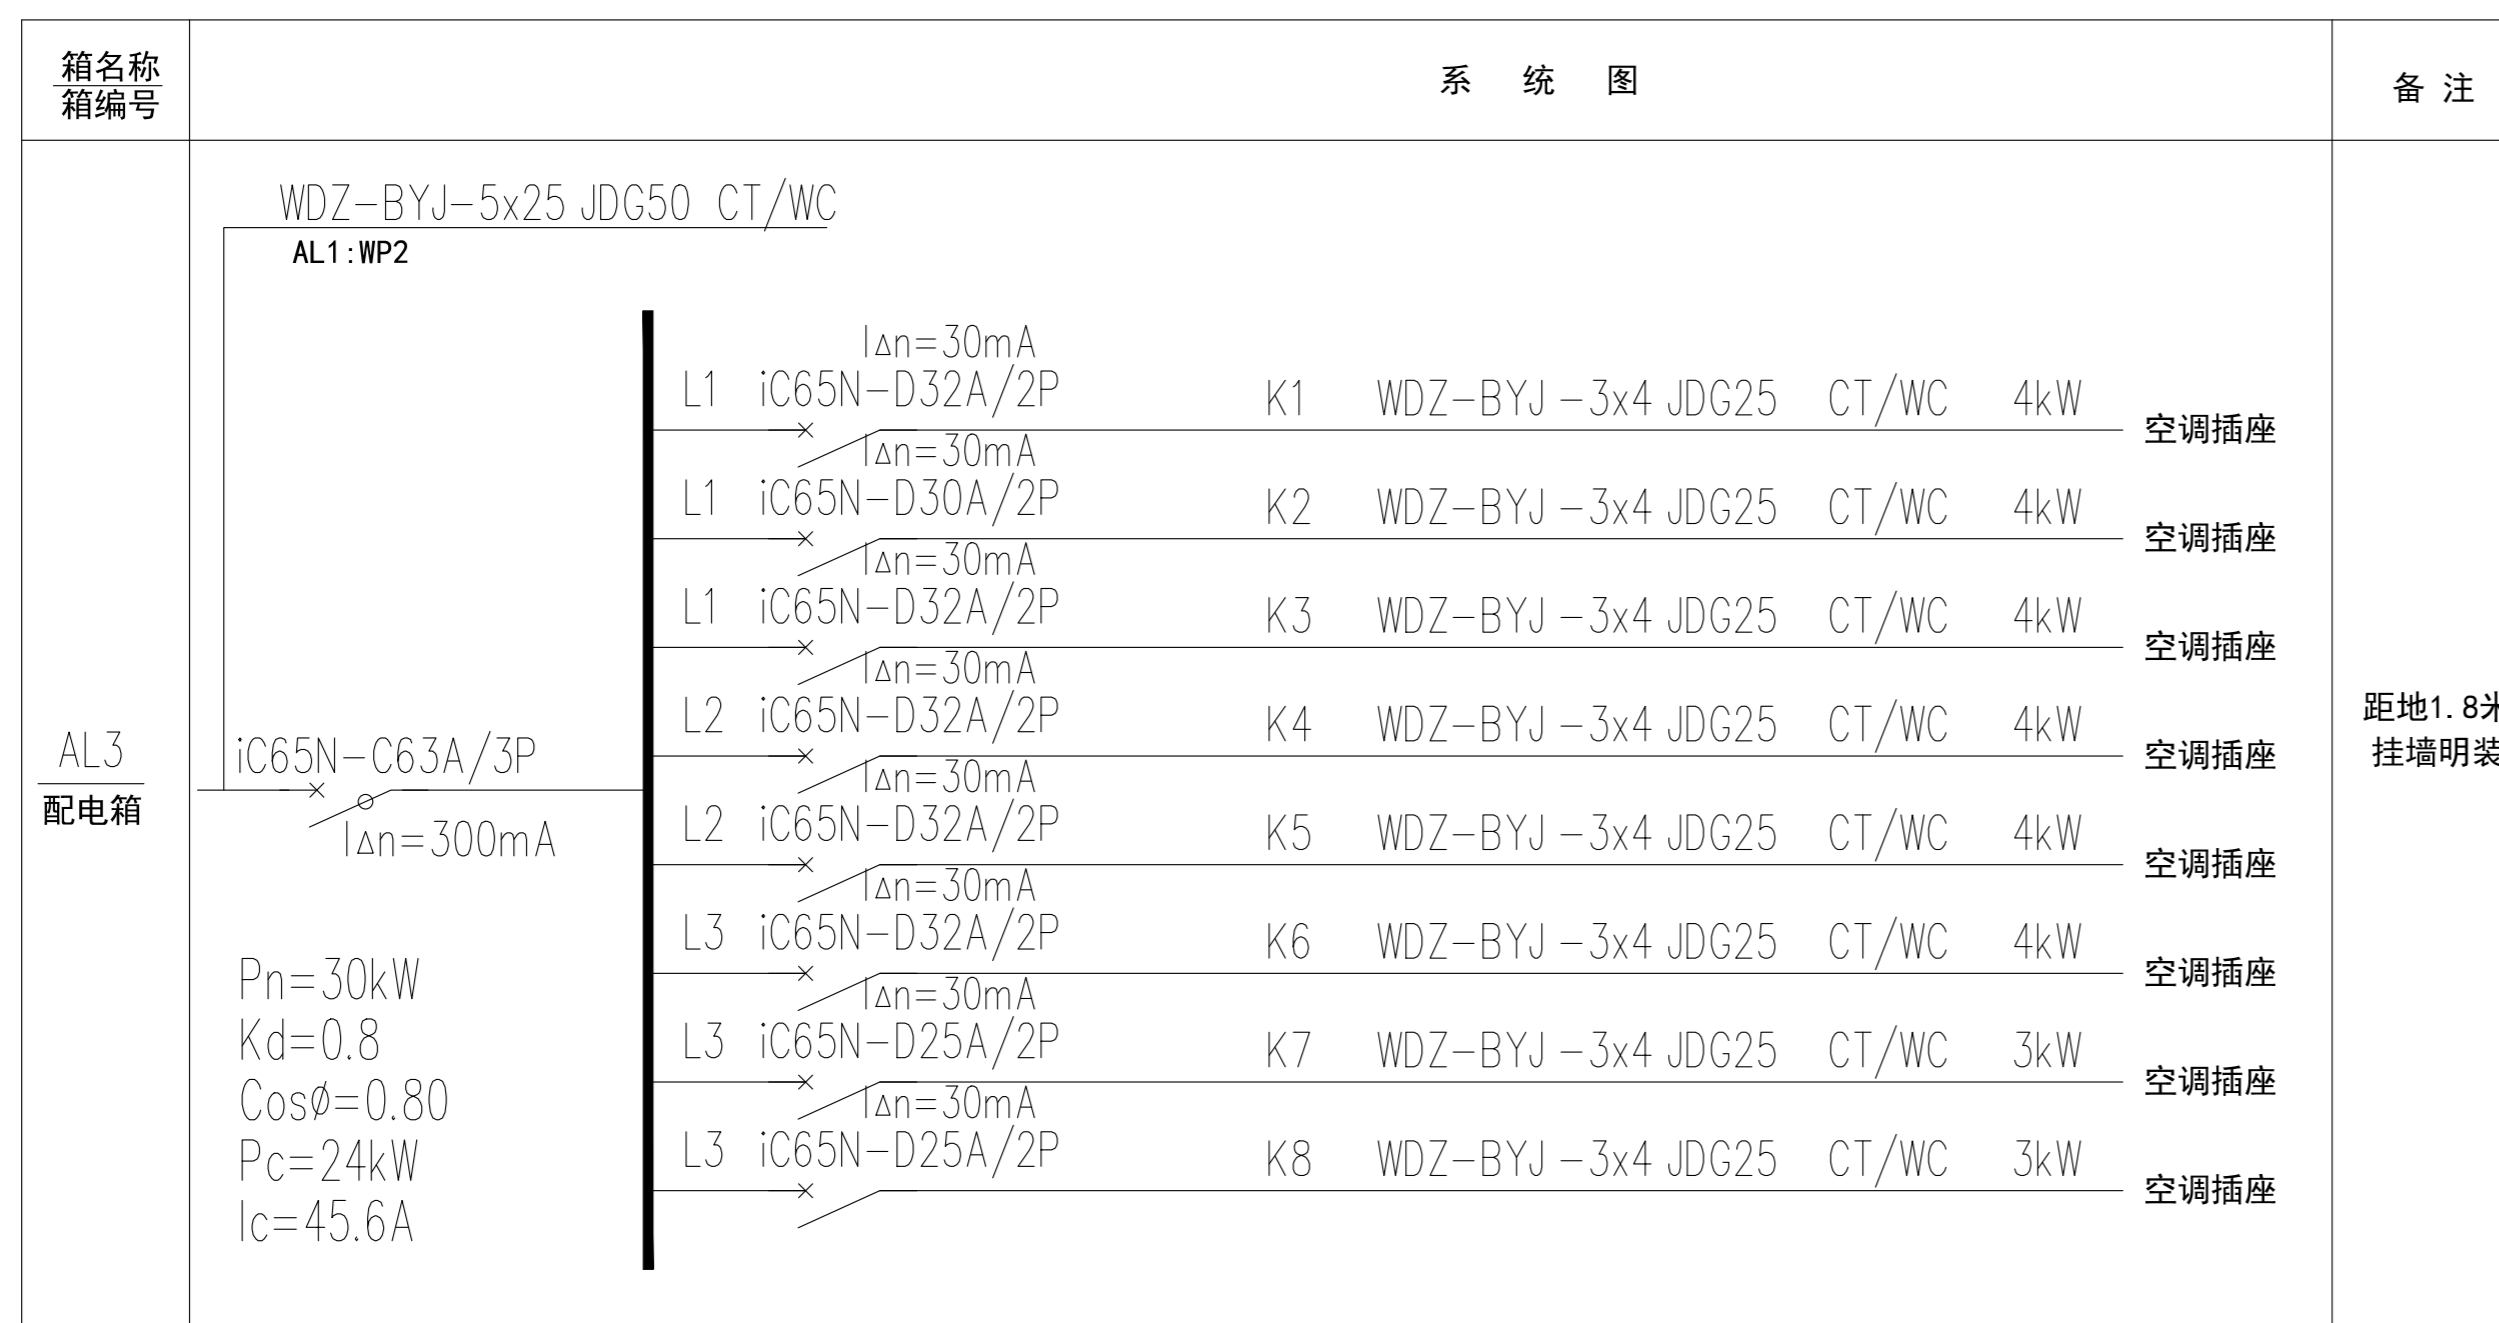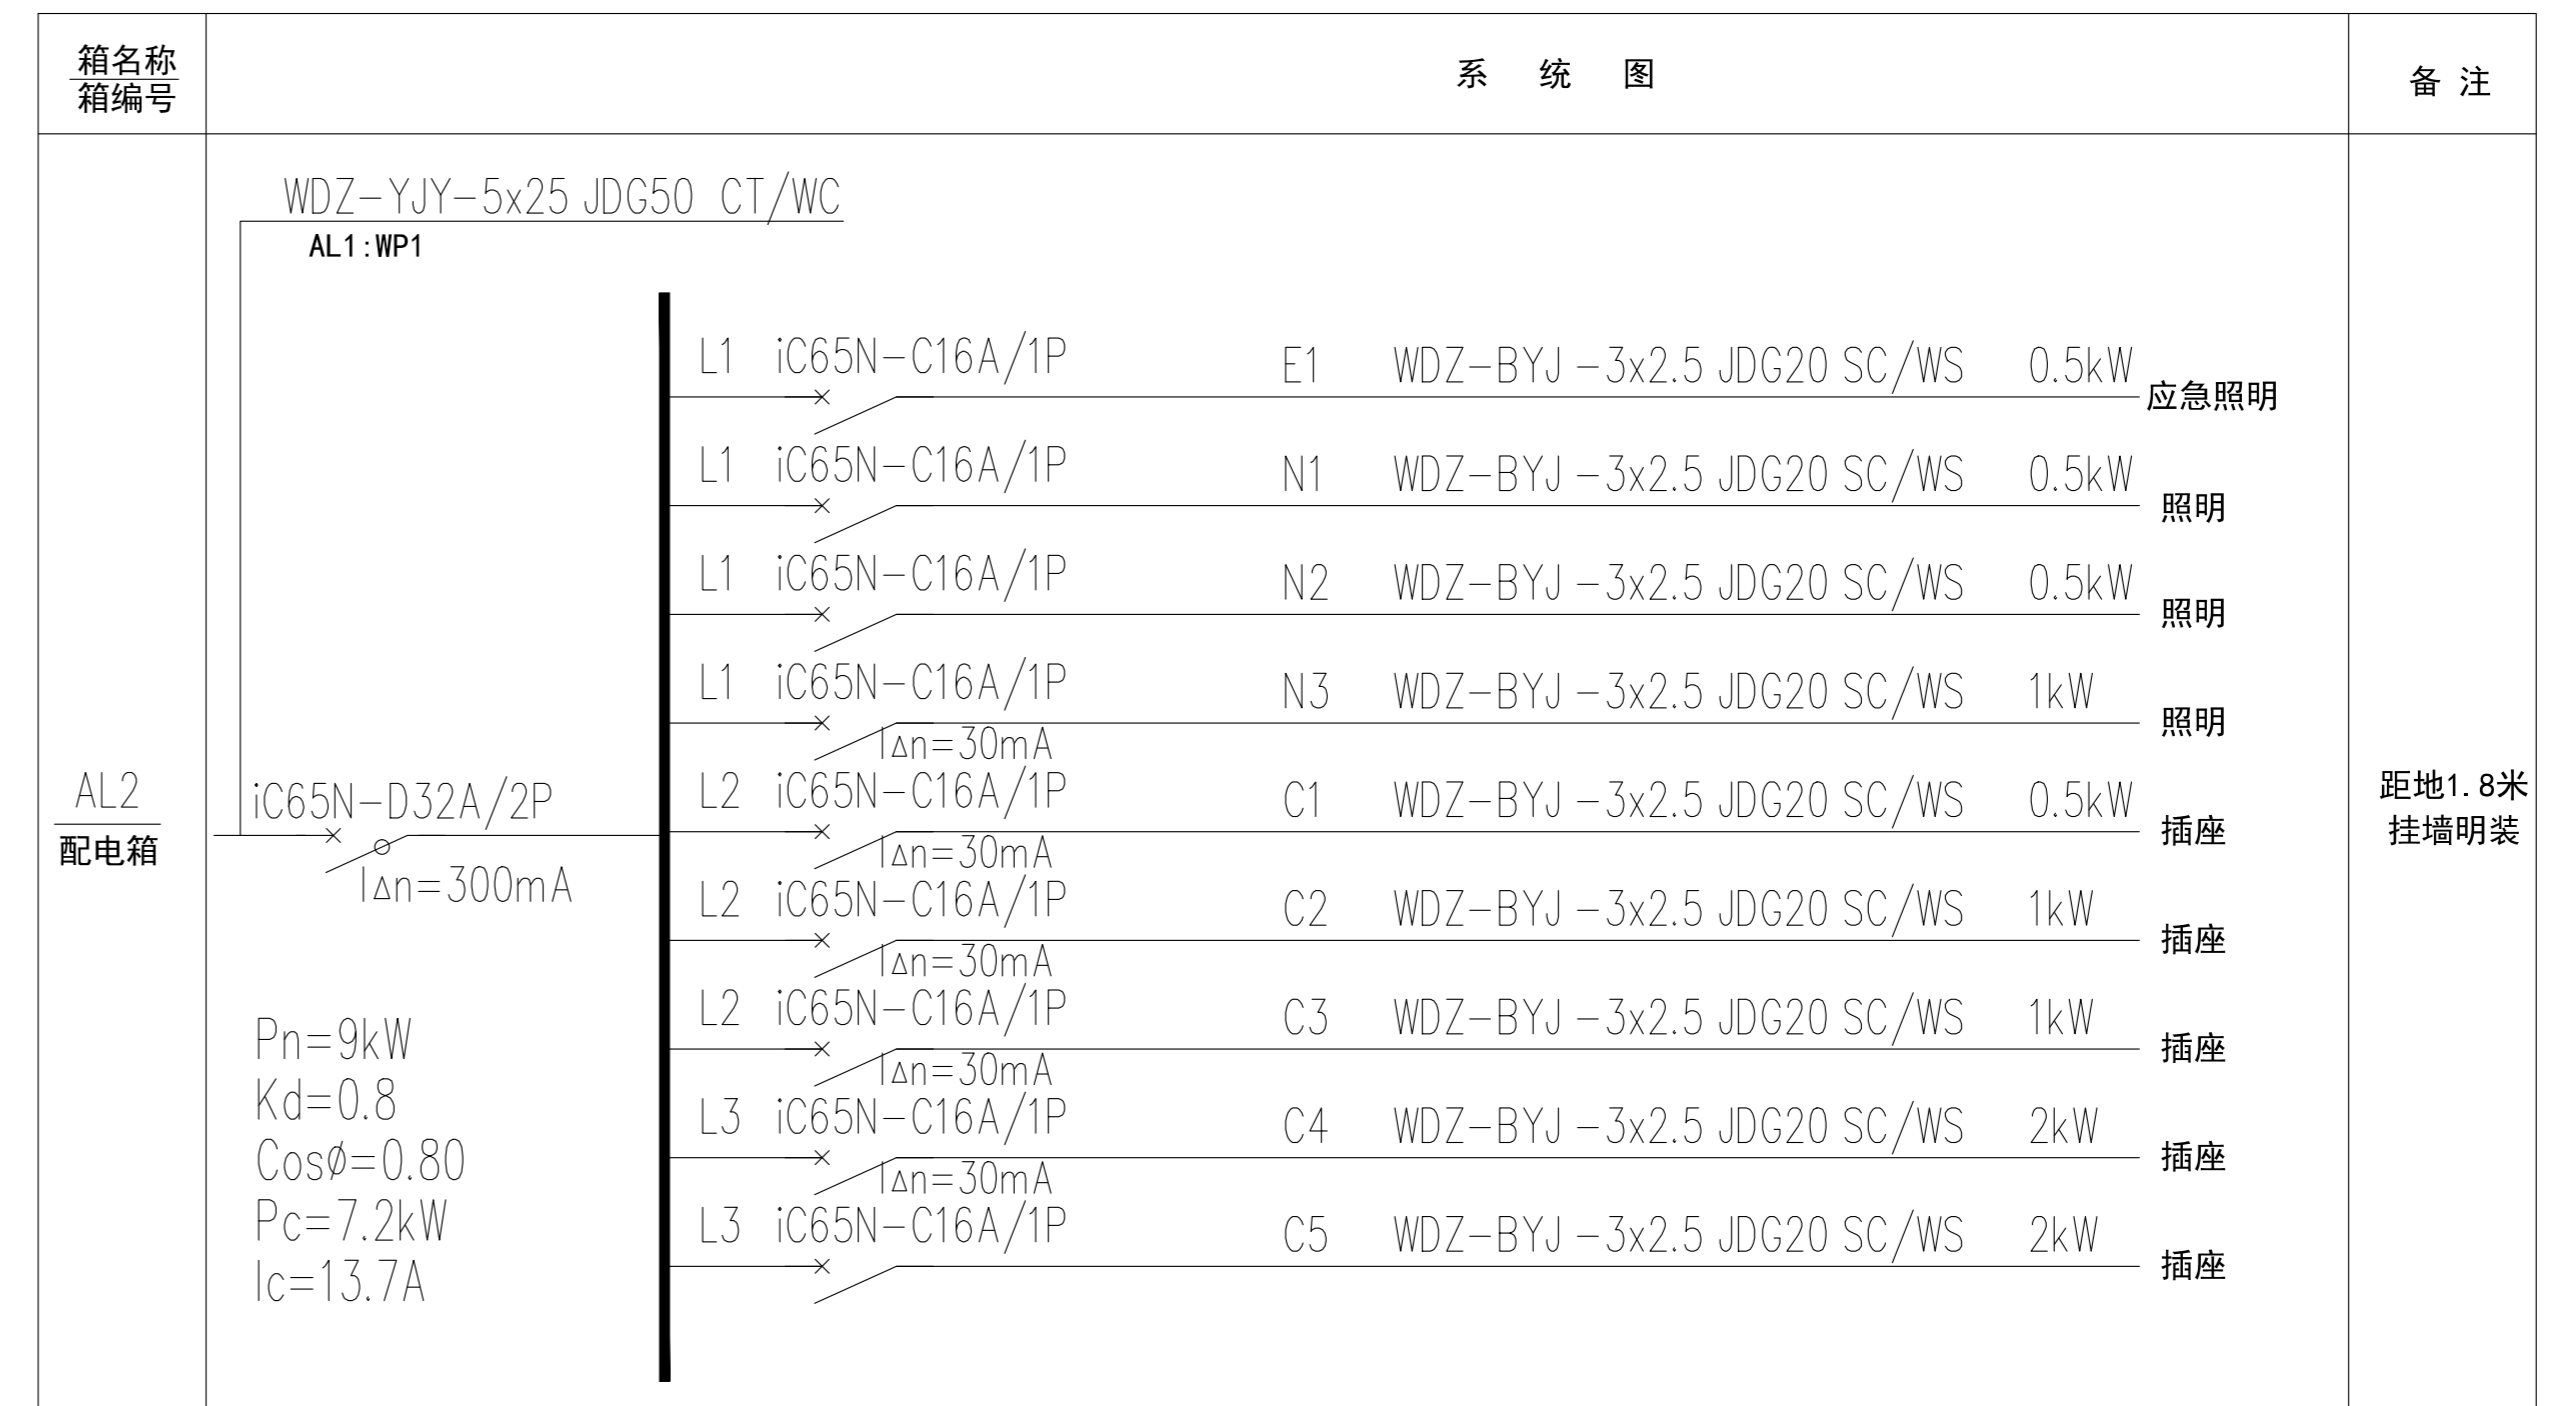

此图版权归本公司，所有尺寸以所注数字为准，并在工地核实无误，使用本图时应参阅其它有关图纸、说明和合同，如有矛盾即通知本公司，设计图若有变更应按下列最后修改记录或变更通知单为准。

This drawings & design are copyright and portion may be reproduced without the written permission of the architect. The written dimensions or grid line measurements to existing work to be checked on site. The drawings is to be read in conjunction with the specification & conditions of contract, and with general architectural plans, structural plans and all immediately of any discrepancy found the drawings not showing the last revisions above are to be cancelled.


工程名称
PROJECT NAME

图纸名称
DRAWING TITLE

异能无人机学园 配电系统图

次数 NO	修改日期	REVISIONS
△		
△		
△		
△		

设计负责人 PROJECT DIRECTOR	业 主 (甲方) CLIENT	制 图 DRAWN BY	图 号 DRAWING NO
设计 DESIGNED BY			P-18
审 核 APPROVED BY	比 例 SCALE	日 期 DATE	

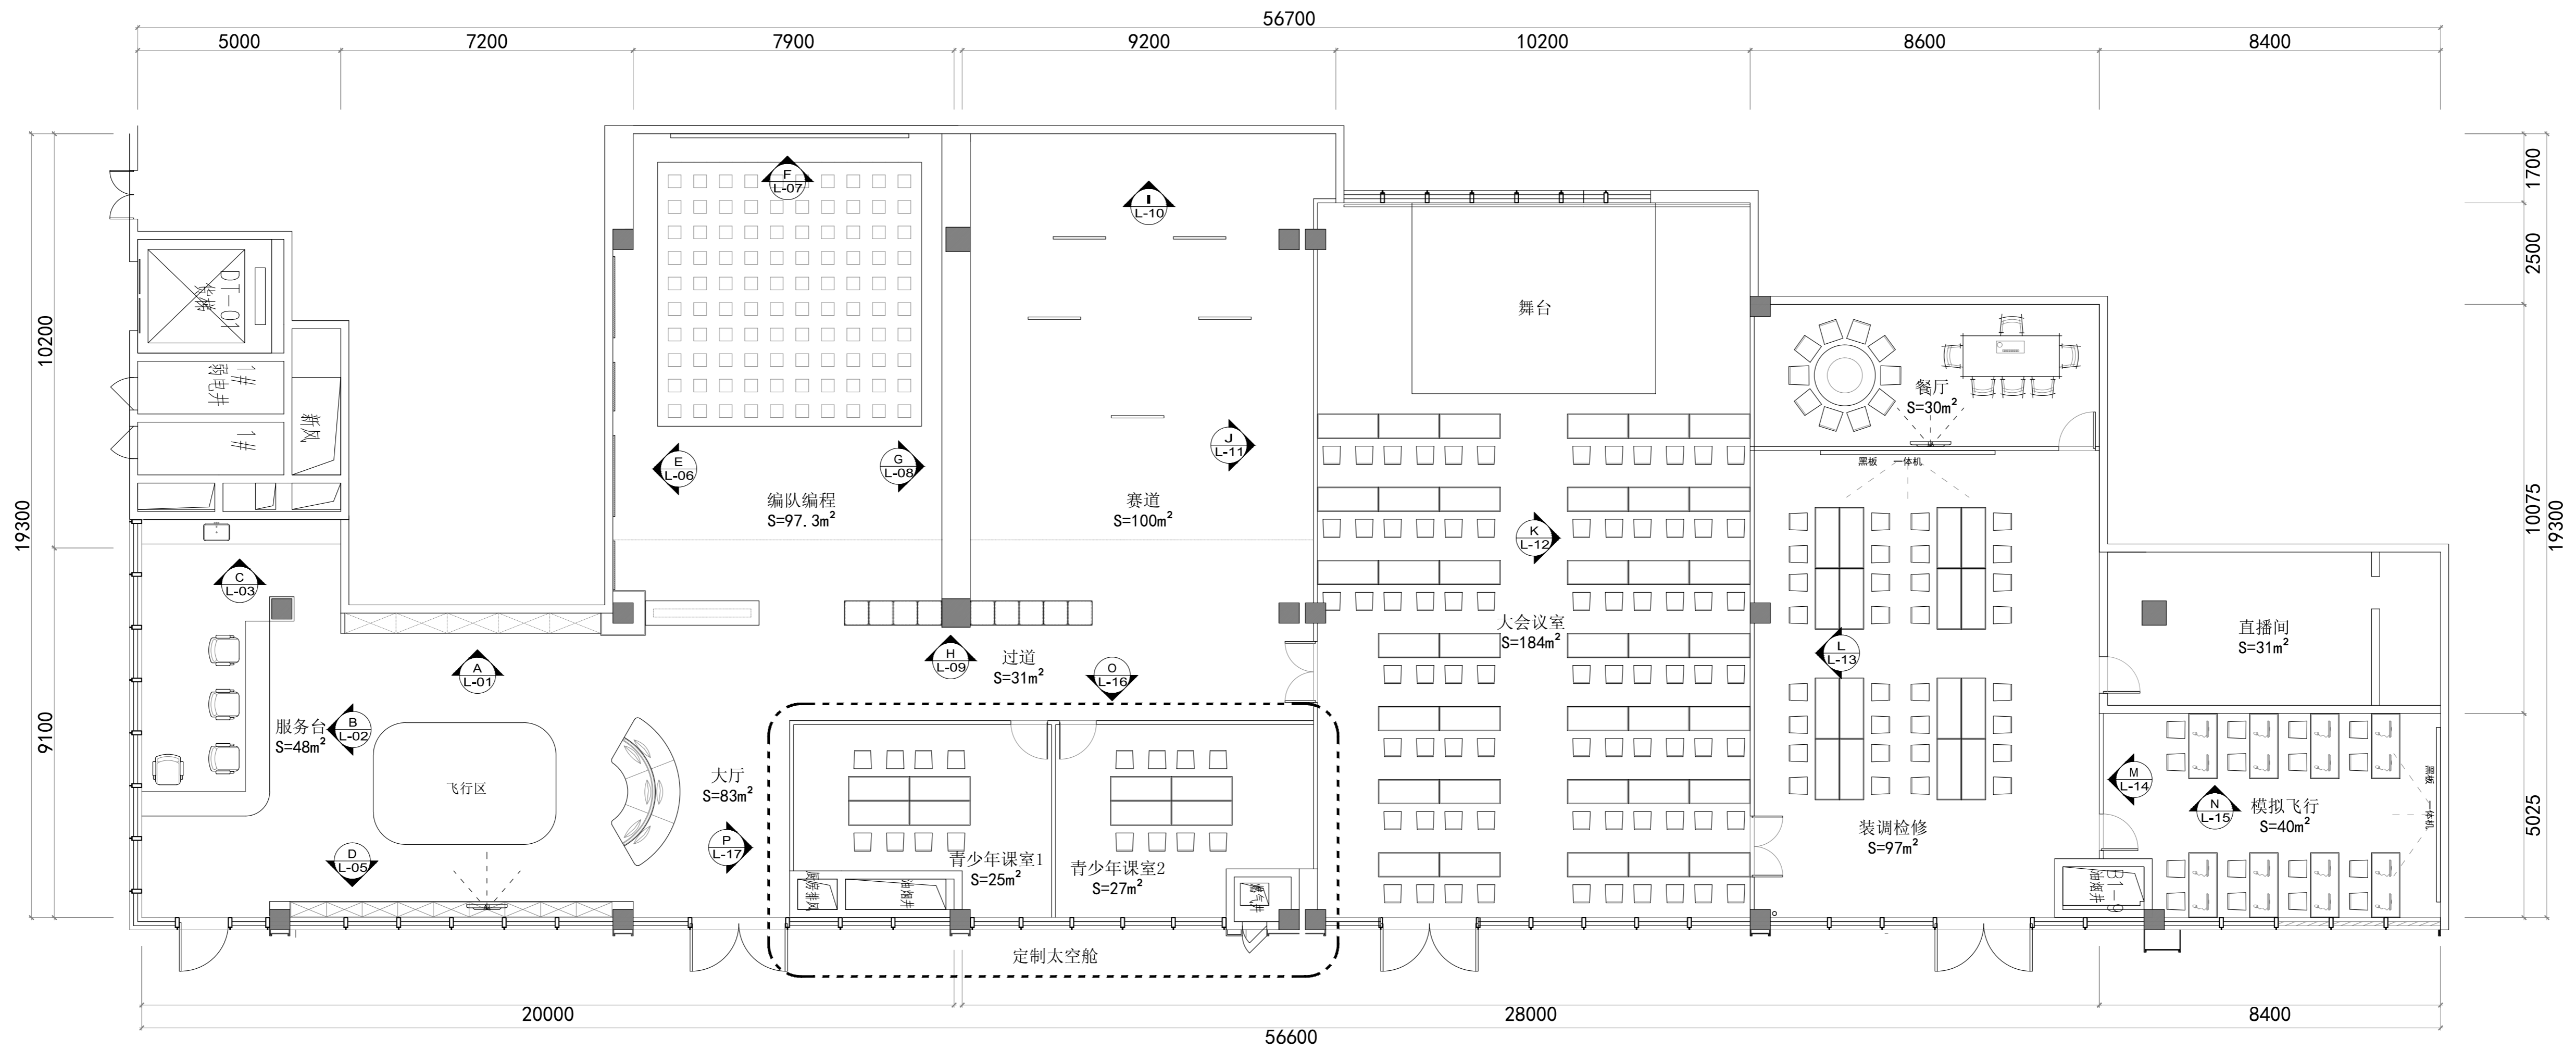

此图版权归本公司，所有尺寸以所注数字为准，并在工地核实无误，使用本图时应参阅其它有关图纸，说明和合同，如有矛盾即通知本公司，设计图若有变更应按下列最后修改记录或变更通知单为准。
 This drawings & design are copyright and portion may be reproduced without the written permission of the architect. All written dimensions or grid line measurements to existing work to be checked on site. This drawings is to be read in conjunction with the specification & conditions of contract, and with general architectural plans, structural plans and all immediately of any discrepancy found the drawings not showing the last revisions above are to be cancelled.

工程名称
PROJECT NAME

异能无人机学园

平面布置图

次数	NO	修改日期	REVISIONS
△			
△			
△			
△			

设计负责人
PROJECT DIRECTOR

设计
DESIGNED BY

审核
APPROVED BY

业主(甲方)
CLIENT




制图
DRAWN BY

比例
SCALE


图号
DRAWING NO

日期
DATE

P-13

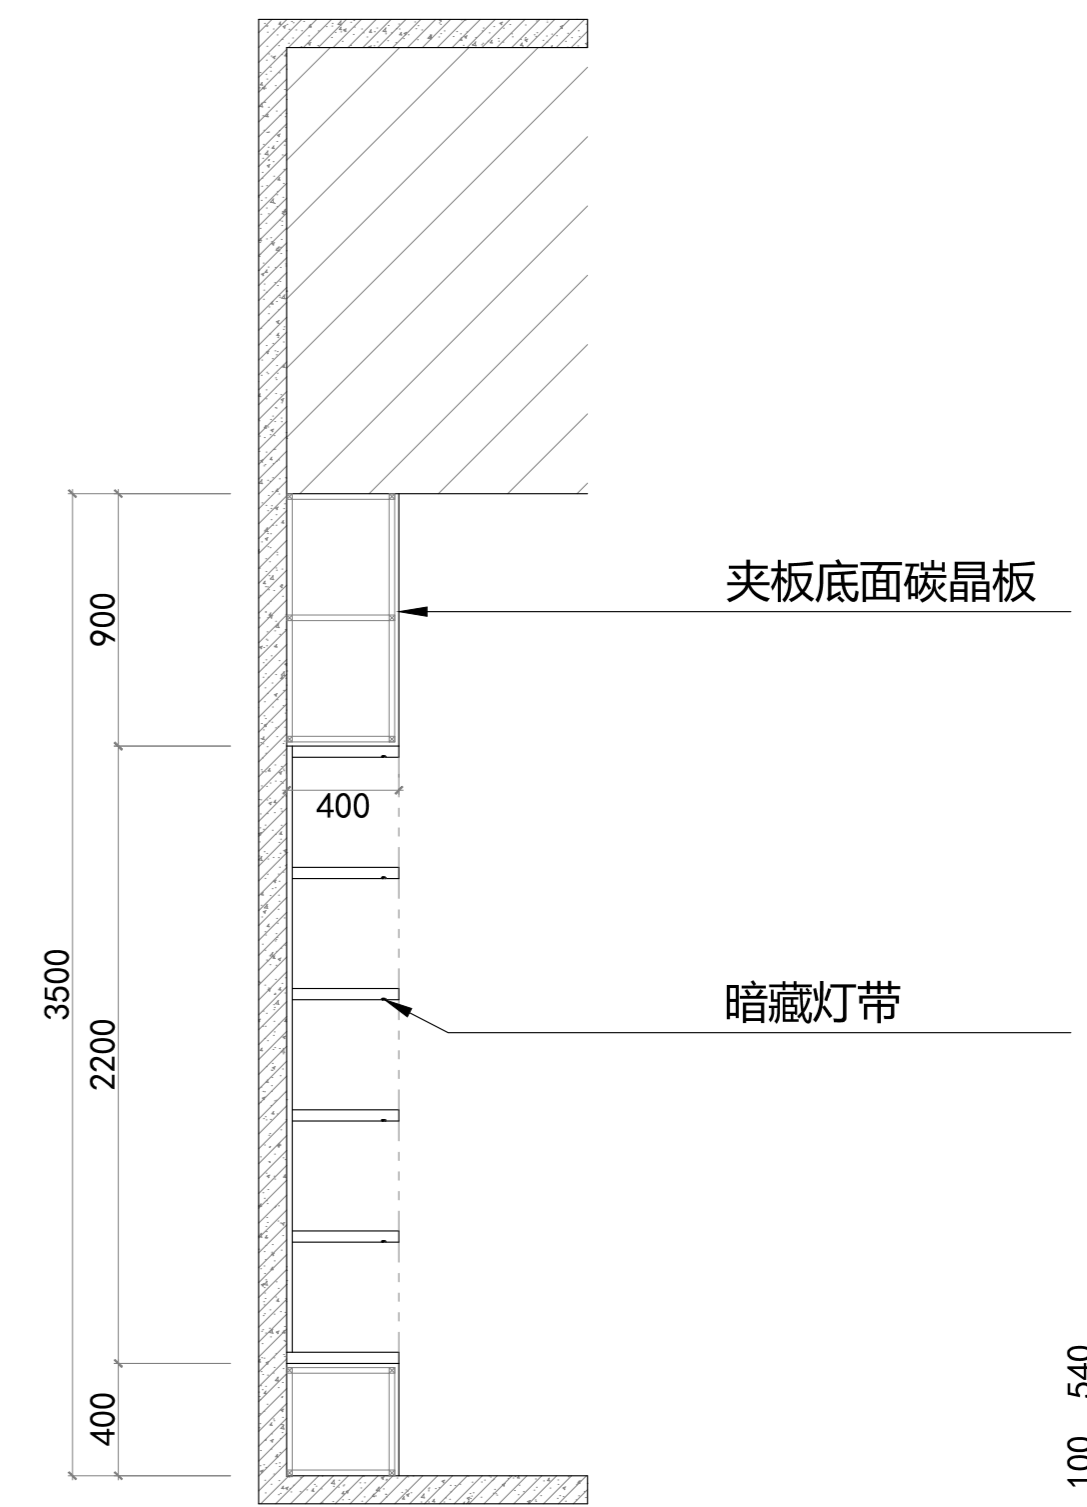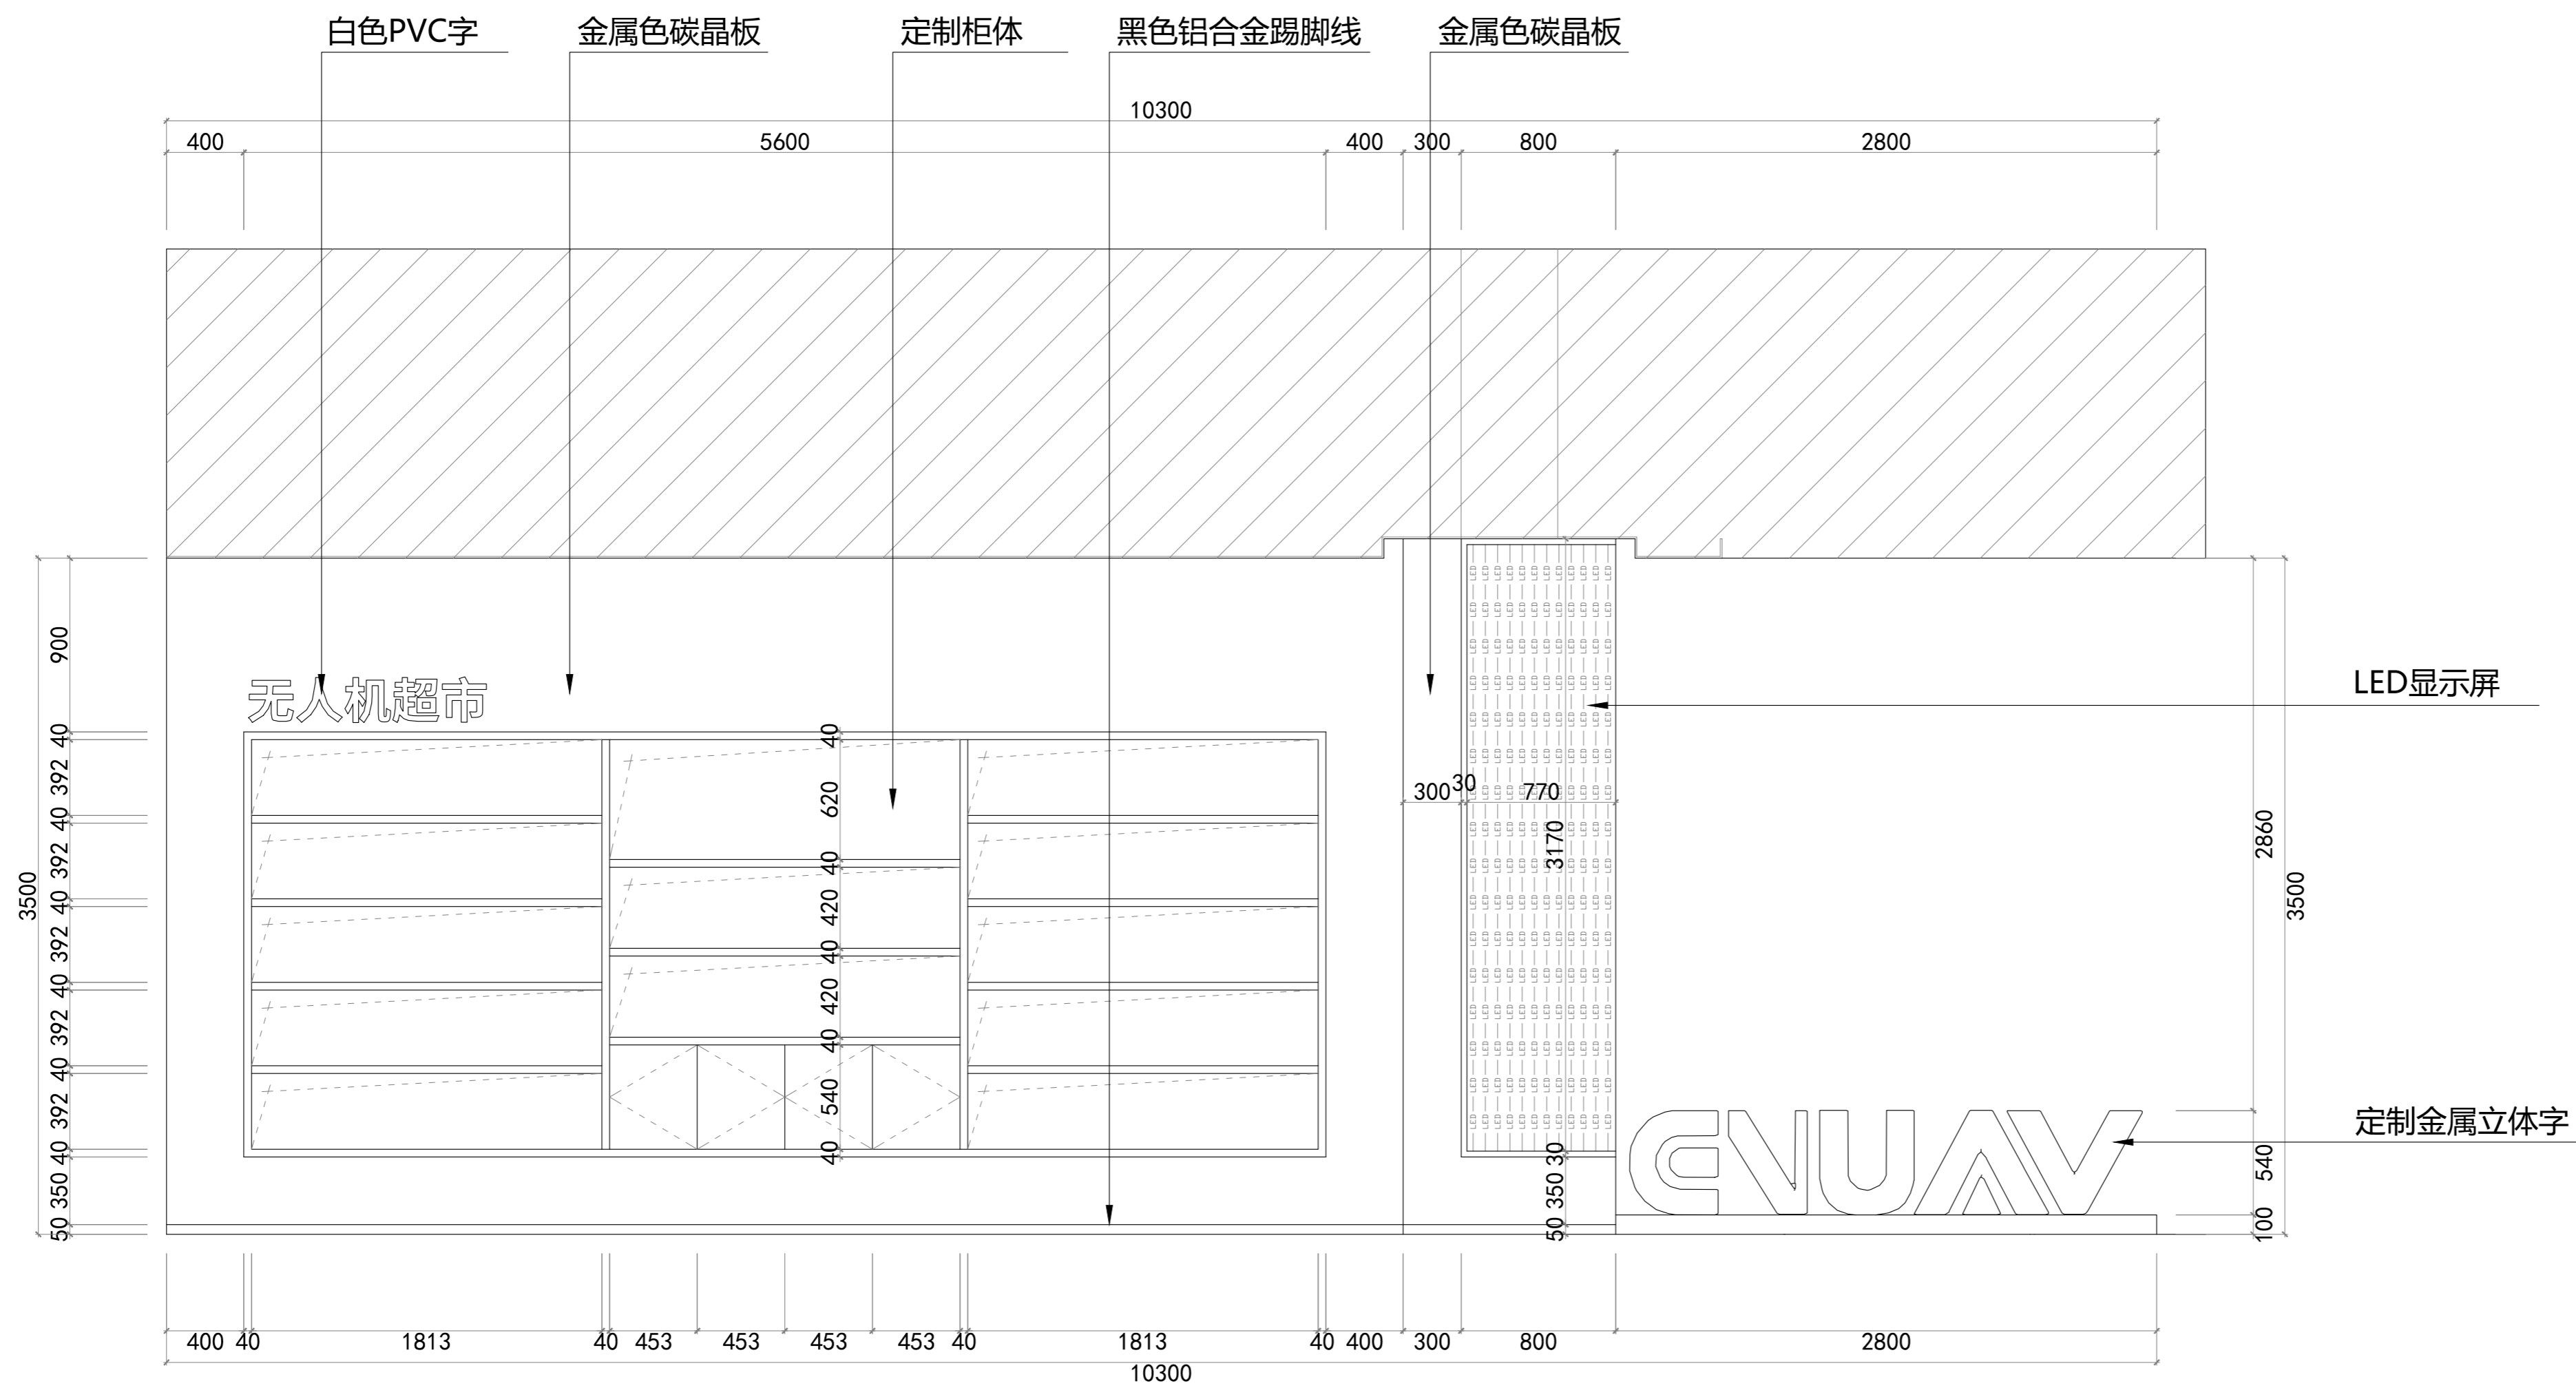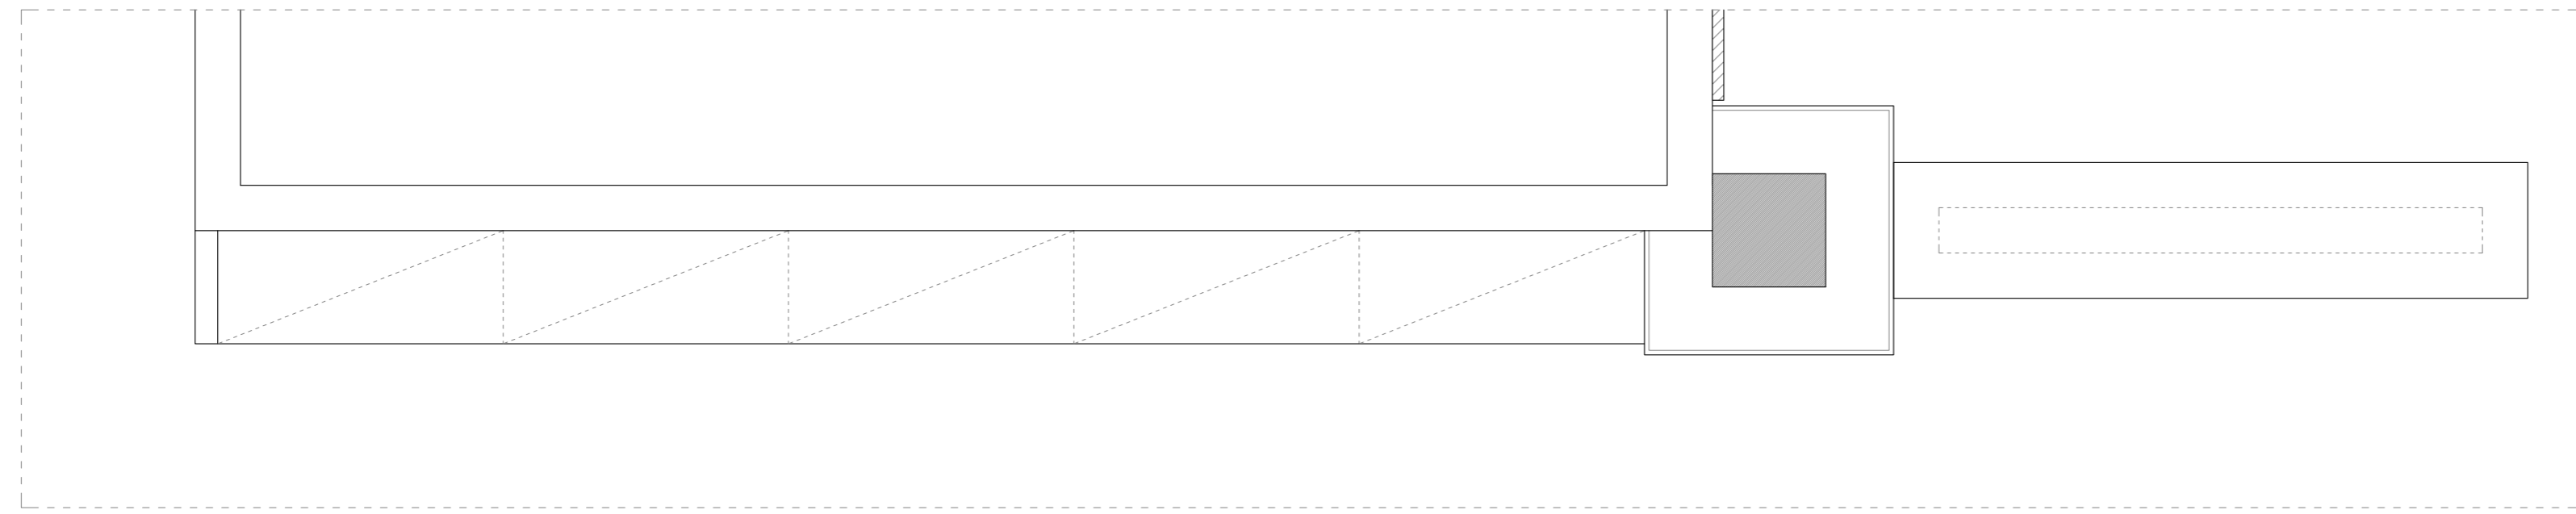

剖面尺寸图

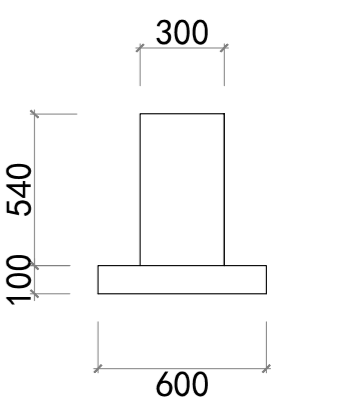

金属字剖面尺寸图

此图版权归本公司，所有尺寸以所注数字为准，并在工地核实无误，使用本图时应参阅其它有关图纸，说明和合同，如有矛盾即通知本公司，设计图若有变更应按下栏最后修改记录或变更通知单为准。
This drawings & design are copyright and portion may be reproduced without the written permission of the architect. All written dimensions or grid line measurements to existing work to be checked on site. This drawings is to be read in conjunction with the specification & conditions of contract, and with general architectural plans, structural plans and all immediately of any discrepancy found the drawings not showing the last revisions above are to be cancelled.

工程名称
PROJECT NAME

图纸名称
DRAWING TITLE

异能无人机学园
A立面图

次数	NO	修改日期	REVISIONS
△			
△			
△			
△			

设计负责人
PROJECT DIRECTOR

设计
DESIGNED BY

审核
APPROVED BY

业主(甲方)
CLIENT






制图
DRAWN BY

比例
SCALE

图号
DRAWING NO

日期
DATE

L-01

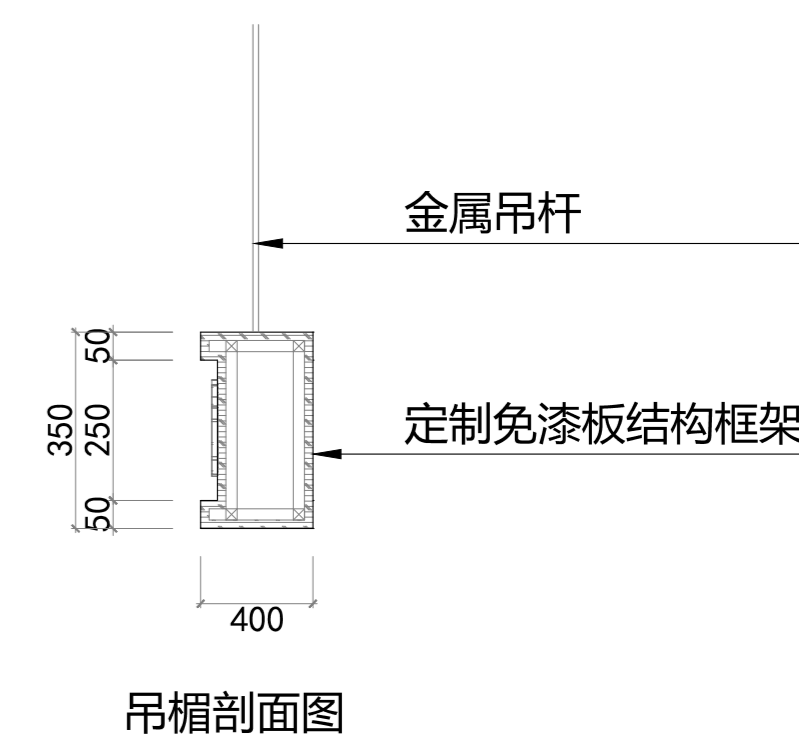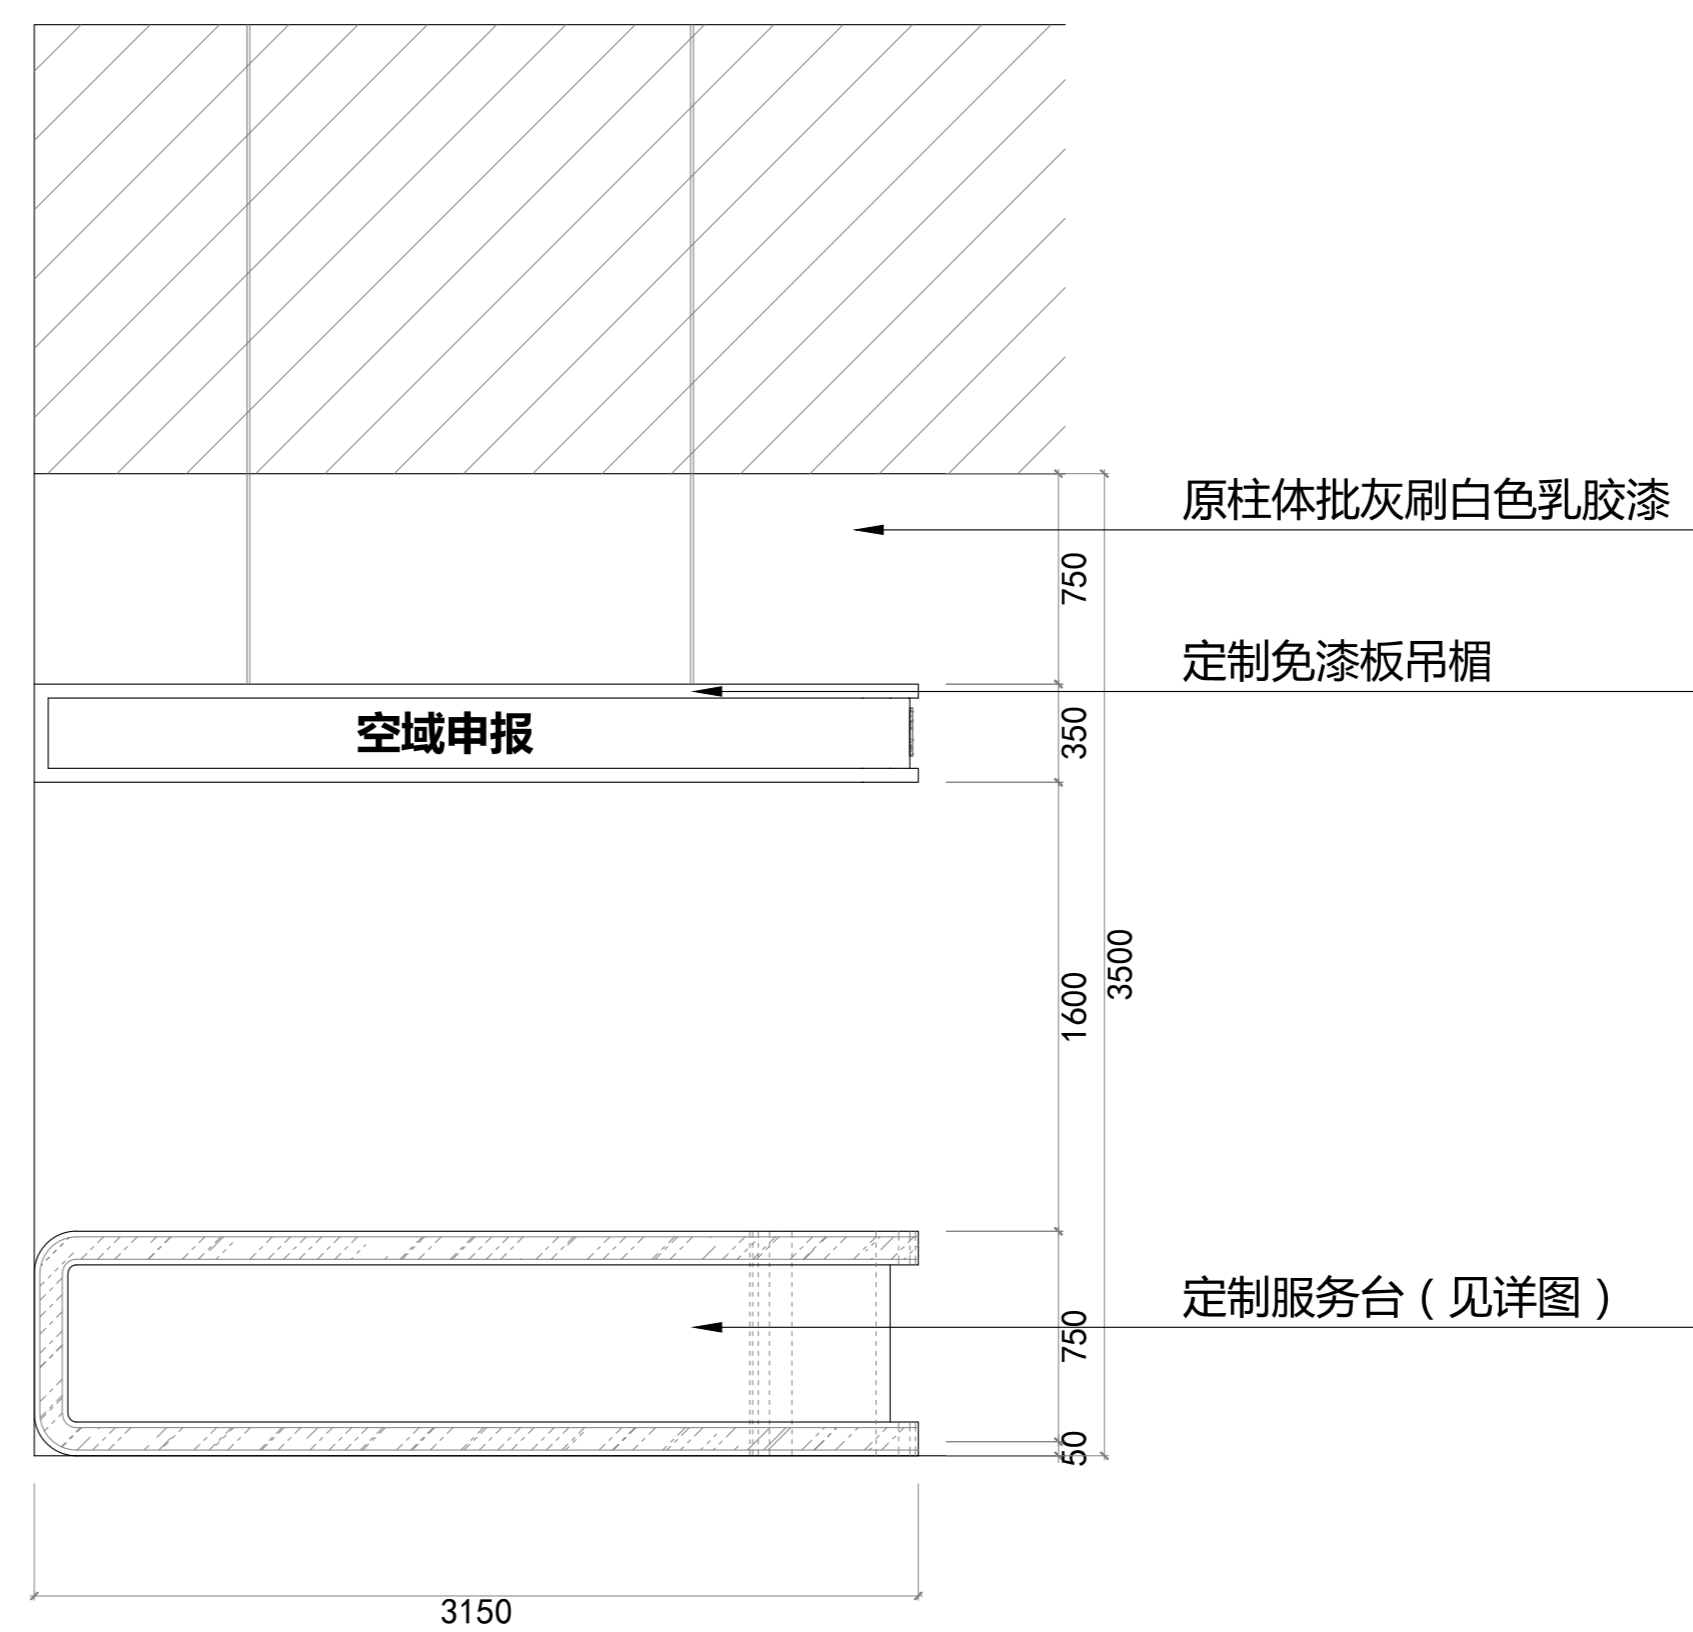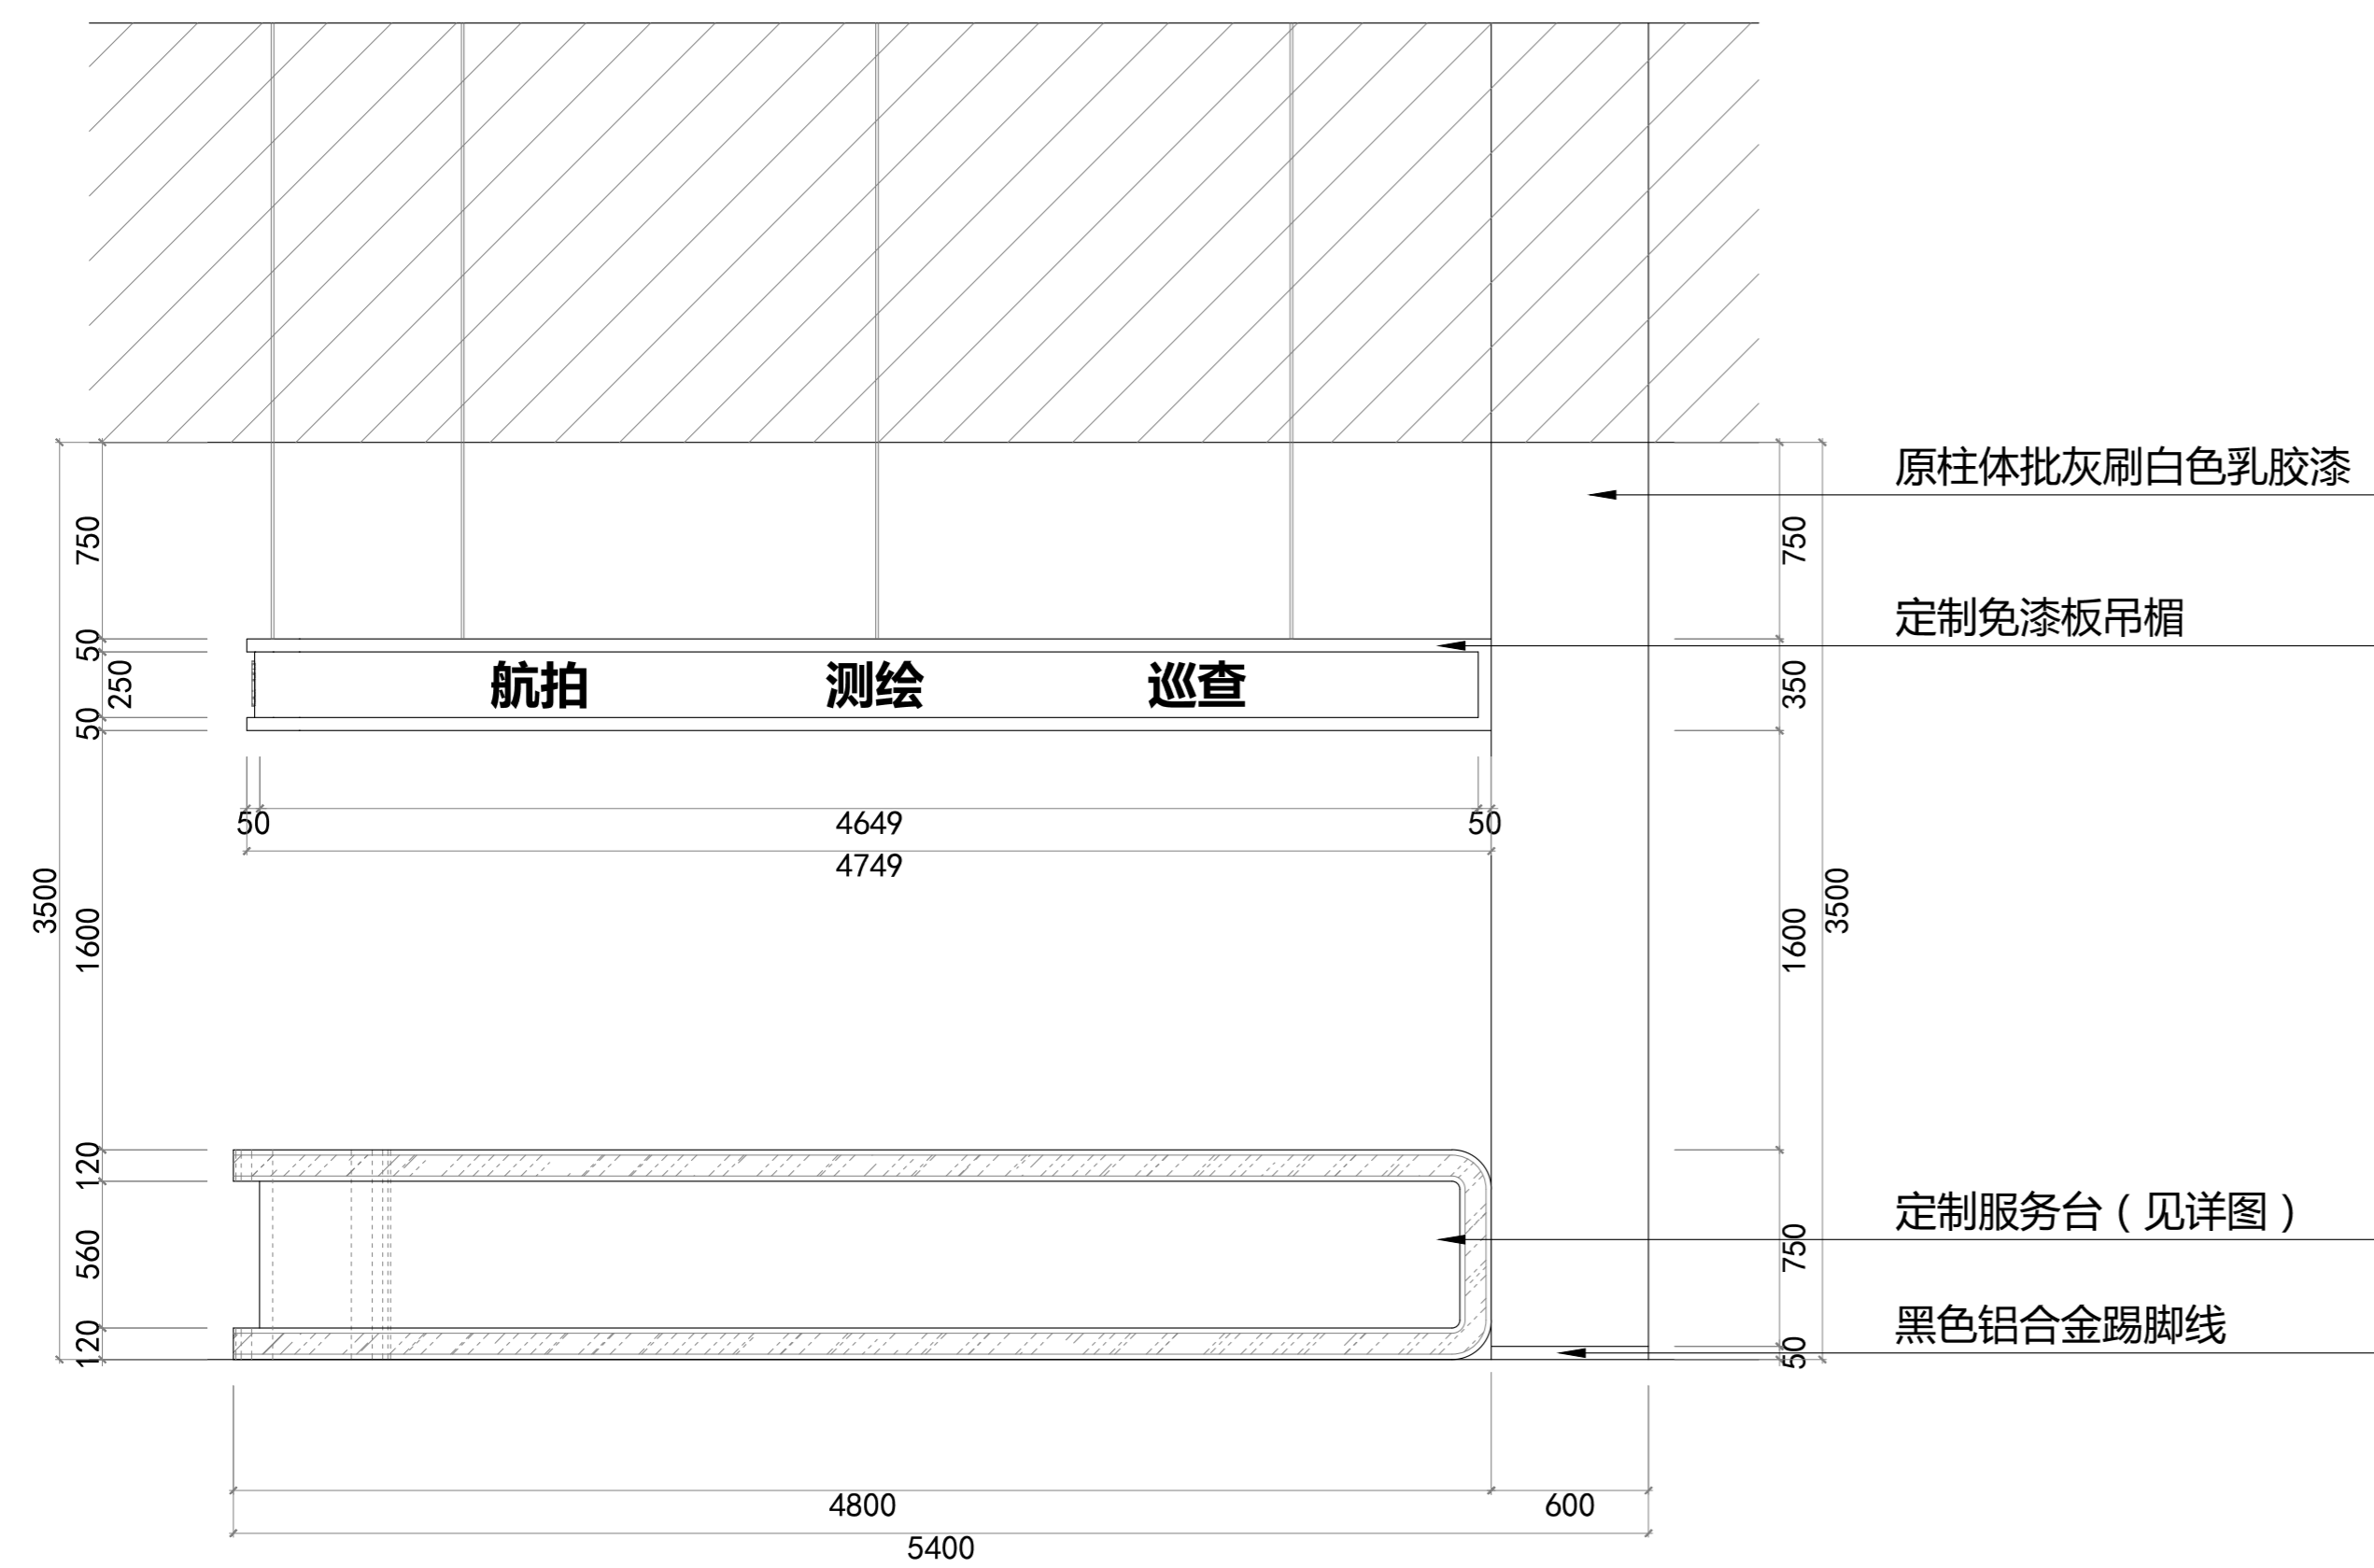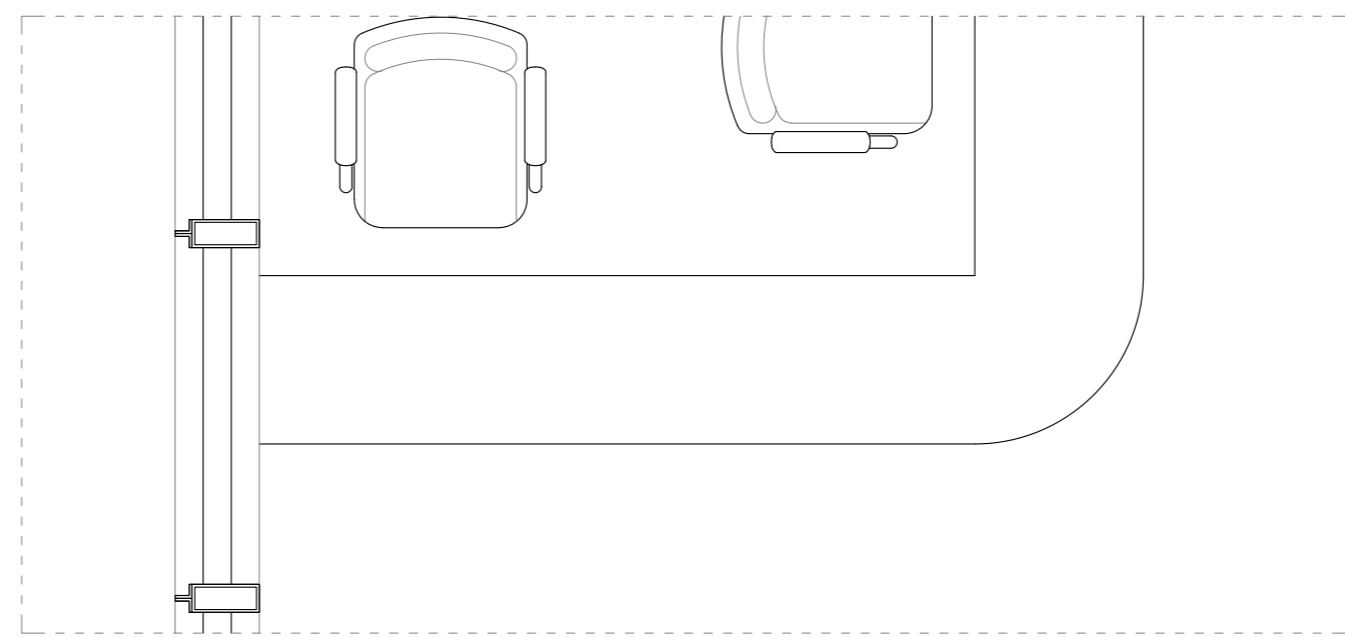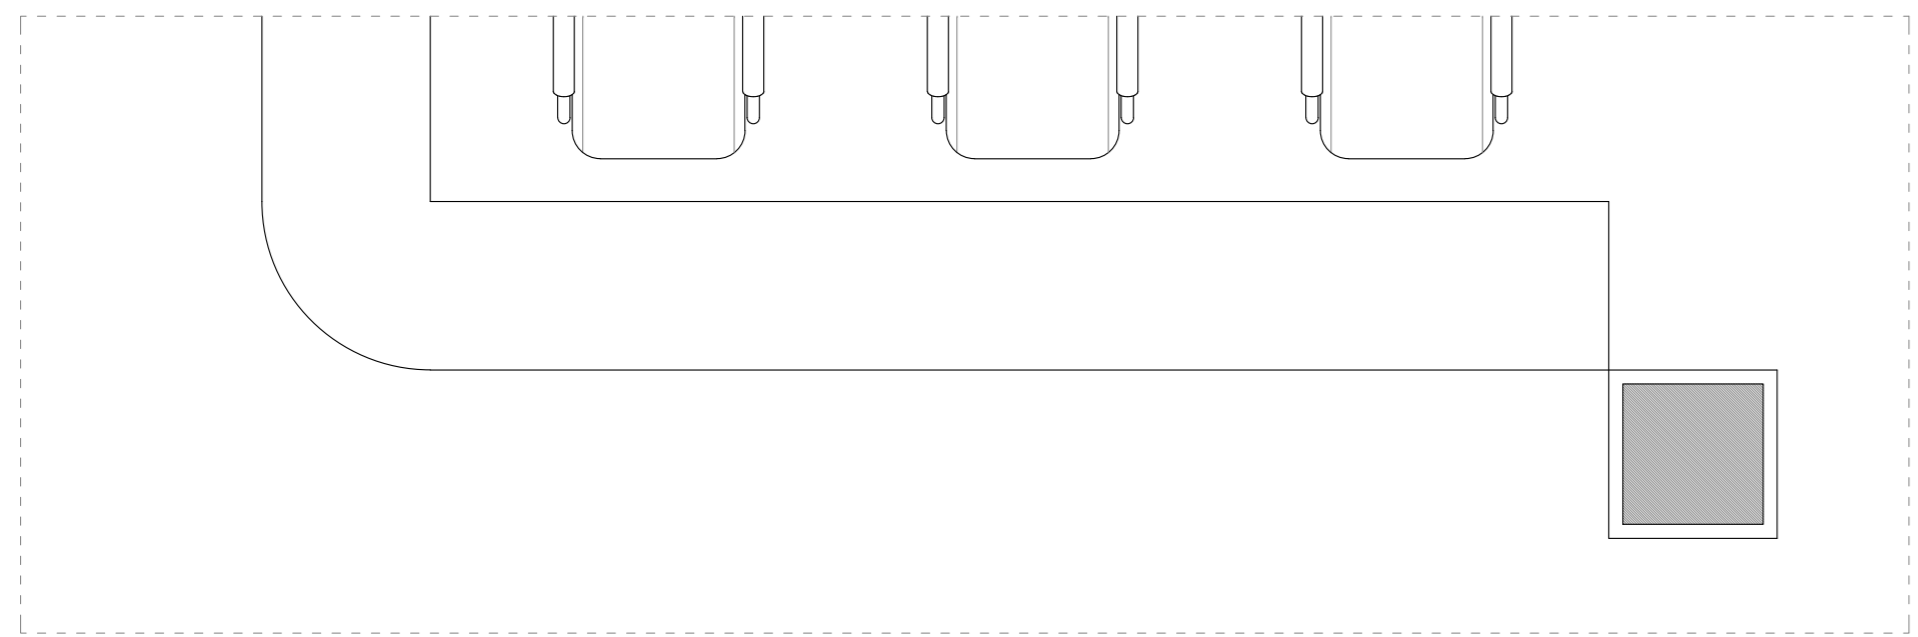

此图版权归本公司，所有尺寸以所注数字为准，并在工地核实无误，使用本图时应参阅其它有关图纸，说明和合同，如有矛盾即通知本公司，设计图若有变更应按下列最后修改记录或变更通知单为准。

This drawings & design are copyright and portion may be reproduced without the written permission of the architect. All written dimensions or grid line measurements to existing work to be checked on site. This drawings is to be read in conjunction with the specification & conditions of contract, and with general architectural plans, structural plans and all immediately of any discrepancy found the drawings not showing the last revisions above are to be cancelled.

工程名称
PROJECT NAME

图纸名称
DRAWING TITLE

异能无人机学园

B立面图

次数	NO	修改日期	REVISIONS
△			
△			
△			
△			

设计负责人
PROJECT DIRECTOR

设计
DESIGNED BY

审核
APPROVED BY

业主(甲方)
CLIENT






制图
DRAWN BY

比例
SCALE

图号
DRAWING NO

日期
DATE

L-02

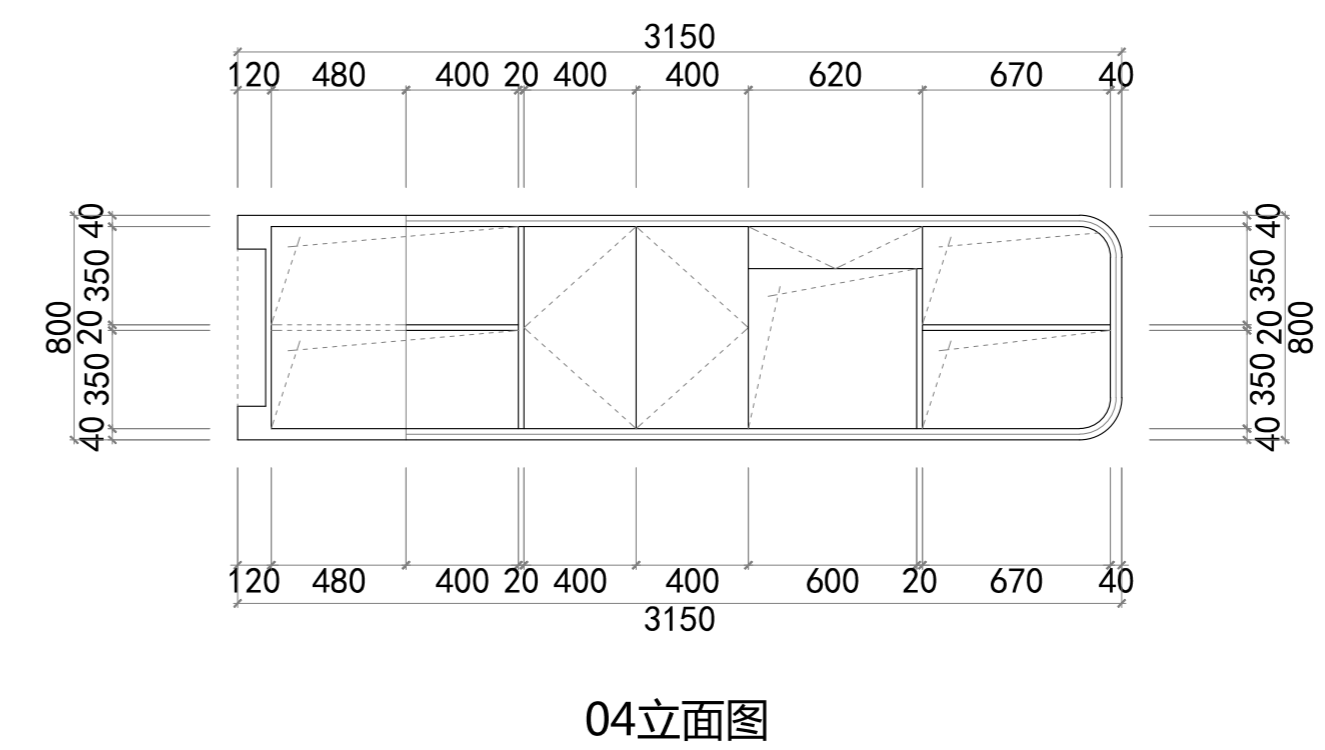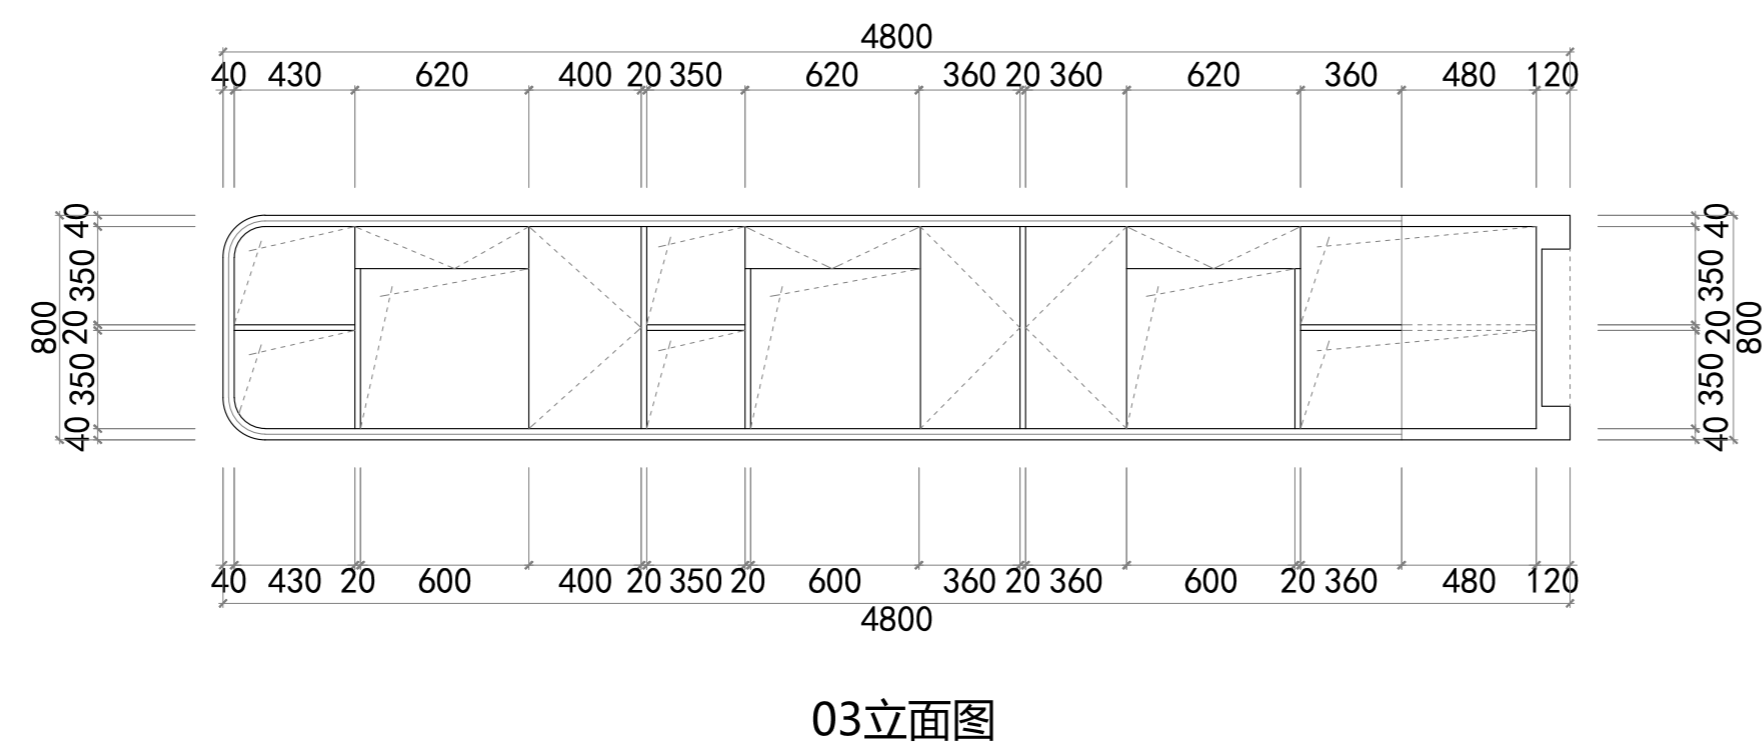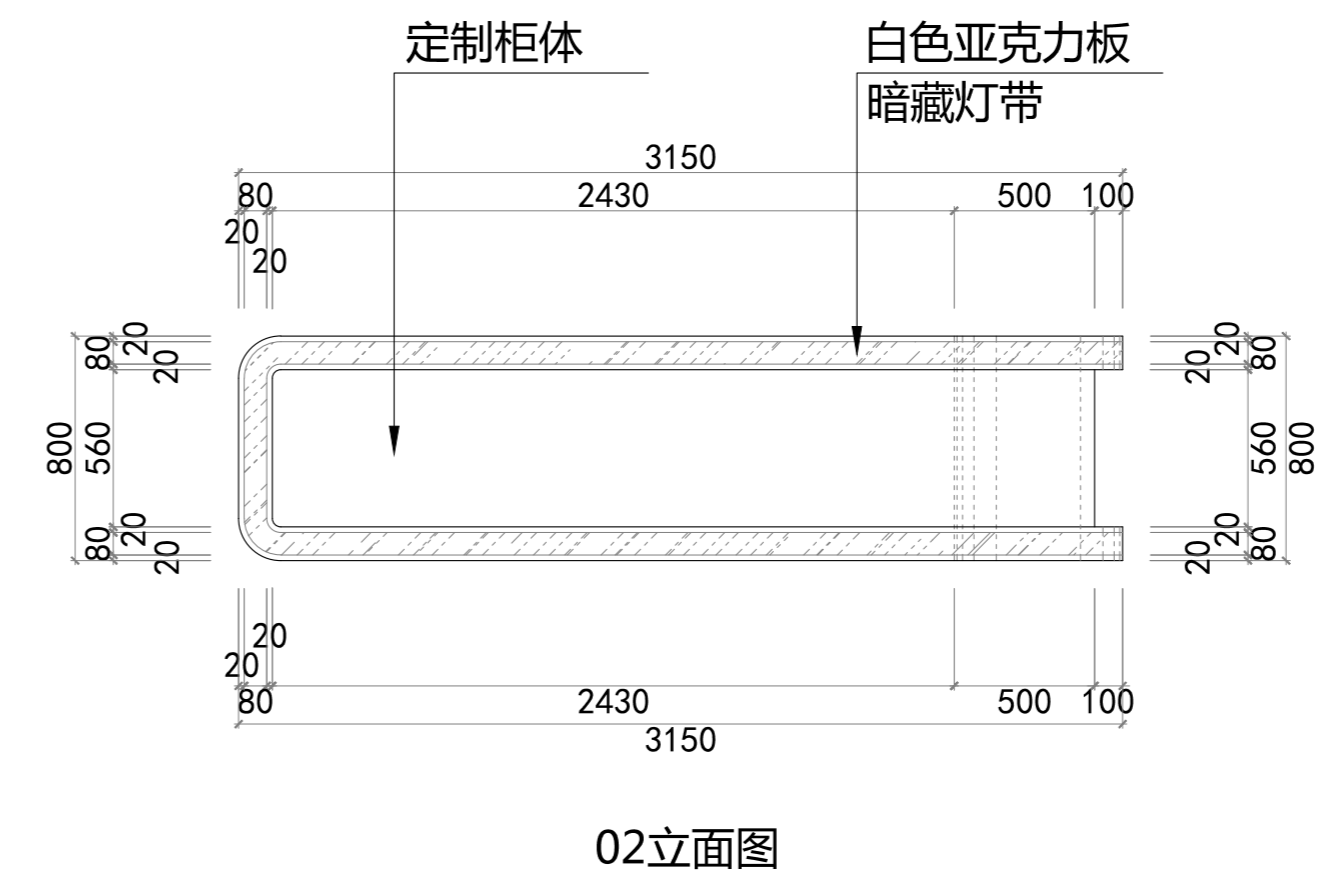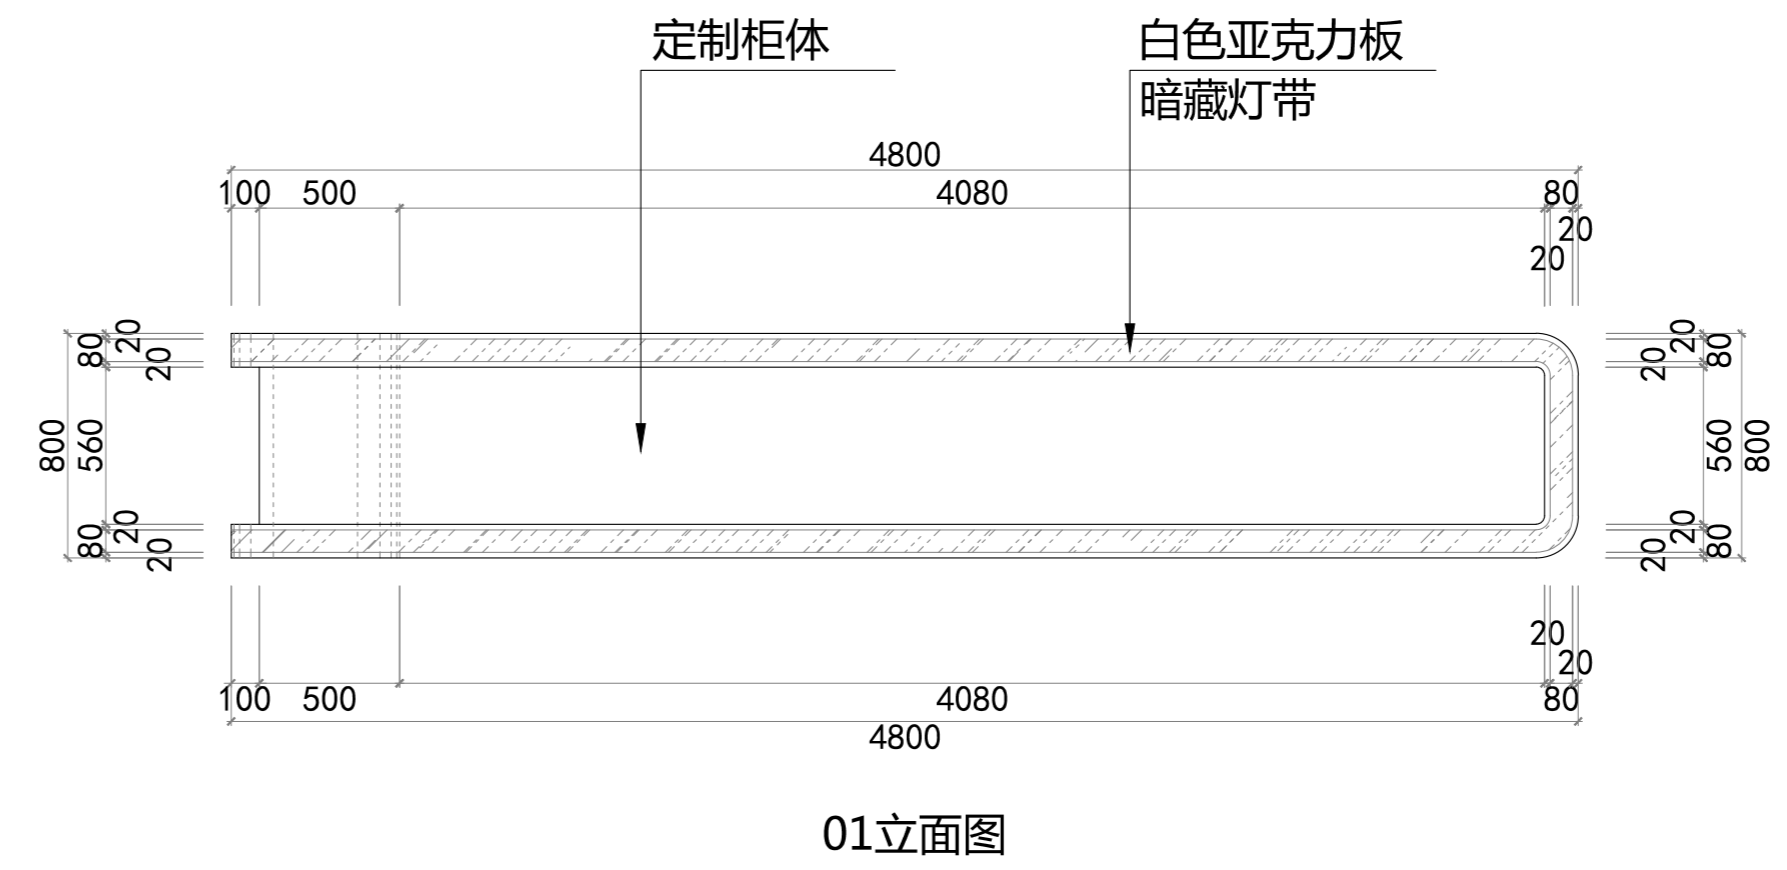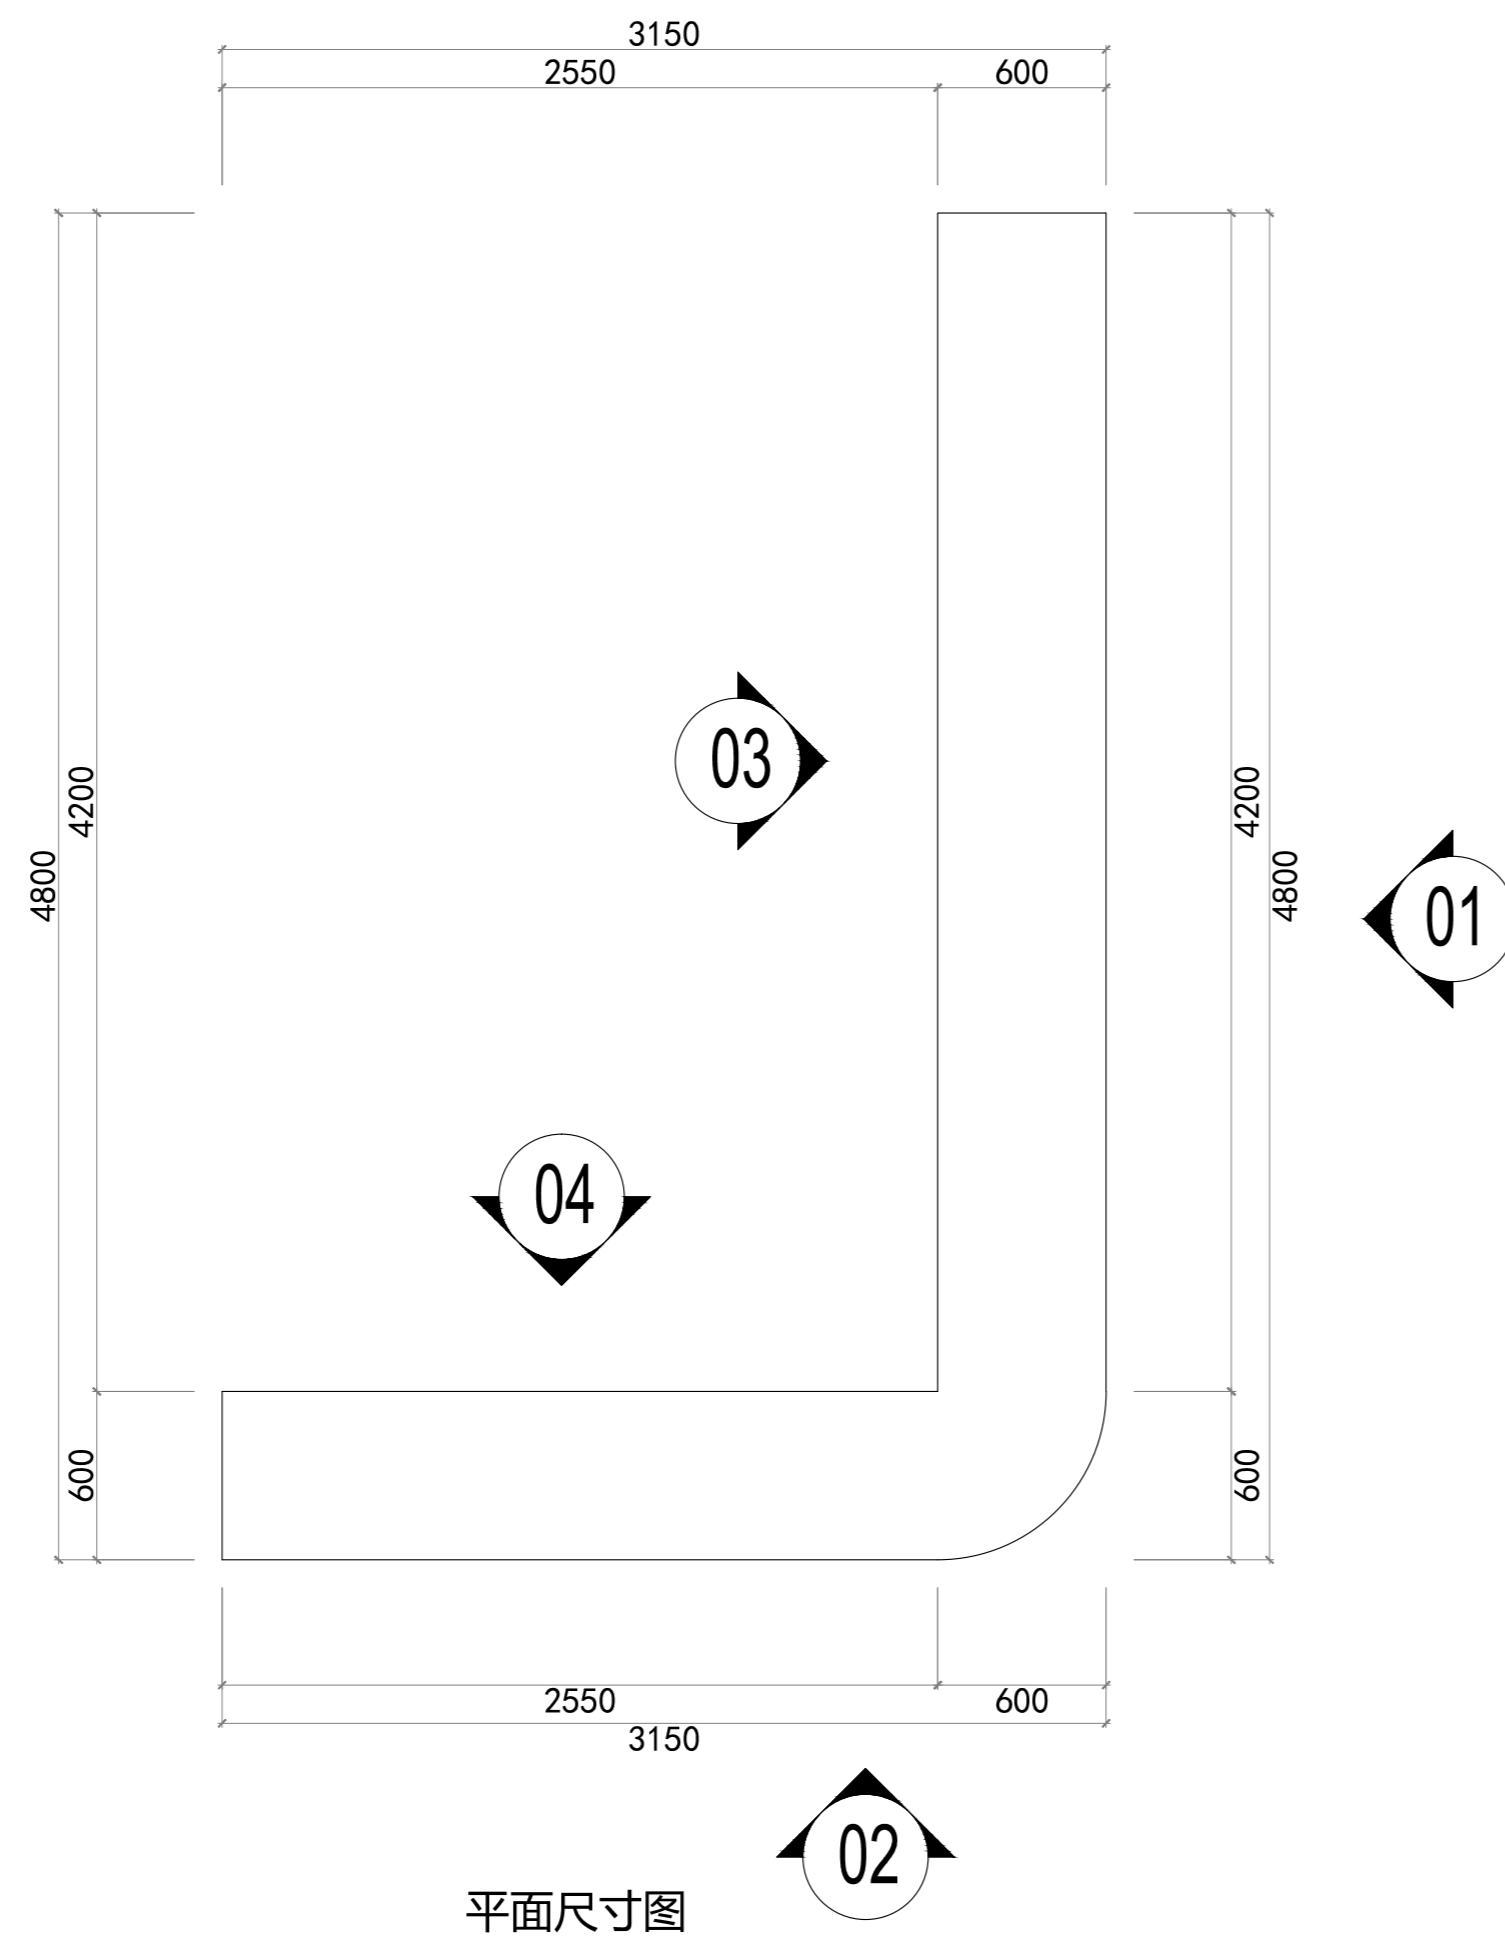

此图版权归本公司，所有尺寸以所注数字为准，并在工地核实无误，使用本图时应参阅其它有关图纸、说明和合同，如有矛盾即通知本公司，设计图若有变更应按下栏最后修改记录或变更通知单为准。
This drawings & design are copyright and portion may be reproduced without the written permission of the architect. All written dimensions or grid line measurements to existing work to be checked on site. This drawings is to be read in conjunction with the specification & conditions of contract, and with general architectural plans, structural plans and all immediately of any discrepancy found the drawings not showing the last revisions above are to be cancelled.




工程名称
PROJECT NAME
图纸名称
DRAWING TITLE

异能无人机学园
服务台详图


次数 NO	修改日期	REVISIONS
△		
△		
△		
△		

设计负责人 PROJECT DIRECTOR		业主(甲方) CLIENT	
设计 DESIGNED BY		制图 DRAWN BY	图号 DRAWING NO
审核 APPROVED BY		比例 SCALE	日期 DATE

			L-03

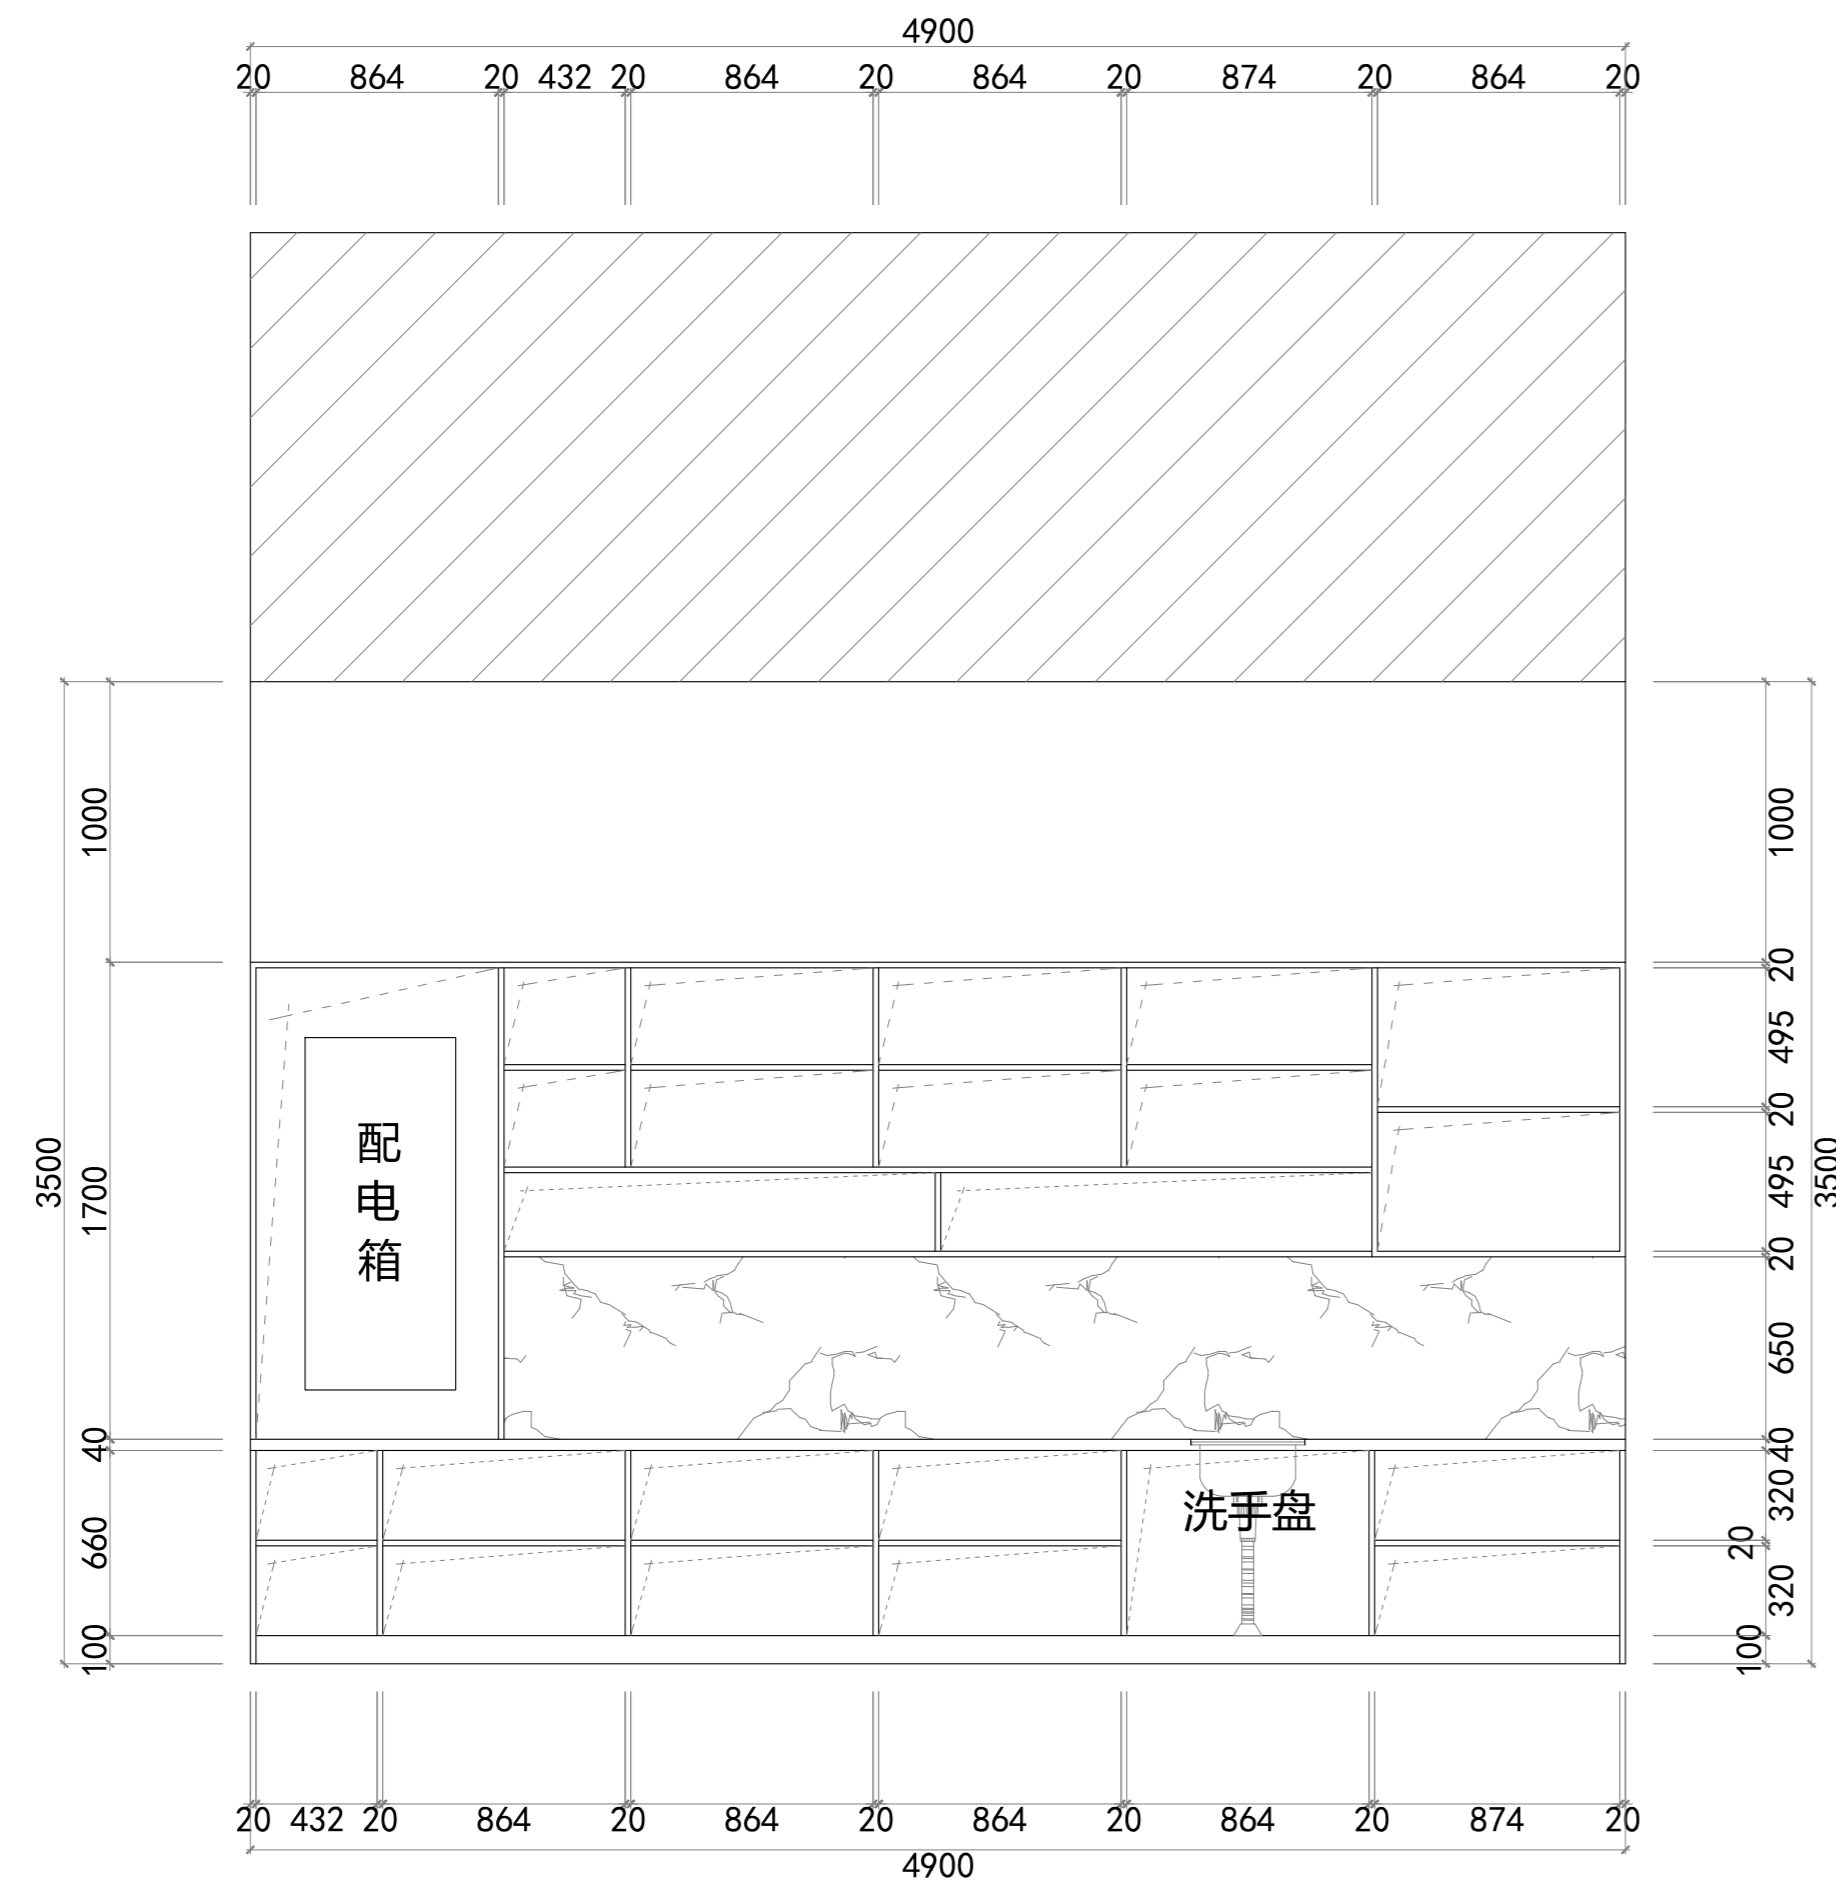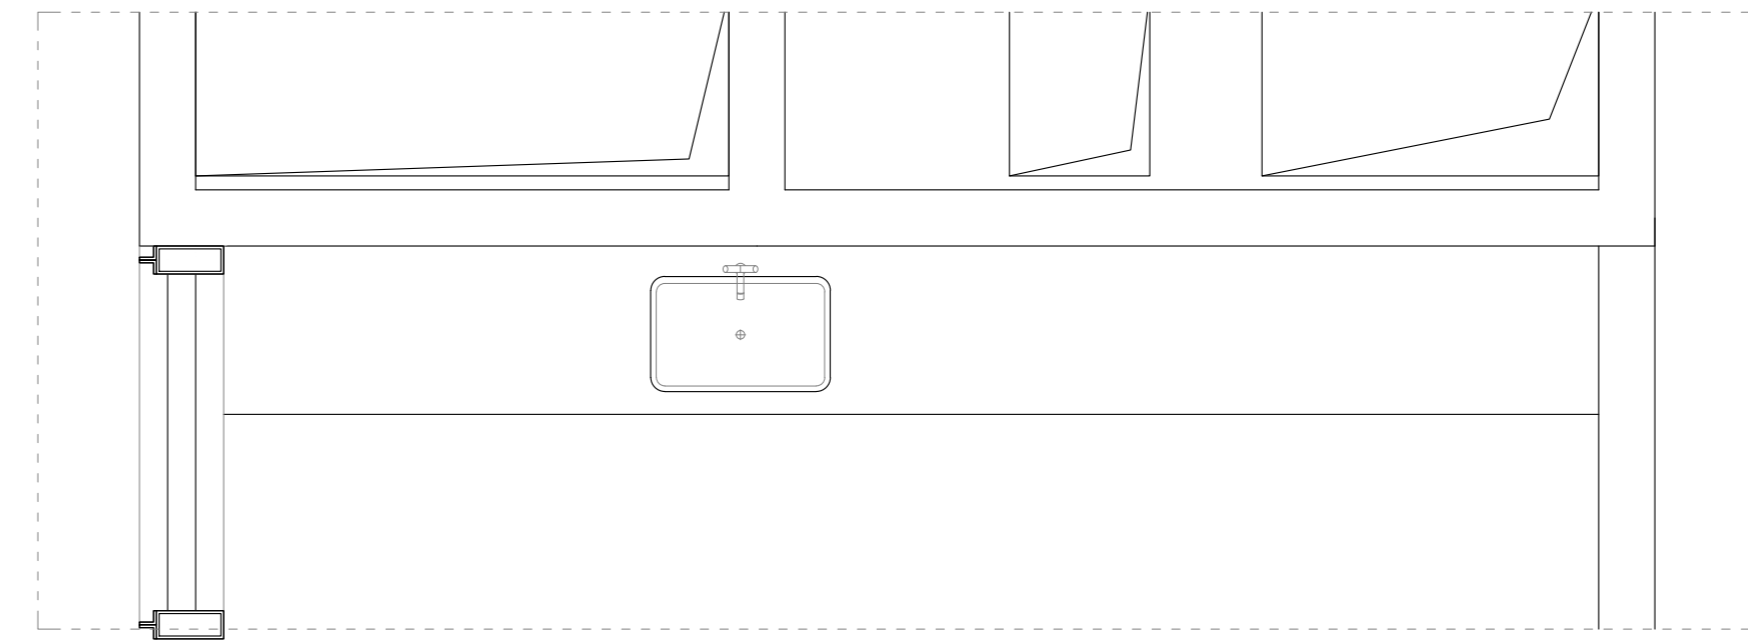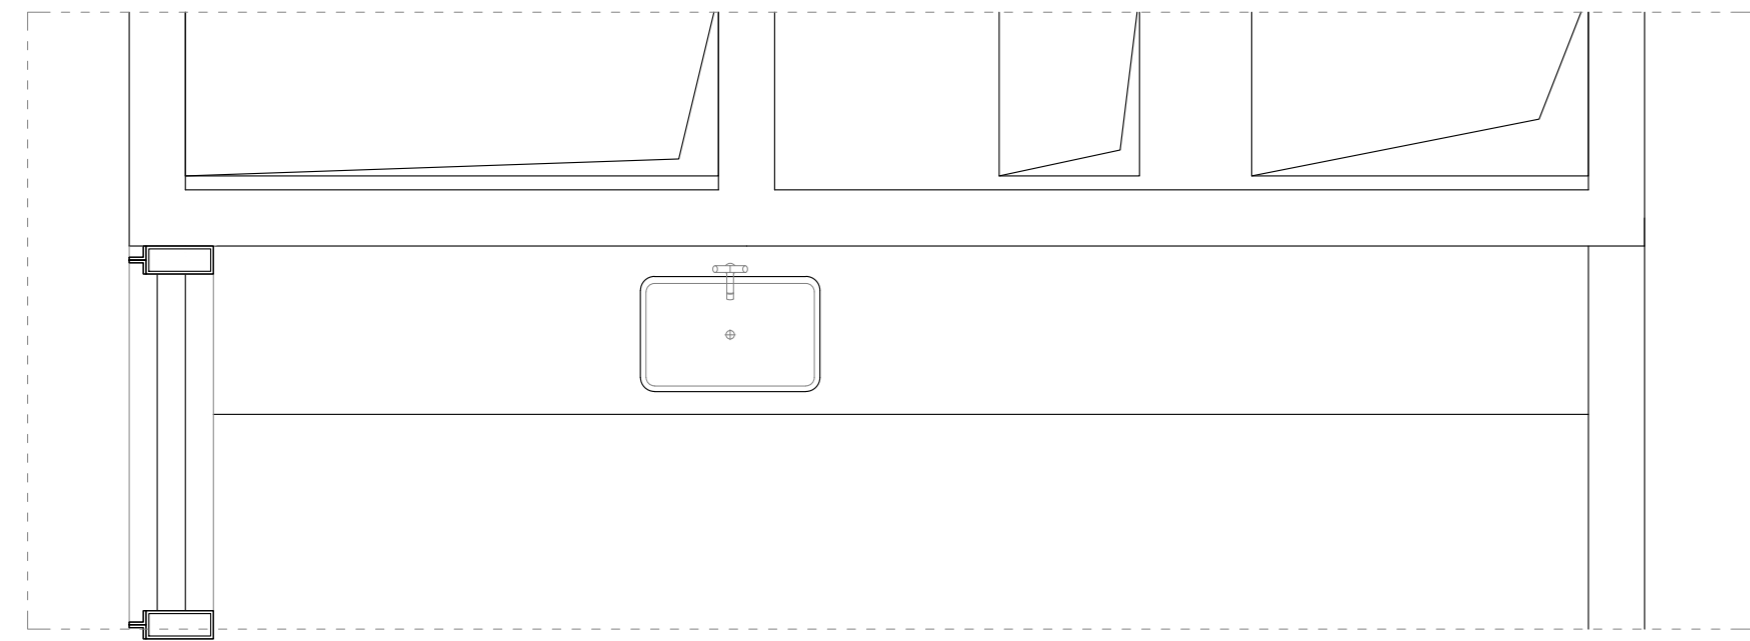

柜内立面图

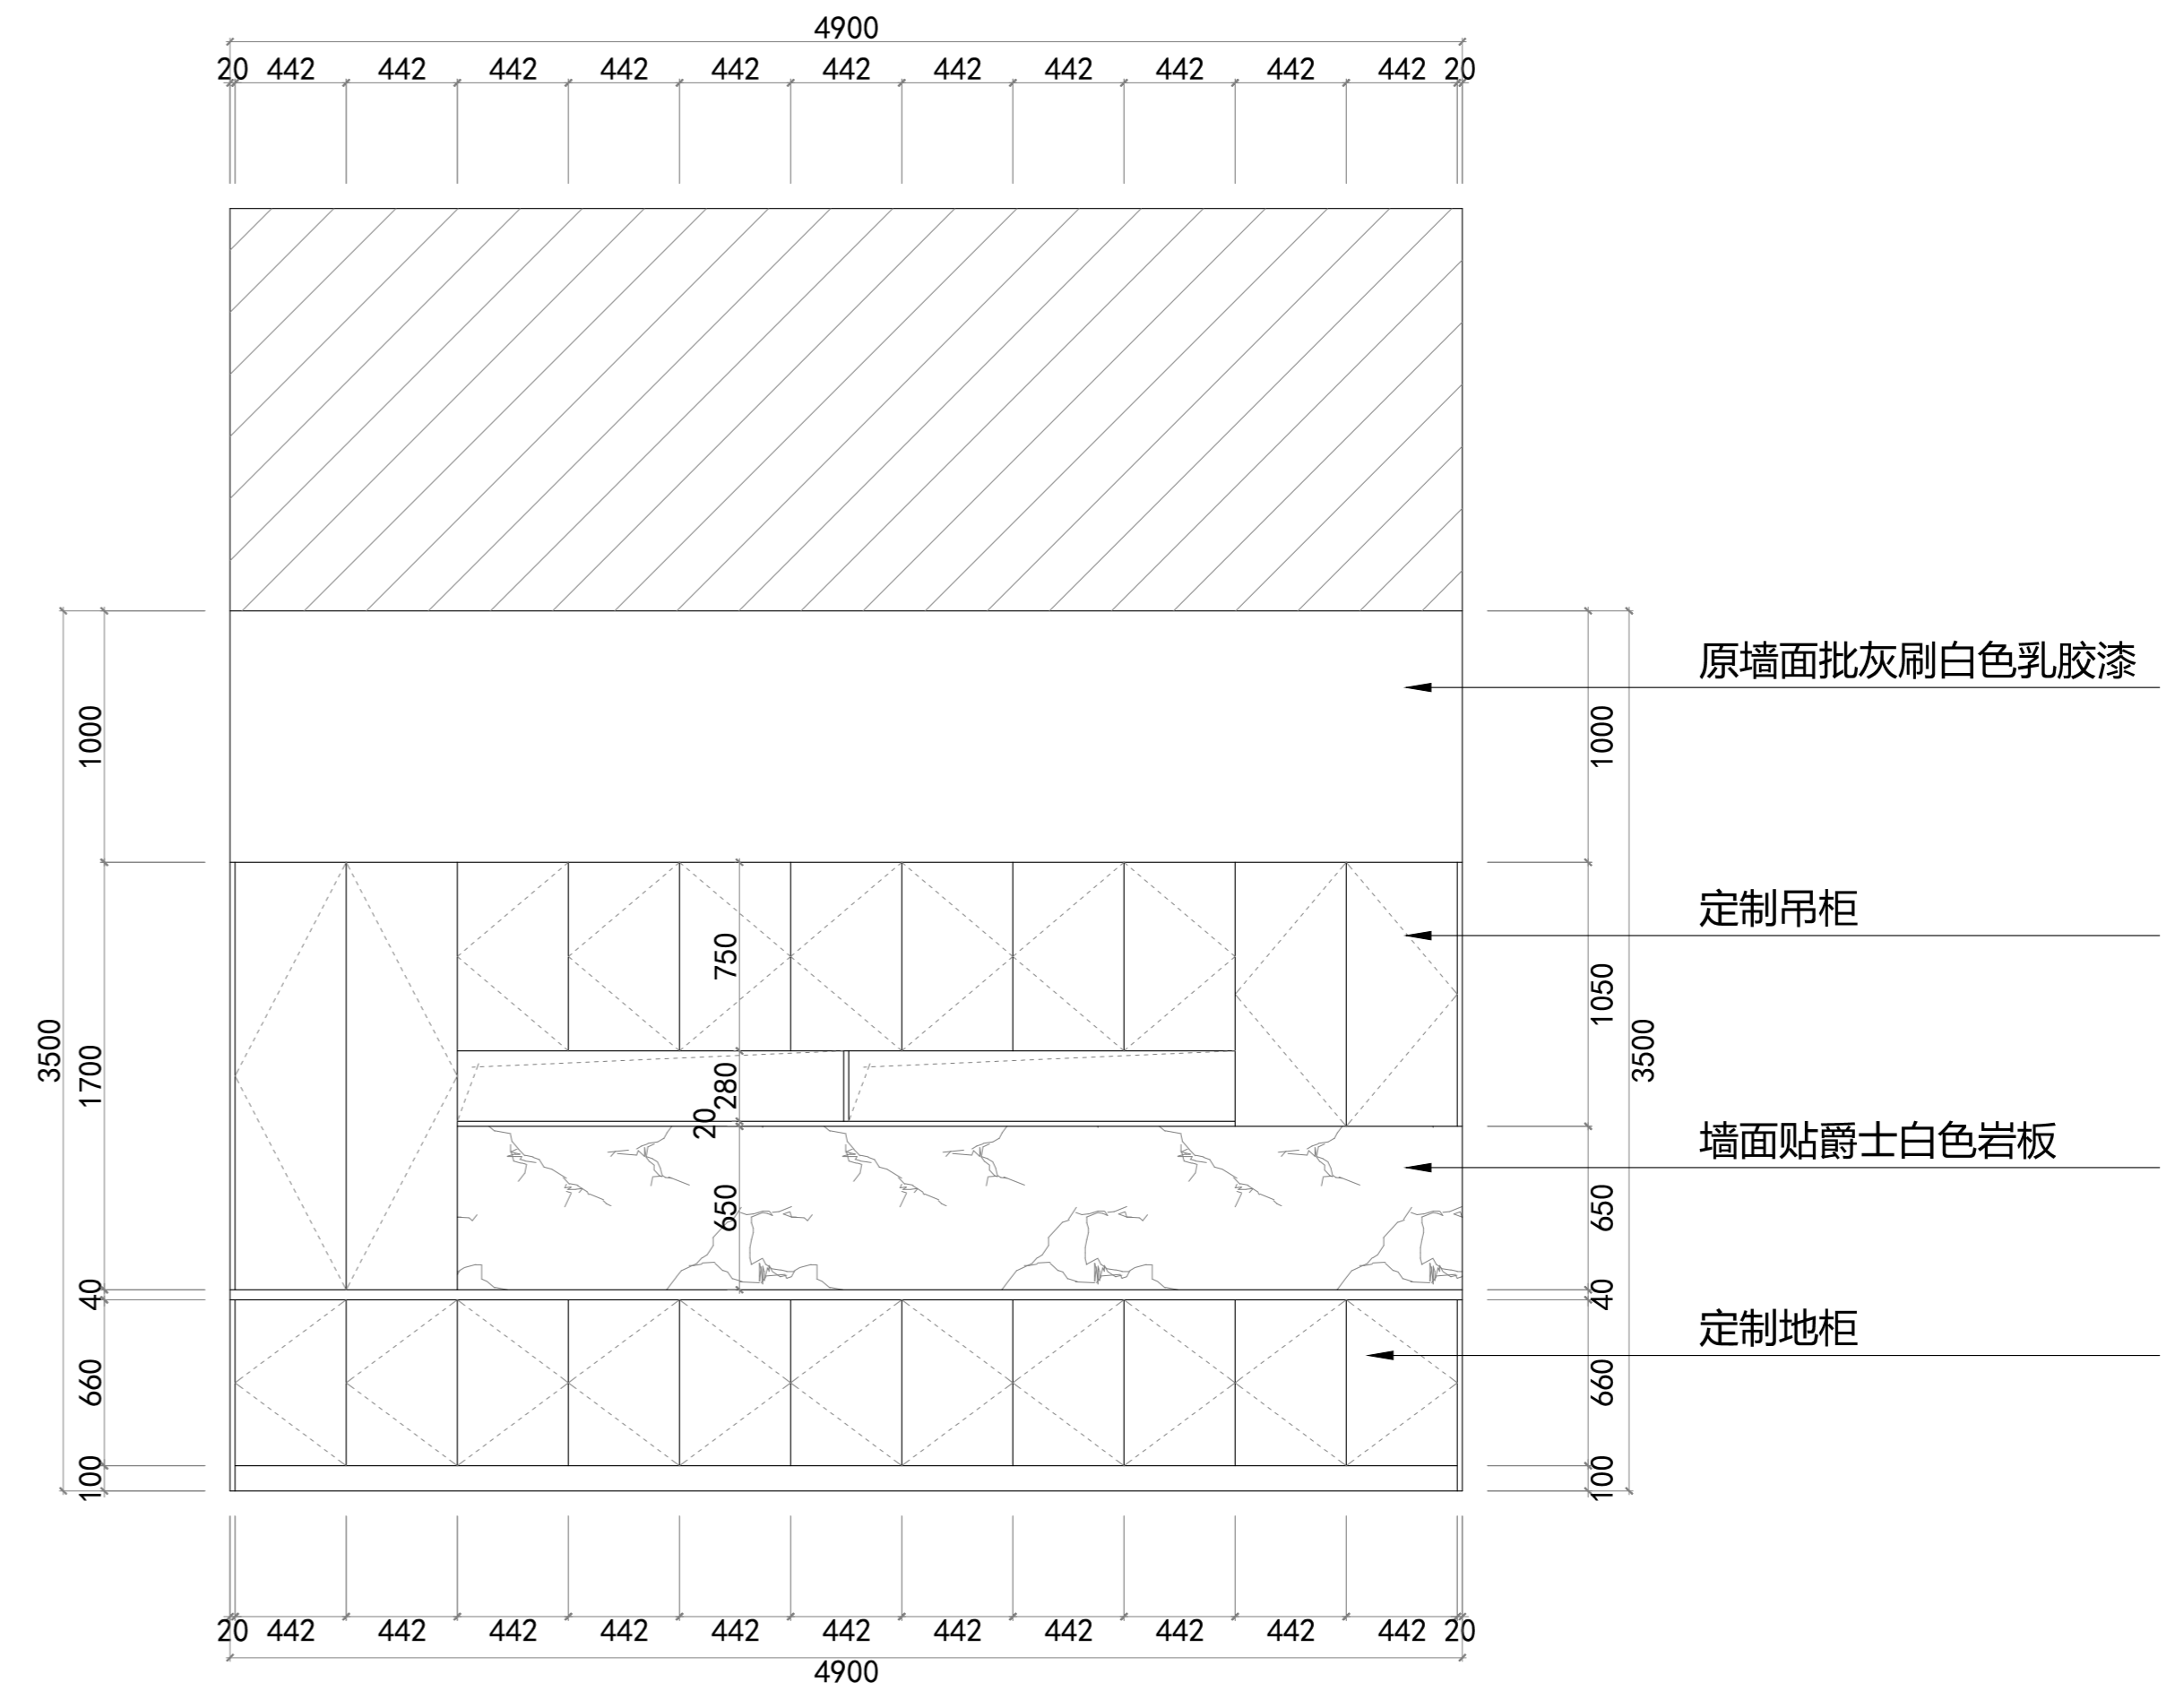

此图版权归本公司，所有尺寸以所注数字为准，并在工地核实无误，使用本图时应参阅其它有关图纸，说明和合同，如有矛盾即通知本公司，设计图若有变更应按下栏最后修改记录或变更通知单为准。
 This drawings & design are copyright and portion may be reproduced without the written permission of the architect. All written dimensions or grid line measurements to existing work to be checked on site. This drawings is to be read in conjunction with the specification & conditions of contract, and with general architectural plans, structural plans and all immediately of any discrepancy found the drawings not showing the last revisions above are to be cancelled.

工程名称
PROJECT NAME
图纸名称
DRAWING TITLE



异能无人机学园
C立面图

次数 NO	修改日期	REVISIONS
△		
△		
△		
△		

设计负责人
PROJECT DIRECTOR
设计
DESIGNED BY
审核
APPROVED BY

业主(甲方)
CLIENT
制图
DRAWN BY
比例
SCALE

图号
DRAWING NO
日期
DATE
L-04

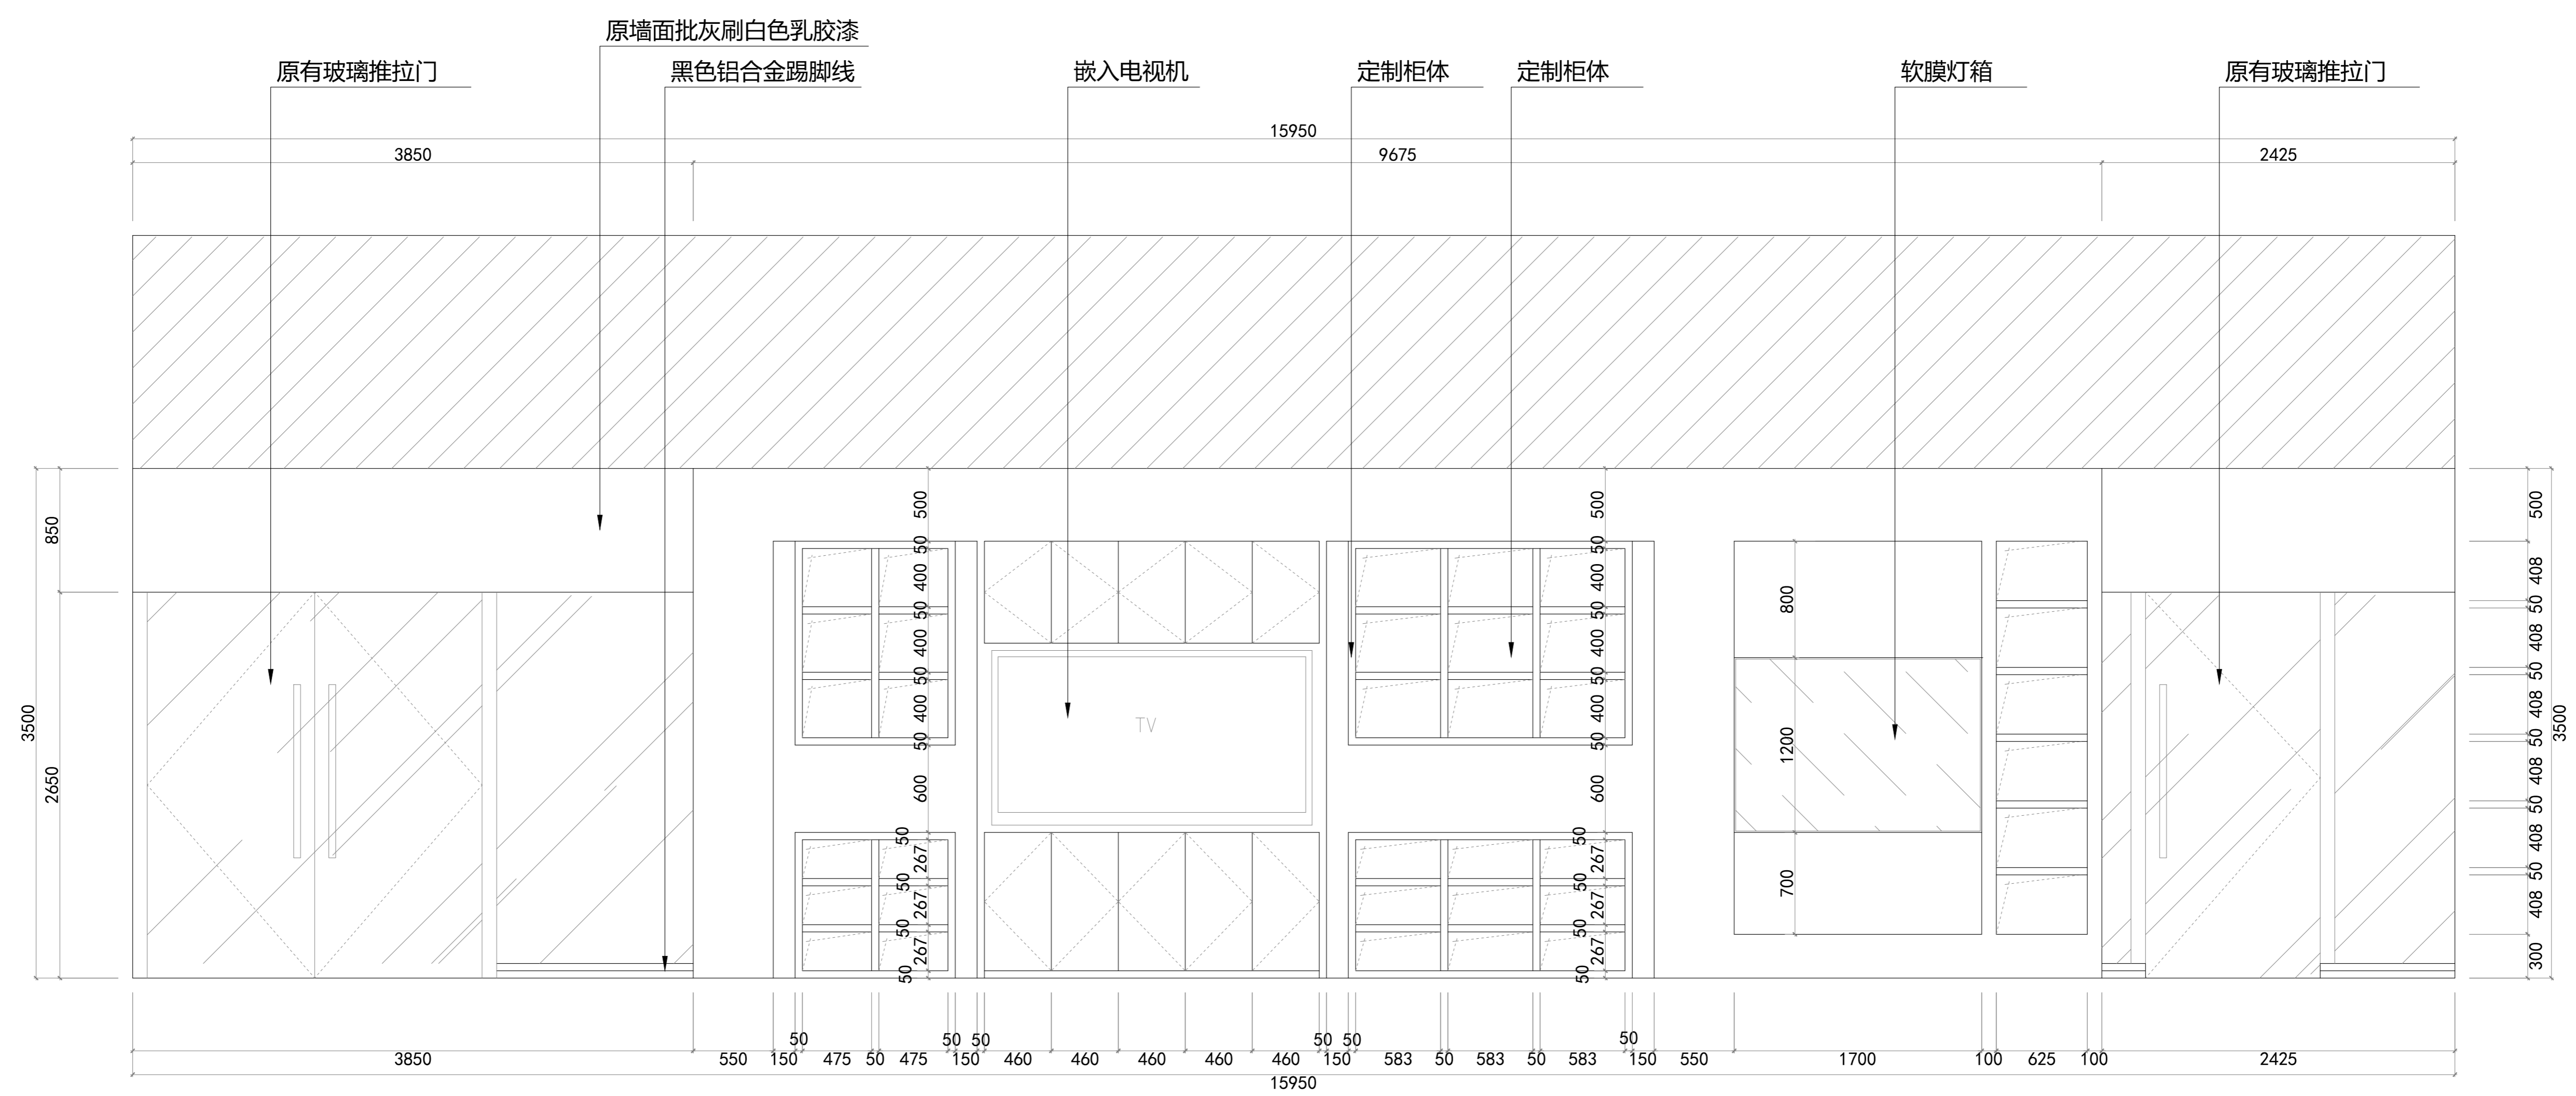
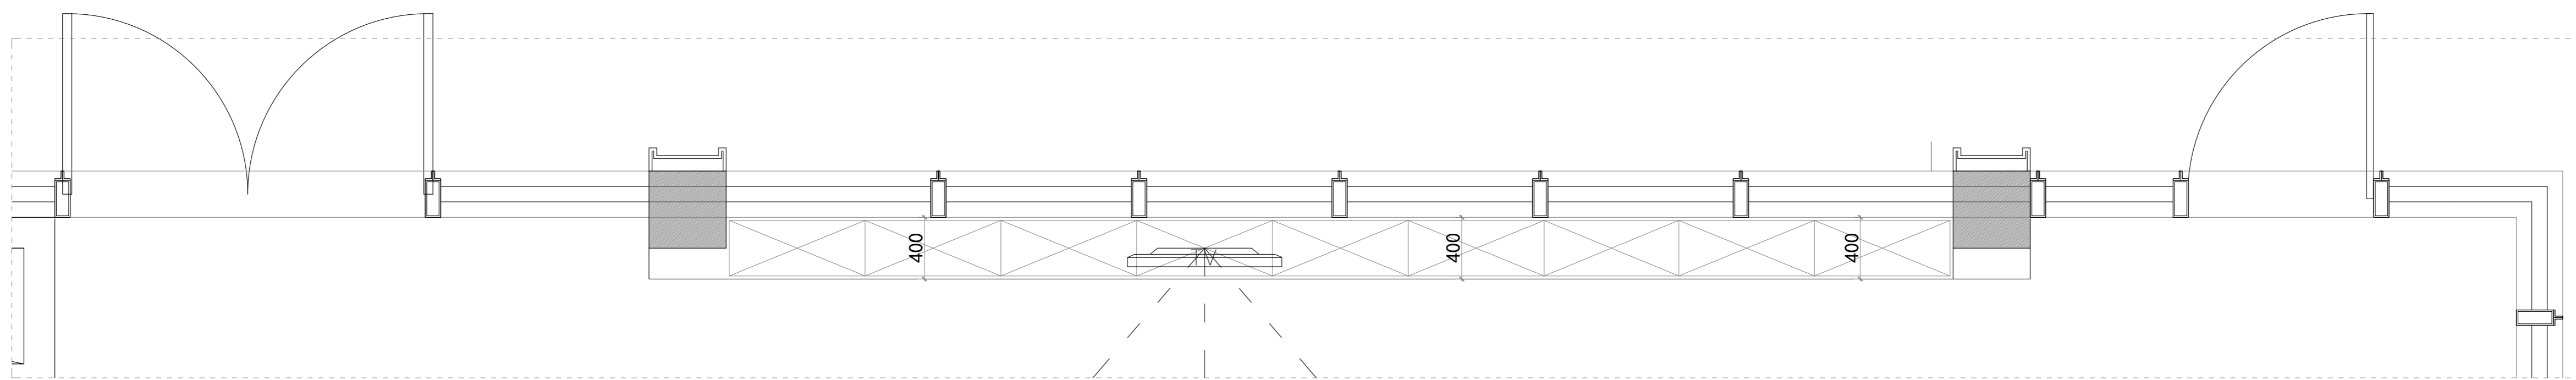


此图版权归本公司，所有尺寸以所注数字为准，并在工地核实无误，使用本图时应参阅其它有关图纸，说明和合同，如有矛盾即通知本公司，设计图若有变更应按下列最后修改记录或变更通知单为准。
 This drawings & design are copyright and portion may be reproduced without the written permission of the architect. All written dimensions or grid lines measurements to existing work to be checked on site. This drawings is to be read in conjunction with the specification & conditions of contract, and with general architectural plans, structural plans and all immediately of any discrepancy found the drawings not showing the last revisions above are to be cancelled.

工程名称 PROJECT NAME	异能无人机学园
图纸名称 DRAWING TITLE	D立面图

次数 NO	修改日期	REVISIONS
△		
△		
△		
△		

设计负责人 PROJECT DIRECTOR	业主(甲方) CLIENT	图号 DRAWING NO	L-05
设计 DESIGNED BY	制图 DRAWN BY	日期 DATE	
审核 APPROVED BY	比例 SCALE		

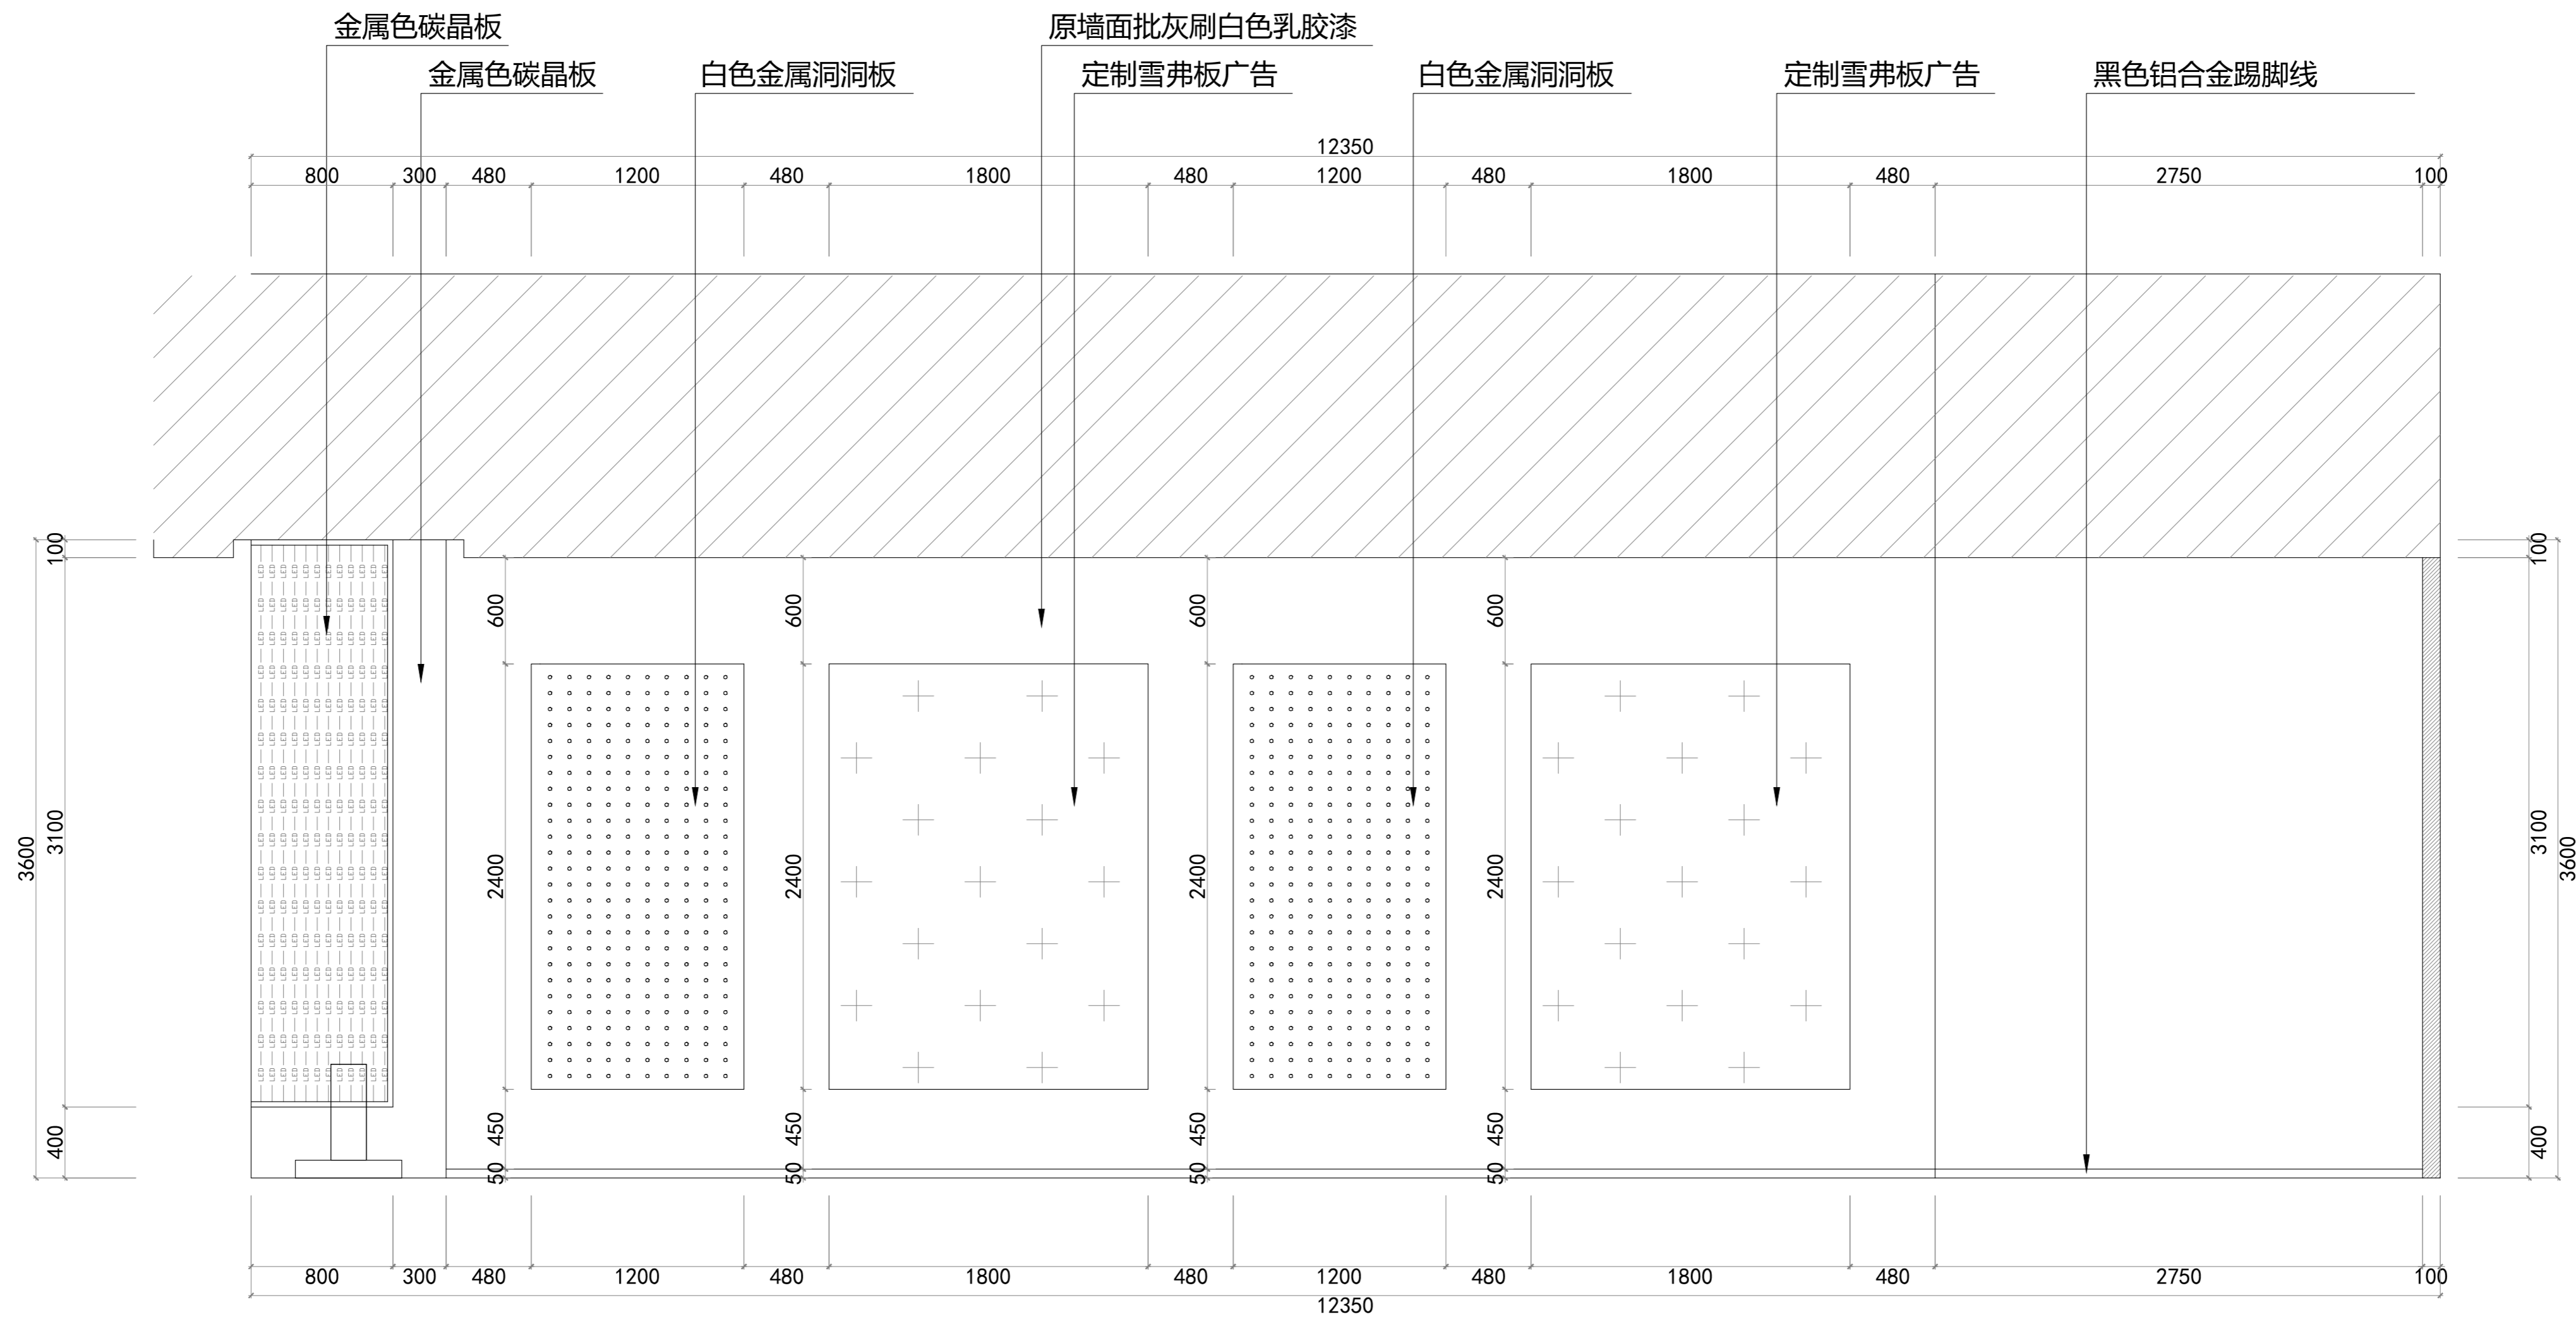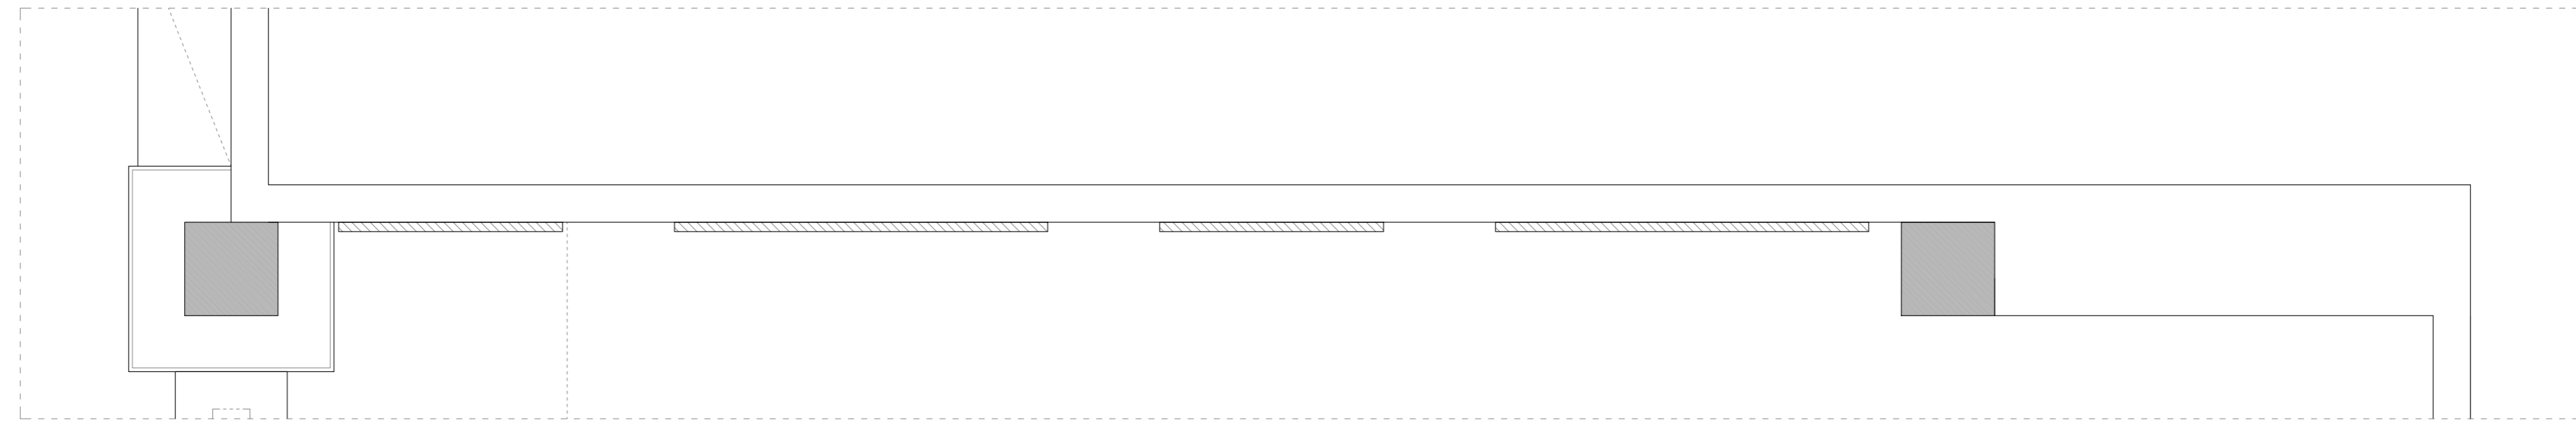

此图版权归本公司，所有尺寸以所注数字为准，并在工地核实无误，使用本图时应参阅其它有关图纸、说明和合同，如有矛盾即通知本公司，设计图若有变更应按下列最后修改记录或变更通知单为准。
 This drawings & design are copyright and portion may be reproduced without the written permission of the architect. The written dimensions or grid line measurements to existing work to be checked on site. This drawings is to be read in conjunction with the specification & conditions of contract, and with general architectural plans, structural plans and all immediately of any discrepancy found the drawings not showing the last revisions above are to be cancelled.



工程名称
PROJECT NAME

图纸名称
DRAWING TITLE

异能无人机学园
E立面图

次数	NO	修改日期	REVISIONS
△			
△			
△			
△			

设计负责人 PROJECT DIRECTOR	业主(甲方) CLIENT	图号 DRAWING NO	L-06
设计 DESIGNED BY	制图 DRAWN BY	日期 DATE	
审核 APPROVED BY	比例 SCALE		

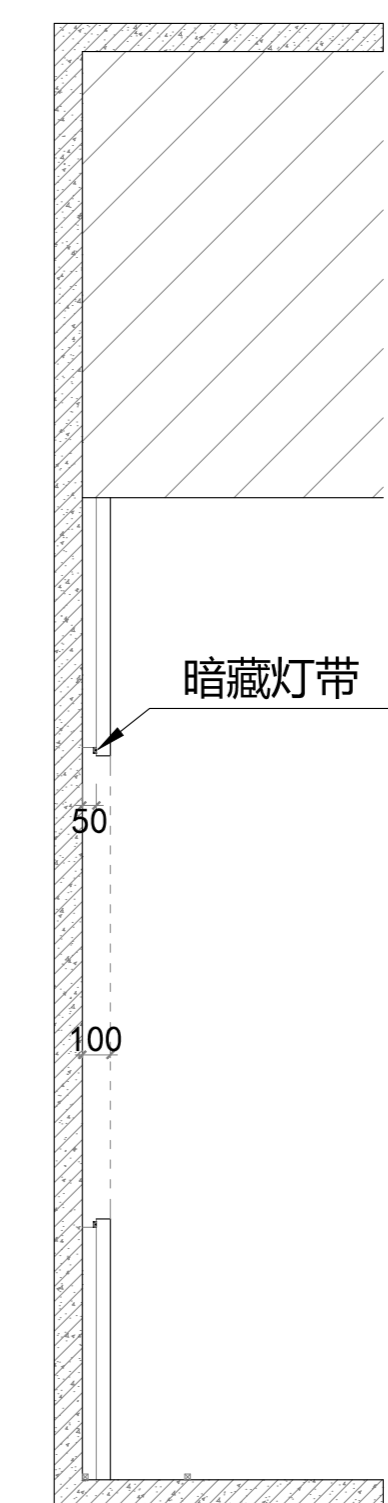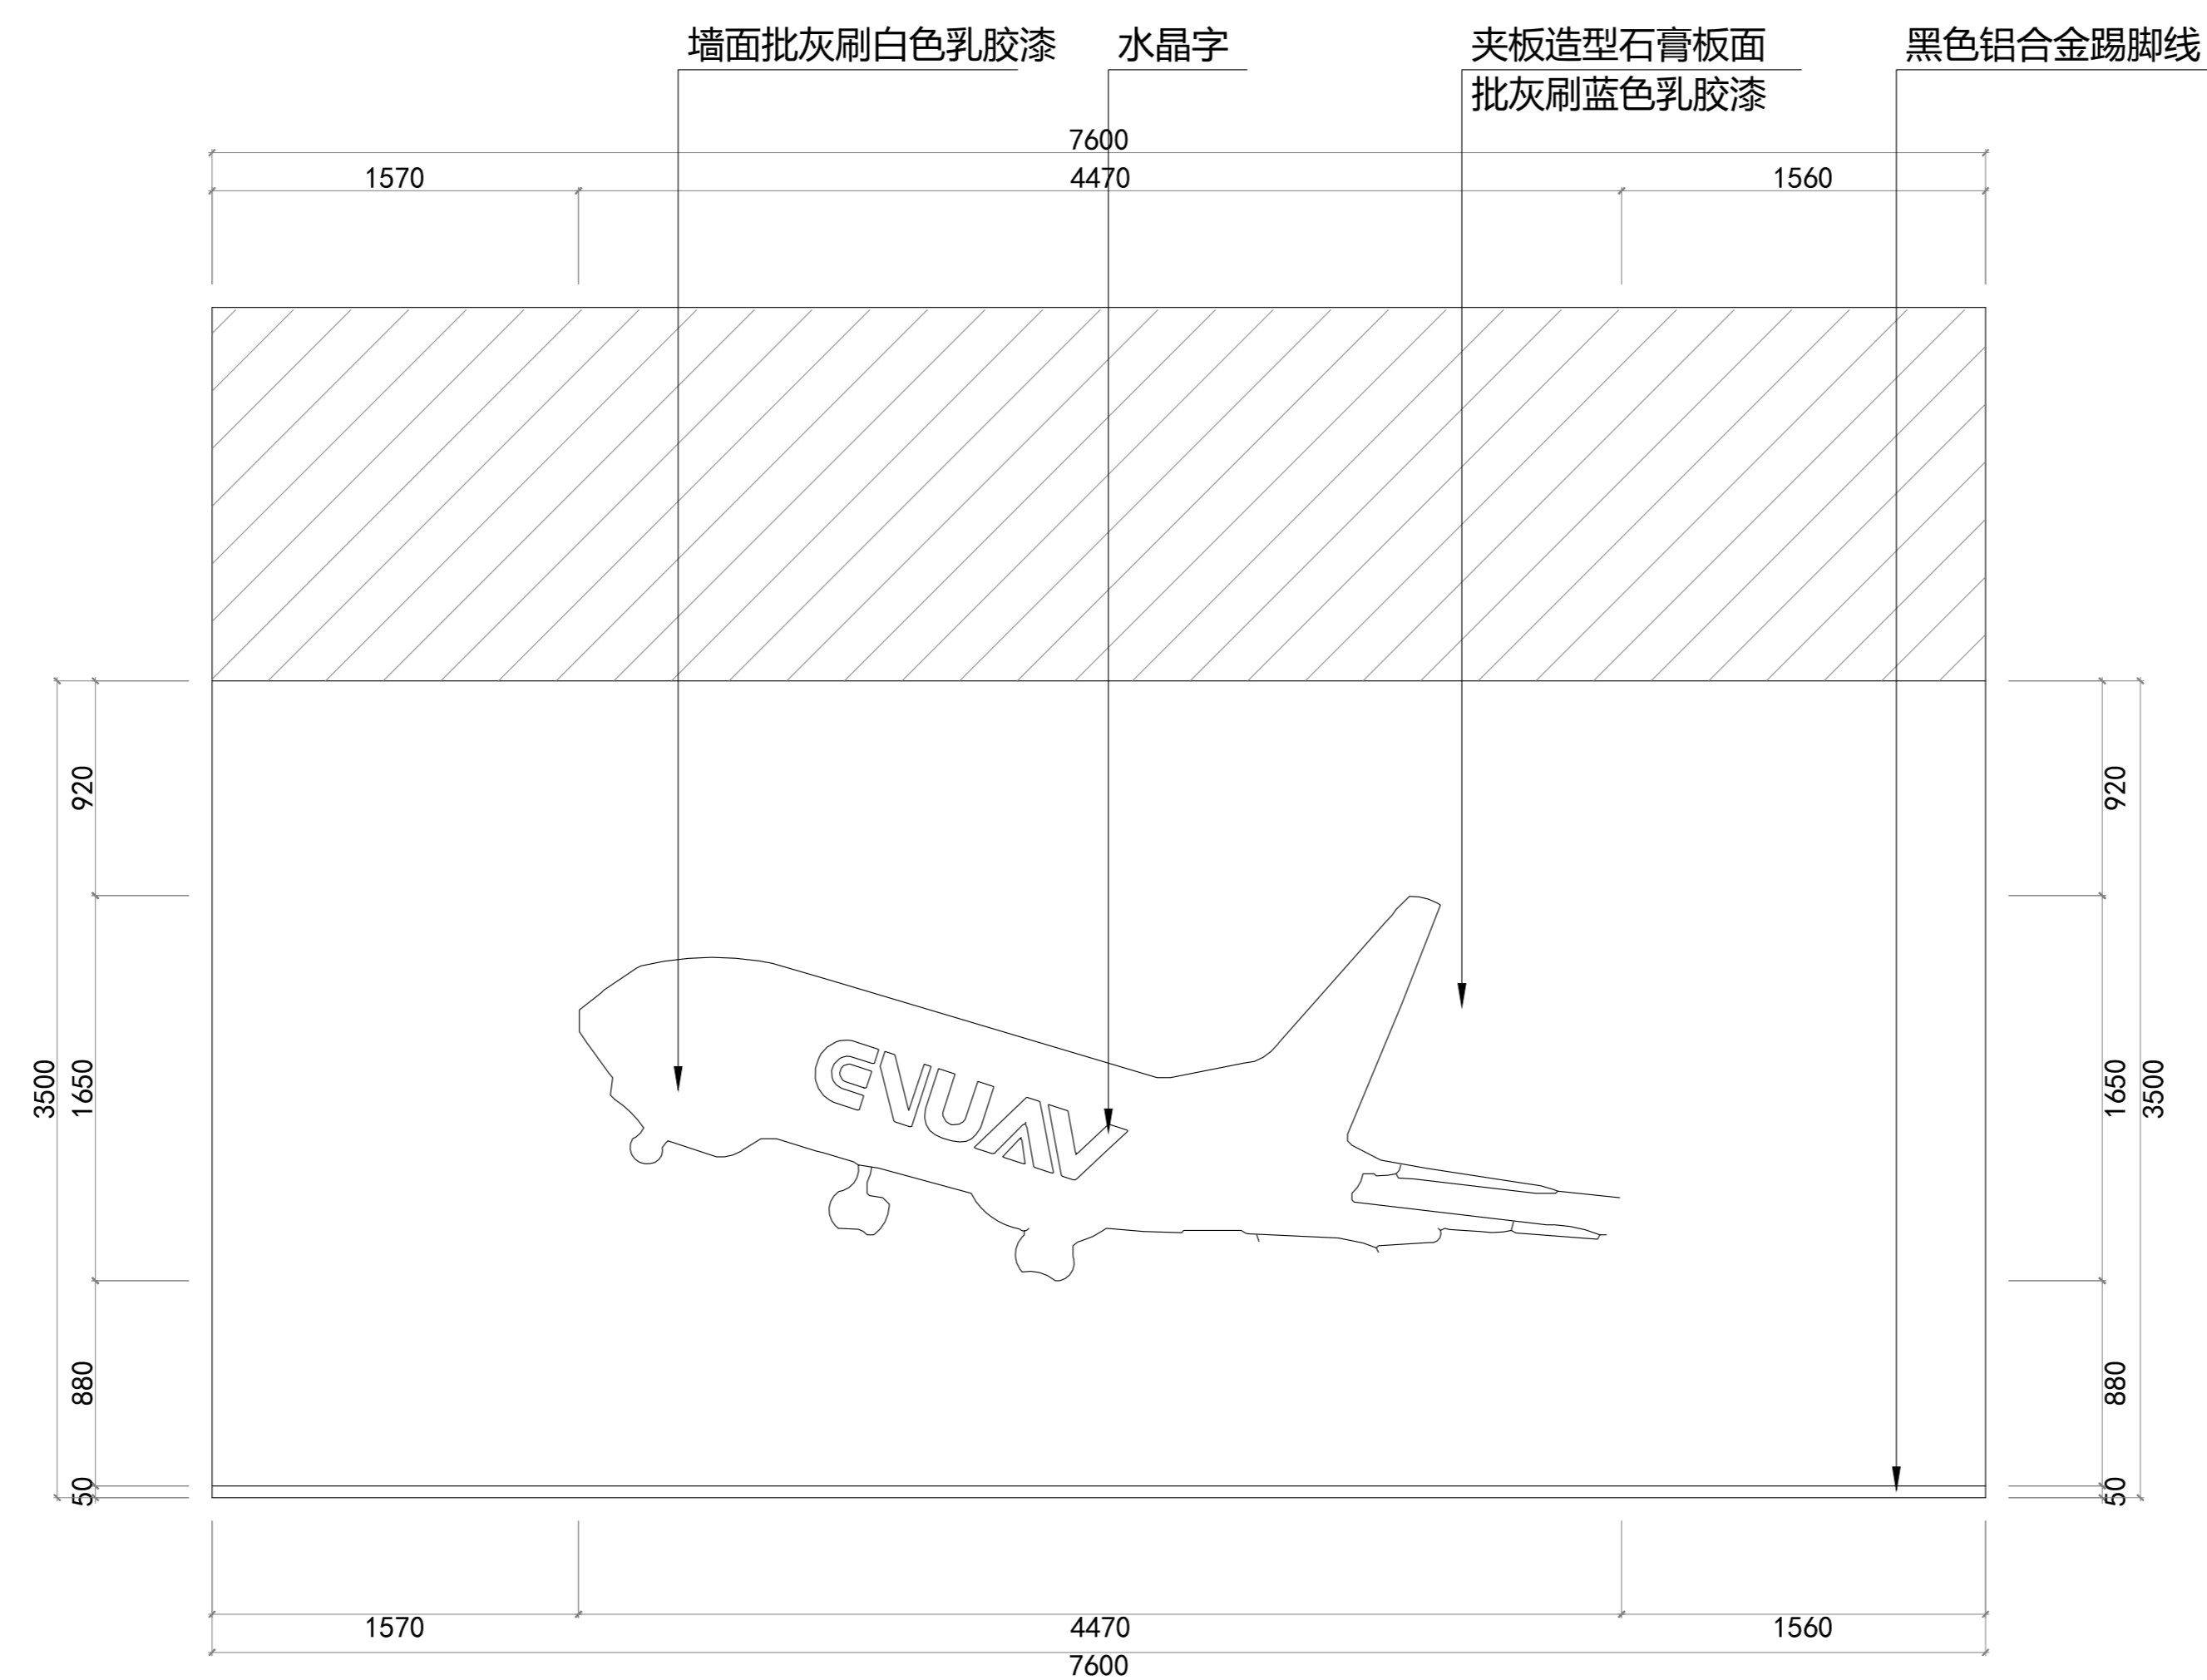

剖面尺寸图

此图版权归本公司，所有尺寸以所注数字为准，并在工地核实无误，使用本图时应参阅其它有关图纸，说明和合同，如有矛盾即通知本公司，设计图若有变更应按下栏最后修改记录或变更通知单为准。
 This drawings & design are copyright and portion may be reproduced without the written permission of the architect. All written dimensions or grid line measurements to existing work to be checked on site. This drawings is to be read in conjunction with the specification & conditions of contract, and with general architectural plans, structural plans and all immediately of any discrepancy found the drawings not showing the last revisions above are to be cancelled.

工程名称
PROJECT NAME

异能无人机学园

图纸名称
DRAWING TITLE

F立面图

次数	NO	修改日期	REVISIONS
△			
△			
△			
△			

设计负责人
PROJECT DIRECTOR

设计
DESIGNED BY

审核
APPROVED BY

业主(甲方)
CLIENT



制图
DRAWN BY

比例
SCALE


图号
DRAWING NO

日期
DATE

L-07

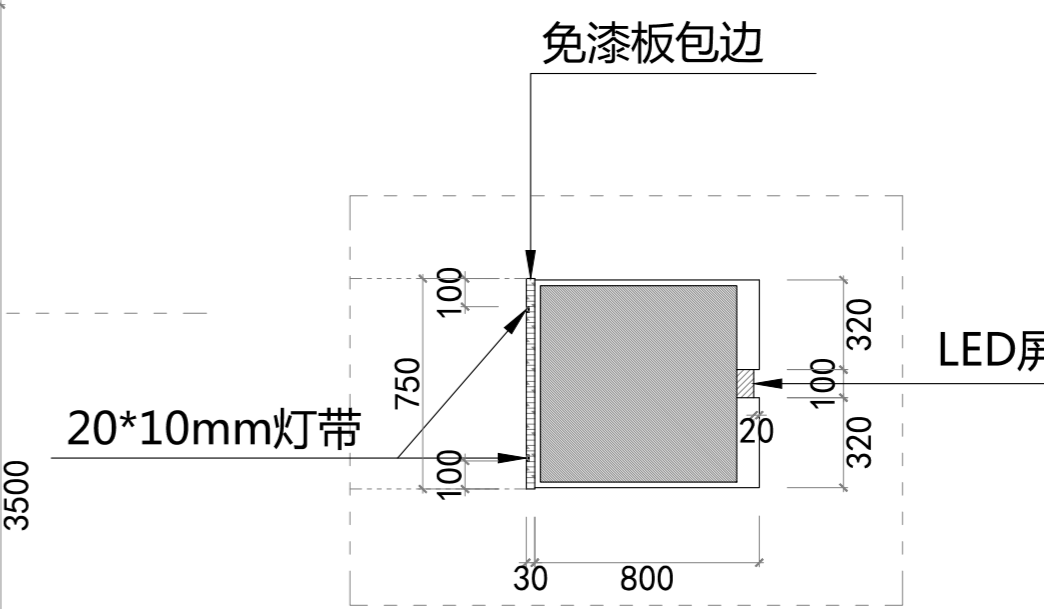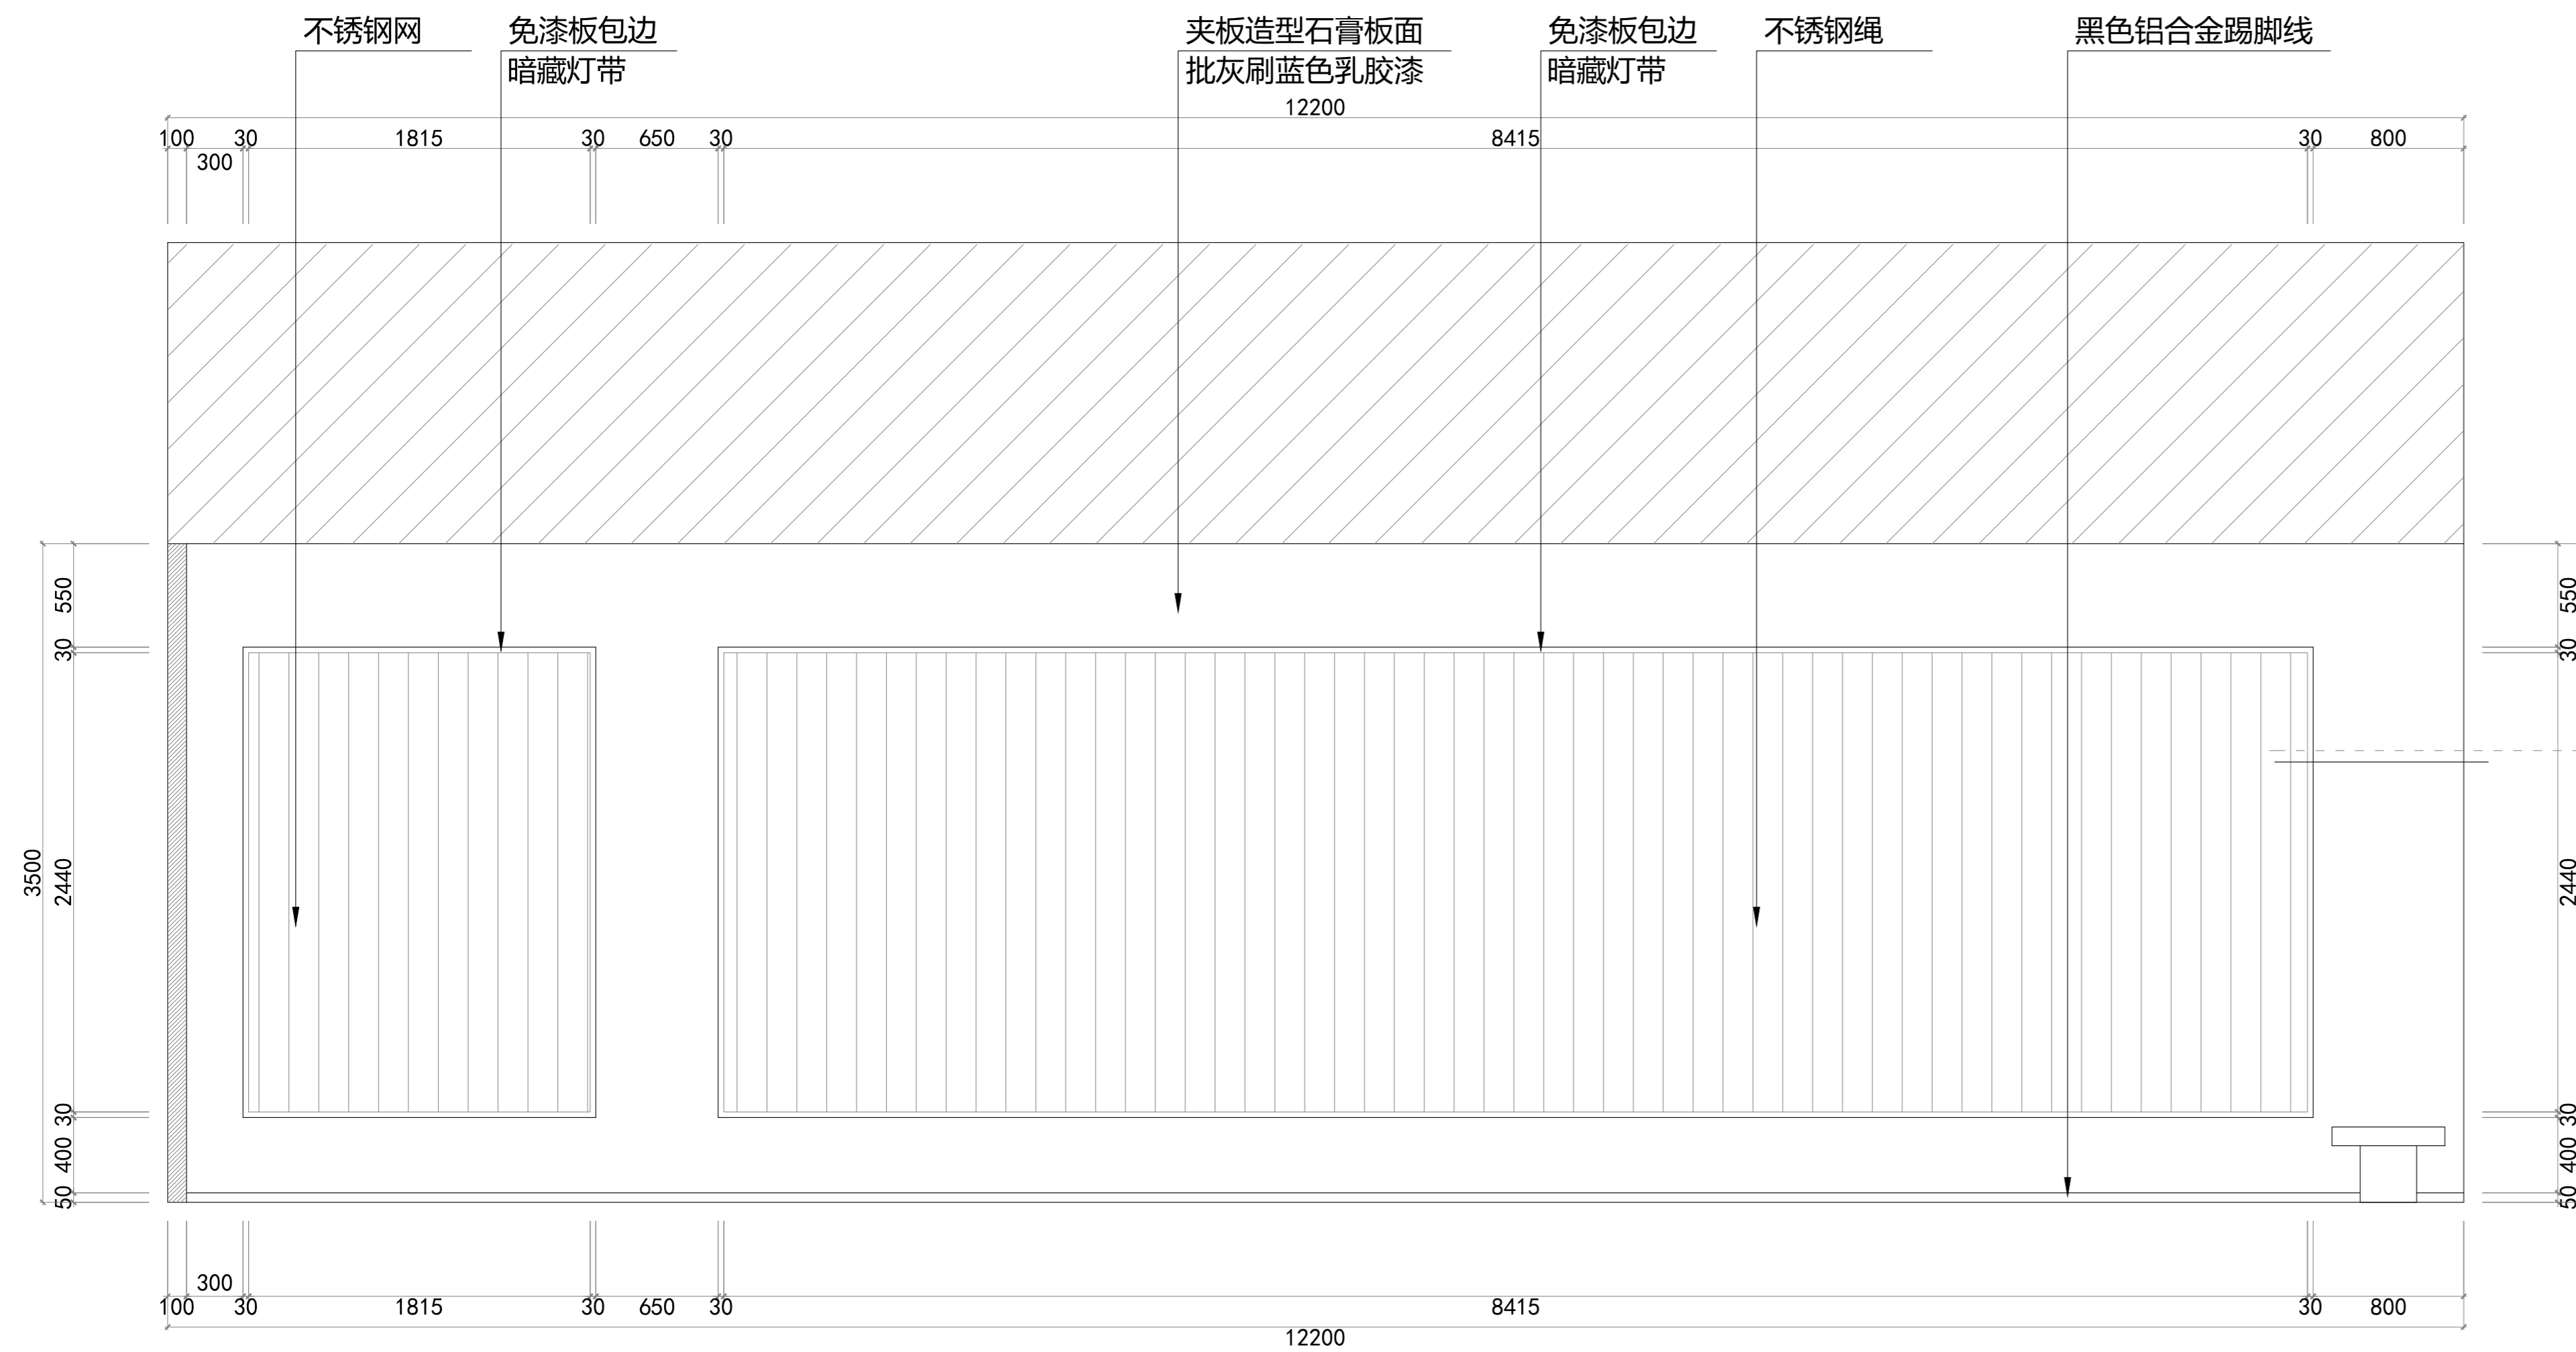

剖面尺寸图

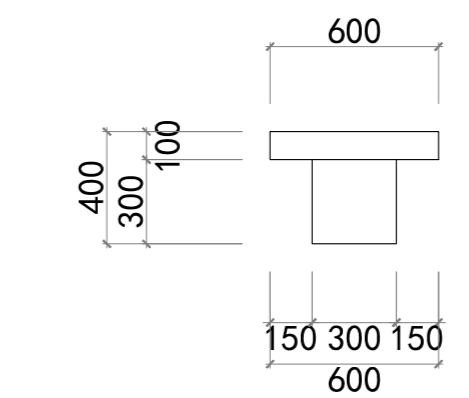




长凳剖面尺寸图

此图版权归本公司，所有尺寸以所注数字为准，并在工地核实无误，使用本图时应参阅其它有关图纸、说明和合同，如有矛盾即通知本公司，设计图若有变更应按下栏最后修改记录或变更通知单为准。
 This drawings & design are copyright and portion may be reproduced without the written permission of the architect. All written dimensions or grid line measurements to existing work to be checked on site. This drawings is to be read in conjunction with the specification & conditions of contract, and with general architectural plans, structural plans and all immediately of any discrepancy found the drawings not showing the last revisions above are to be cancelled.

工程名称 PROJECT NAME	异能无人机学园
图纸名称 DRAWING TITLE	G立面图

次数 NO	修改日期	REVISIONS
△		
△		
△		
△		

设计负责人 PROJECT DIRECTOR	业主(甲方) CLIENT	图号 DRAWING NO	L-08
设计 DESIGNED BY	制图 DRAWN BY	日期 DATE	
审核 APPROVED BY	比例 SCALE		

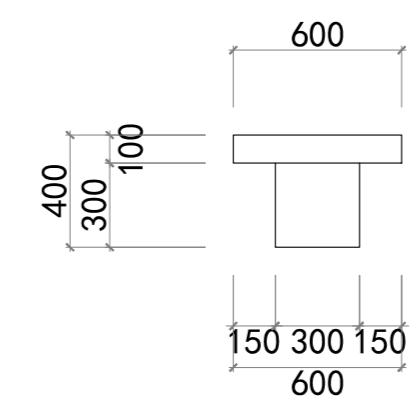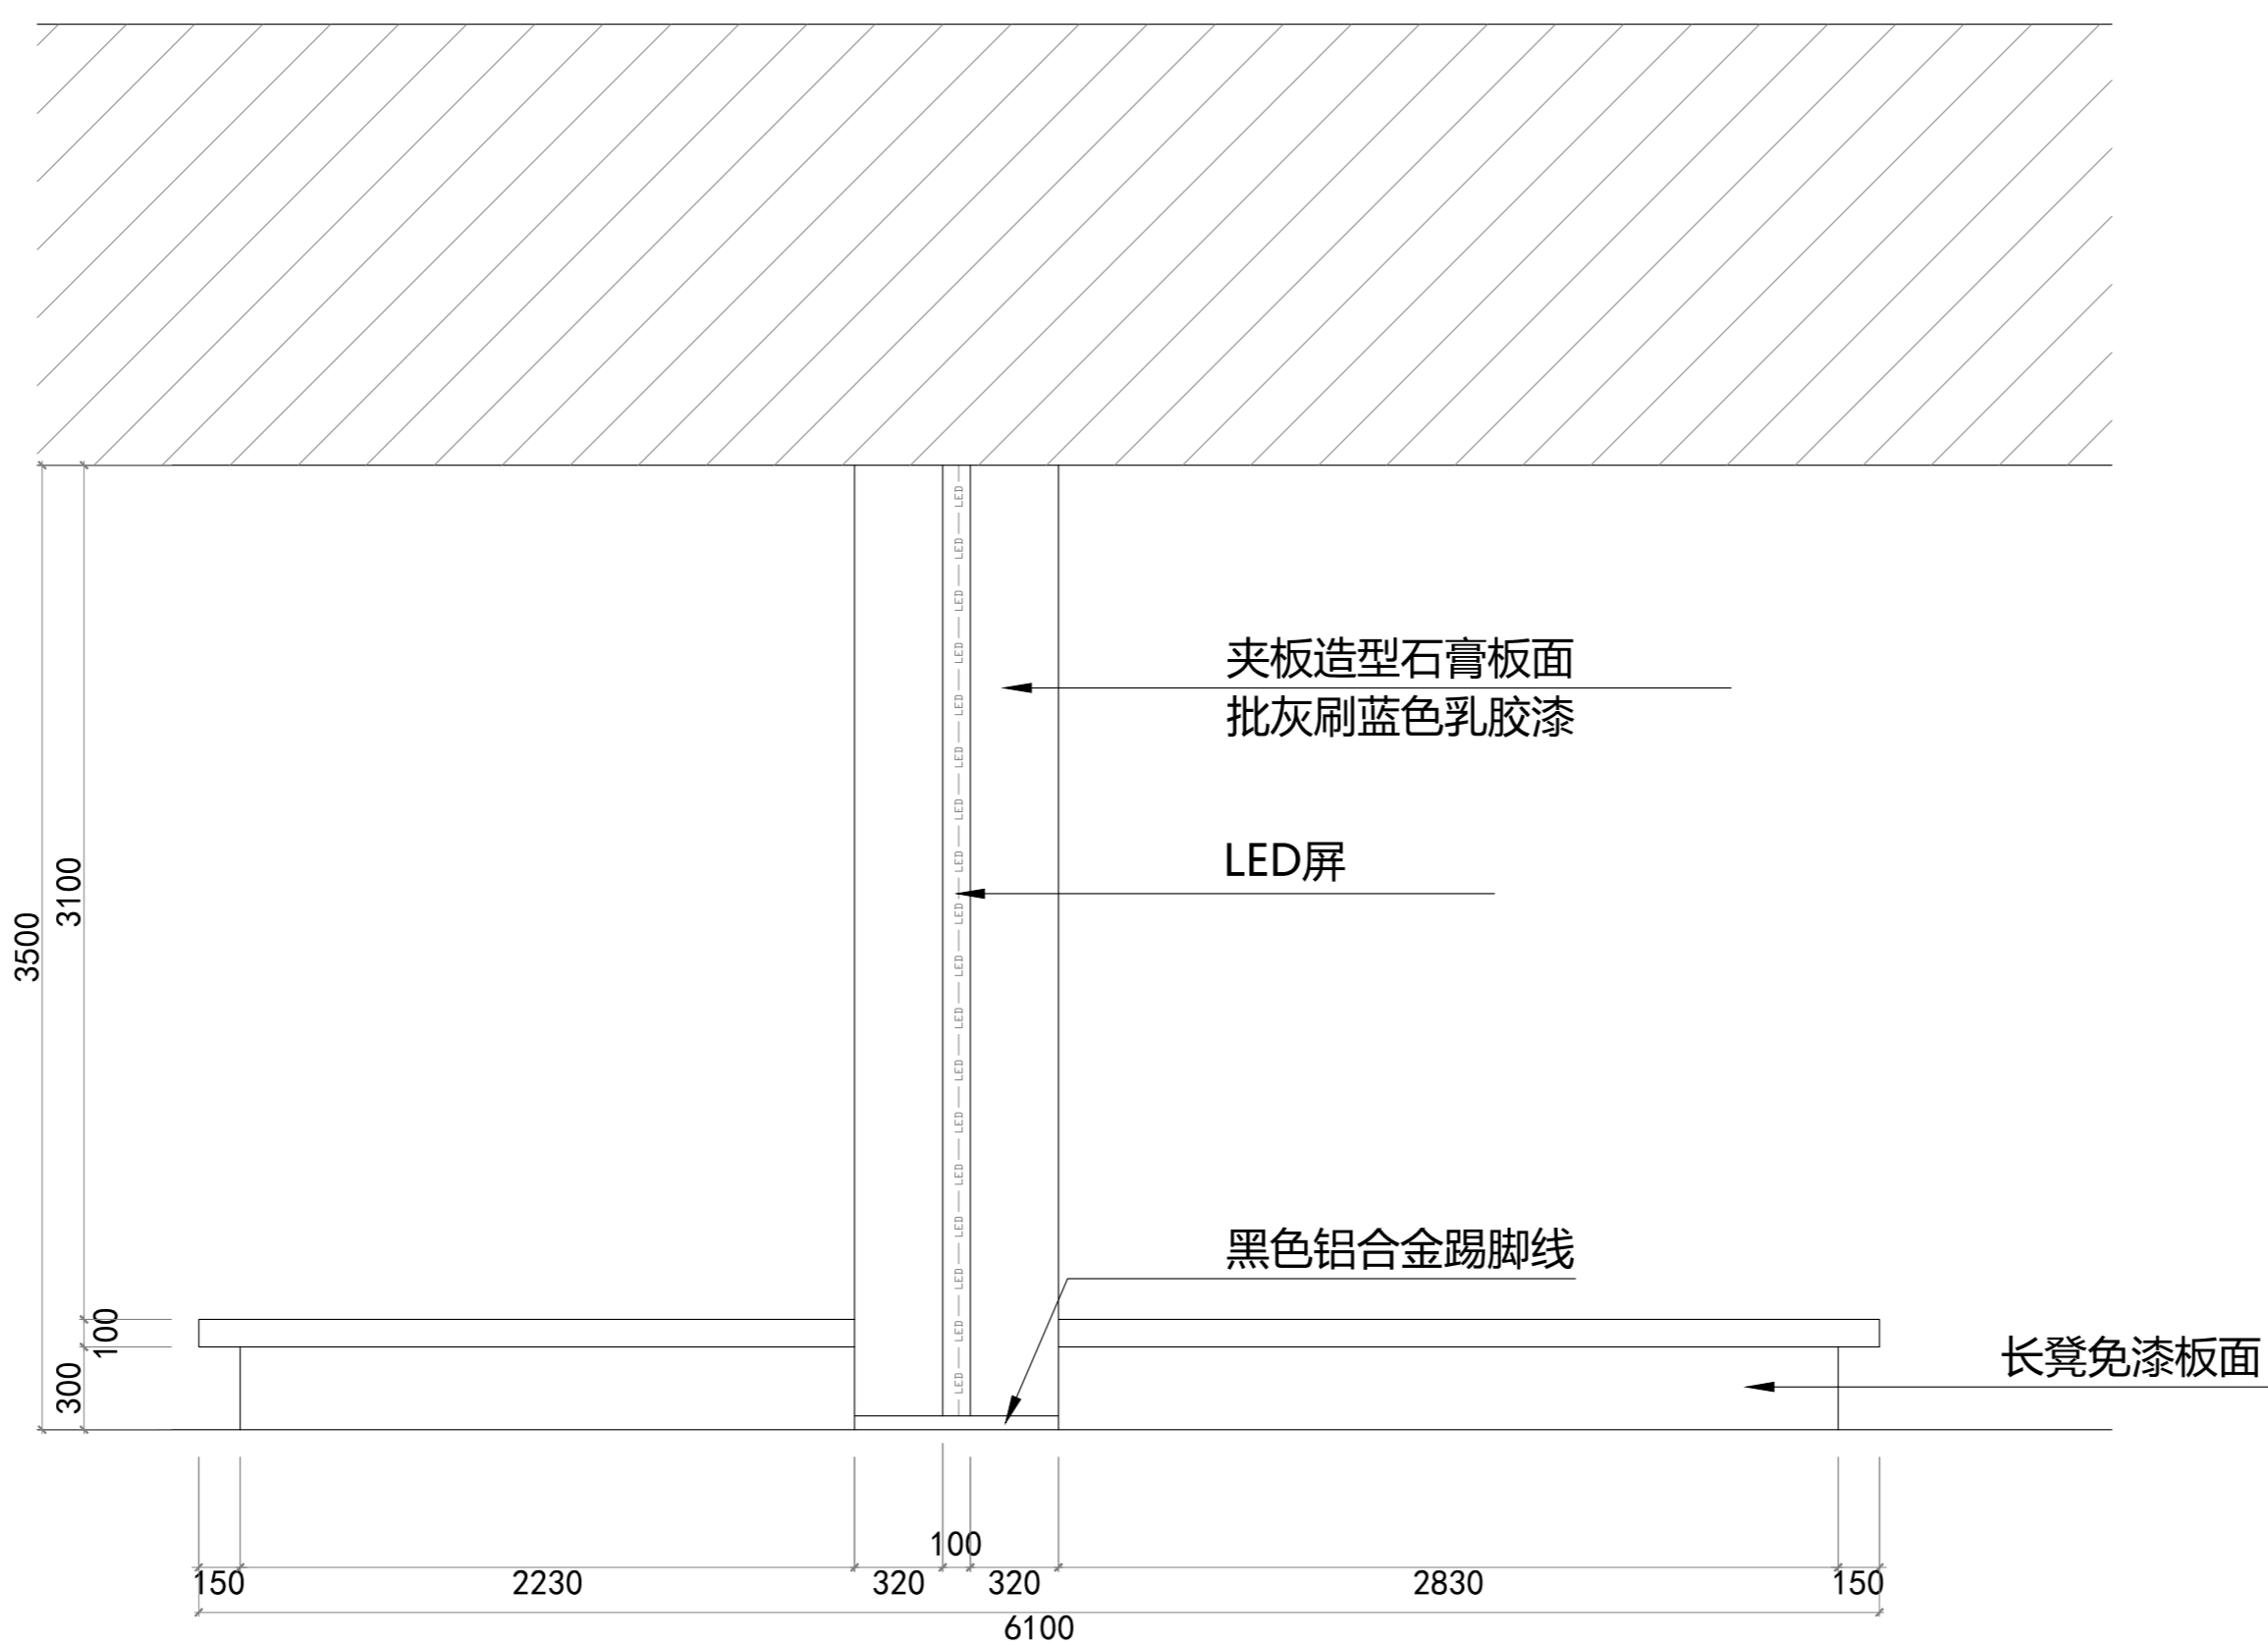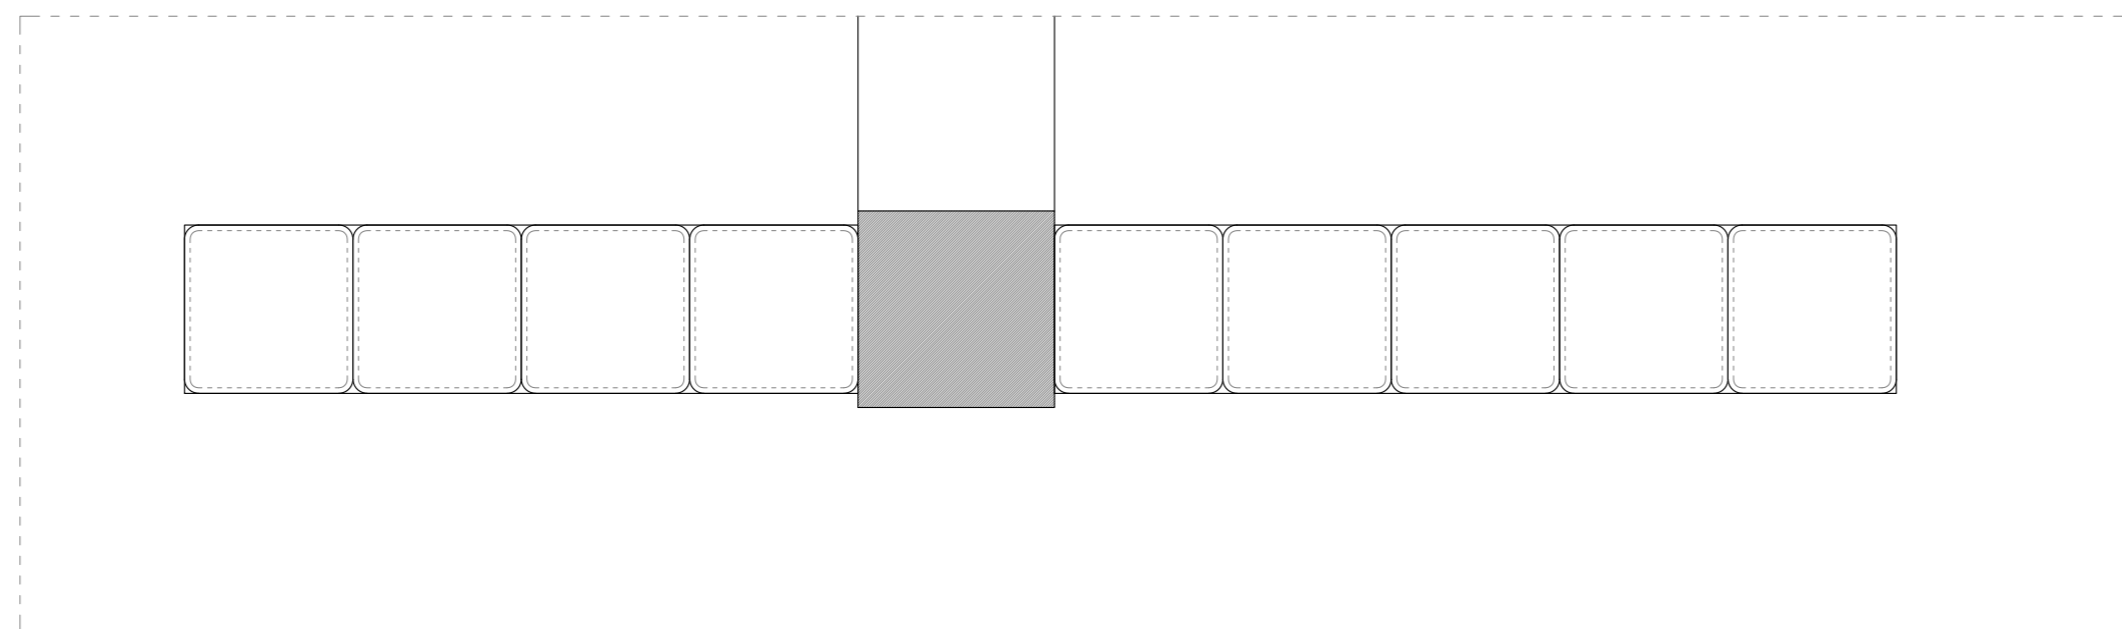

长凳剖面尺寸图



此图版权归本公司，所有尺寸以所注数字为准，并在工地核实无误，使用本图时应参阅其它有关图纸，说明和合同，如有矛盾即通知本公司，设计图若有变更应按下栏最后修改记录或变更通知单为准。
This drawings & design are copyright and portion may be reproduced without the written permission of the architect. All written dimensions or grid line measurements to existing work to be checked on site. This drawings is to be read in conjunction with the specification & conditions of contract, and with general architectural plans, structural plans and all immediately of any discrepancy found the drawings not showing the last revisions above are to be cancelled.

工程名称
PROJECT NAME
图纸名称
DRAWING TITLE

异能无人机学园
H立面图

次数	NO	修改日期	REVISIONS
△			
△			
△			
△			

设计负责人 PROJECT DIRECTOR	业主(甲方) CLIENT	图号 DRAWING NO	L-09
设计 DESIGNED BY	制图 DRAWN BY	日期 DATE	
审核 APPROVED BY	比例 SCALE		

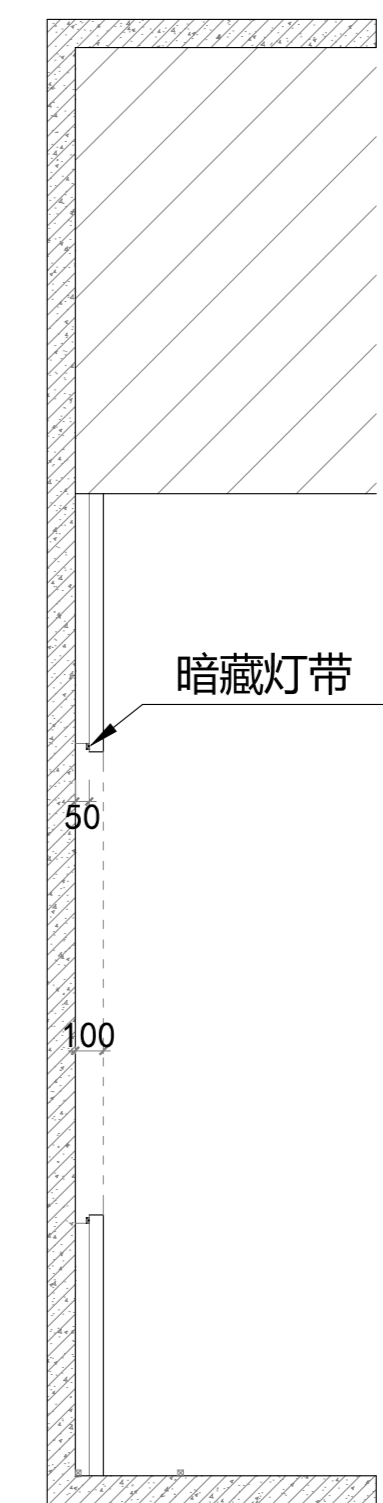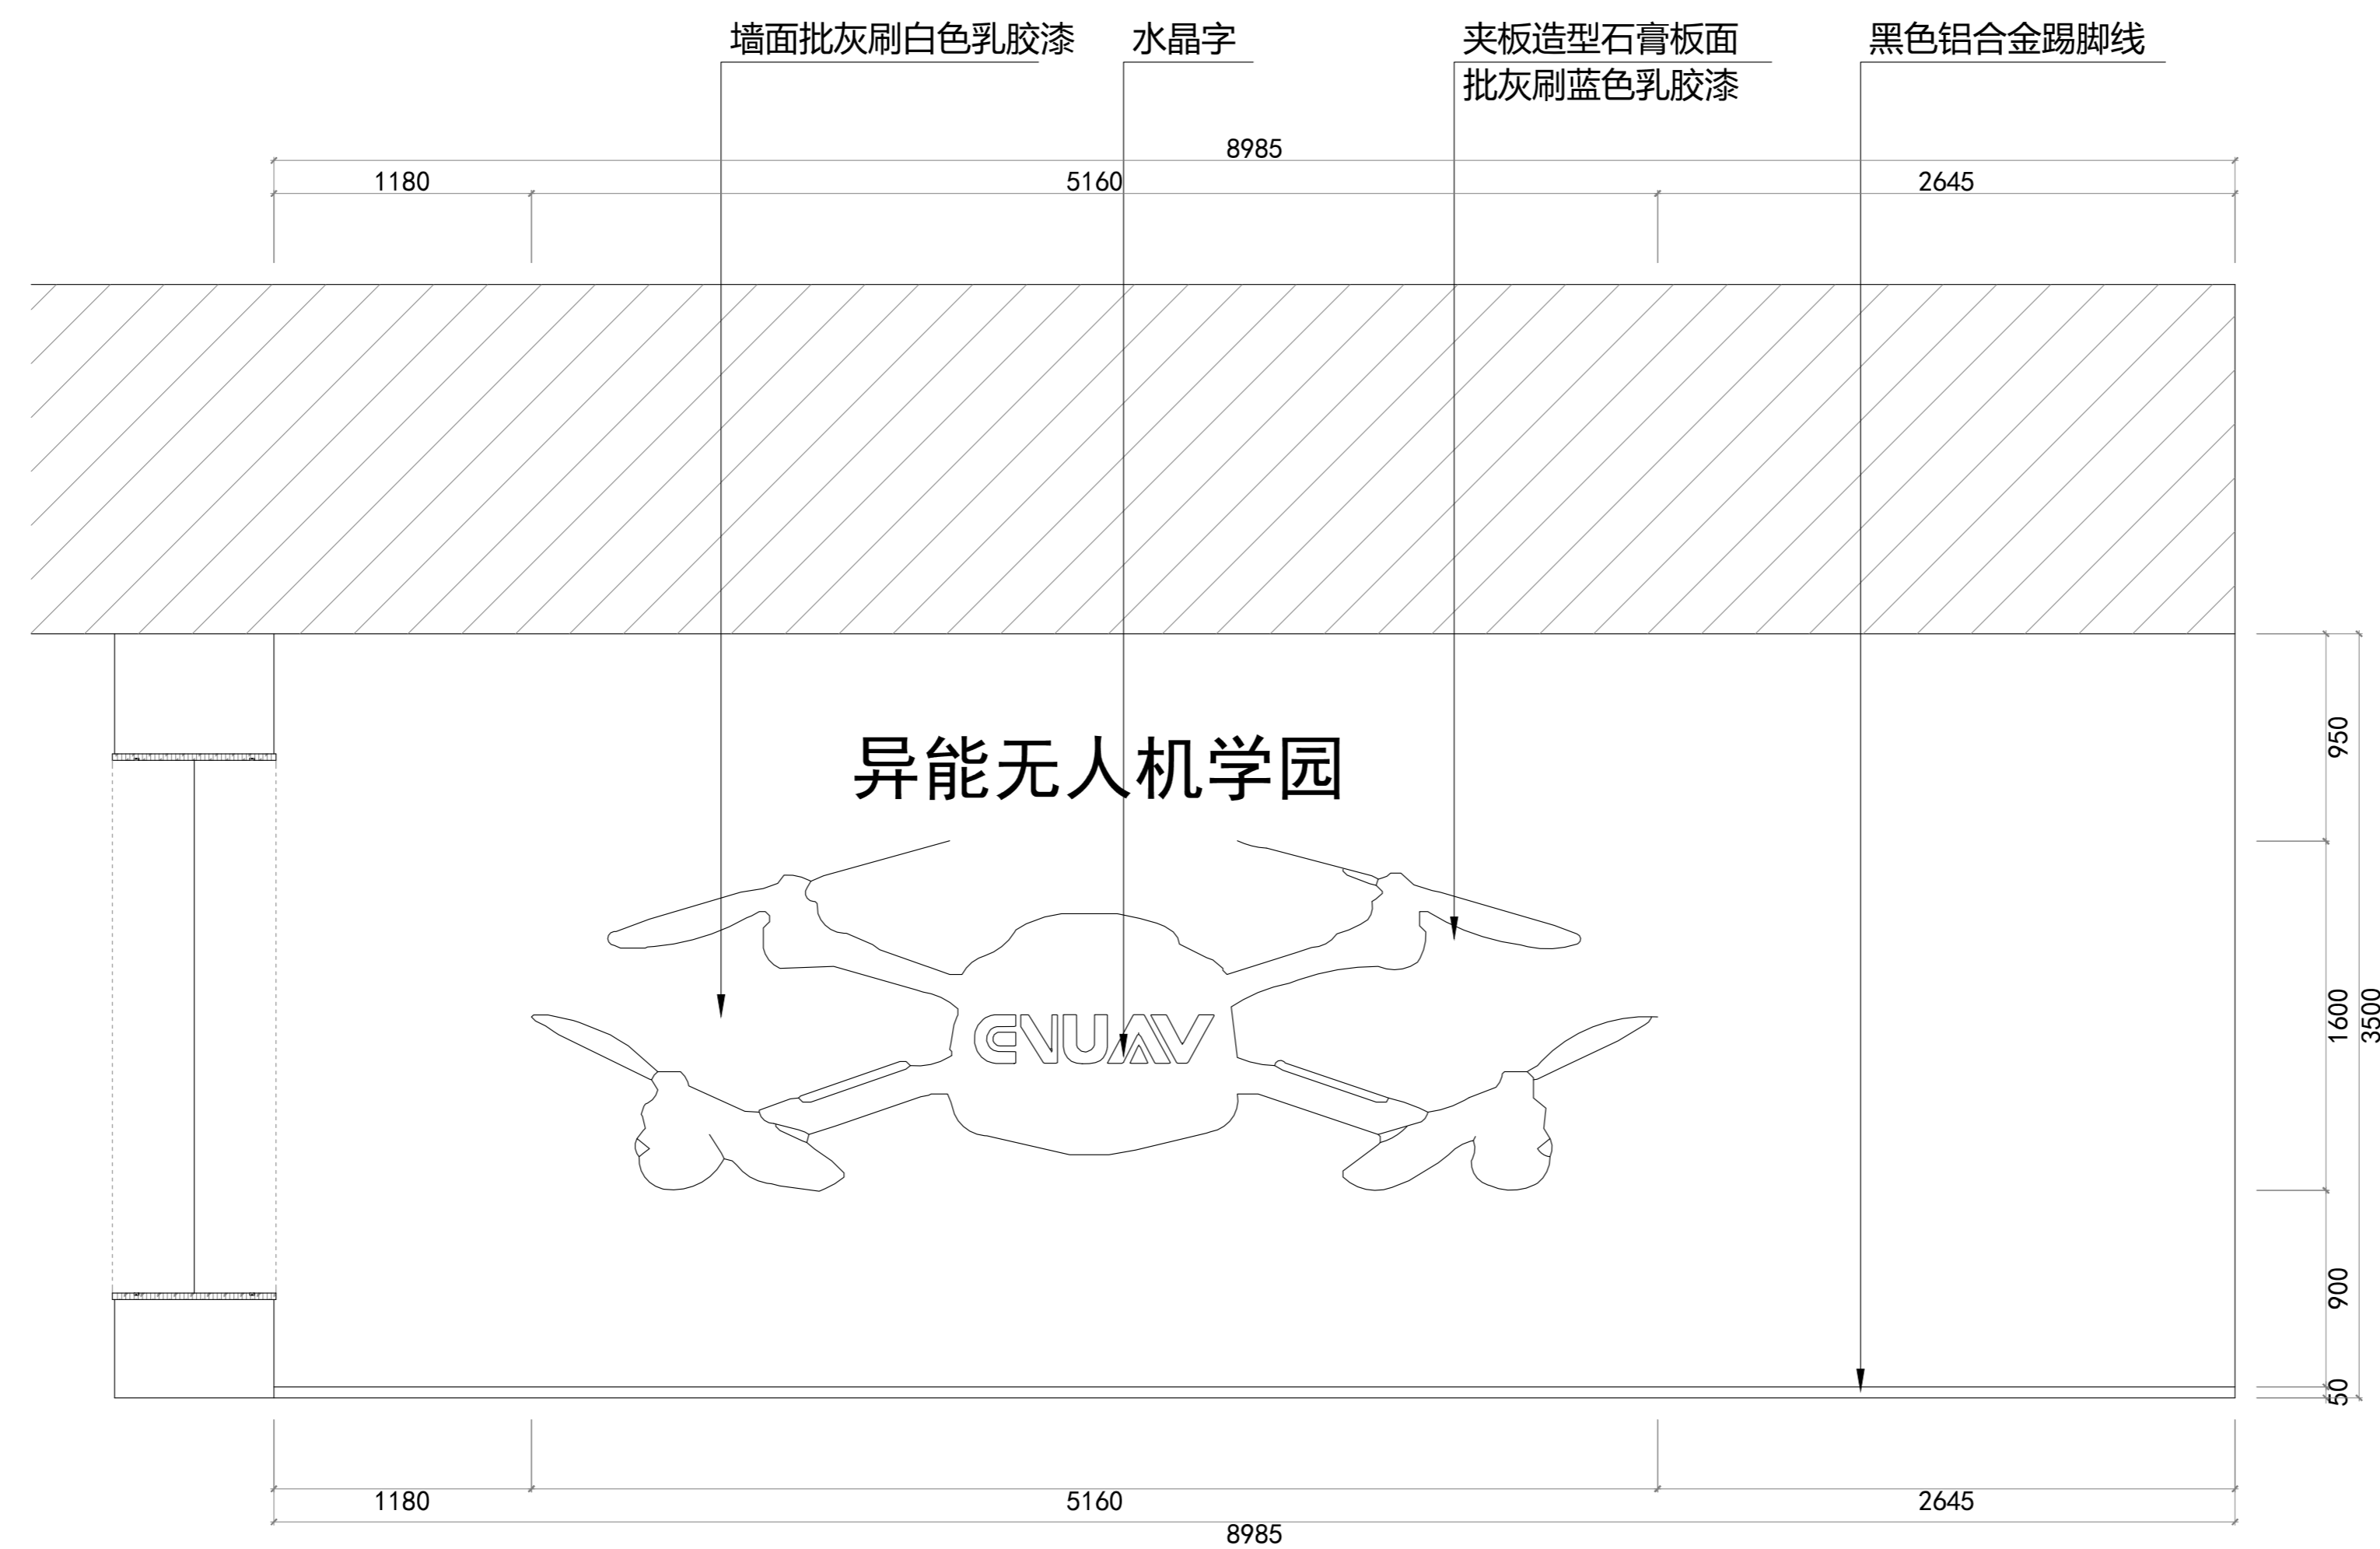

剖面尺寸图

此图版权归本公司，所有尺寸以所注数字为准，并在工地核实无误，使用本图时应参阅其它有关图纸，说明和合同，如有矛盾即通知本公司，设计图若有变更应按下栏最后修改记录或变更通知单为准。
This drawings & design are copyright and portion may be reproduced without the written permission of the architect. All written dimensions or grid line measurements to existing work to be checked on site. This drawings is to be read in conjunction with the specification & conditions of contract, and with general architectural plans, structural plans and all immediately of any discrepancy found the drawings not showing the last revisions above are to be cancelled.

工程名称
PROJECT NAME

图纸名称
DRAWING TITLE

异能无人机学园
I立面图

次数	NO	修改日期	REVISIONS
△			
△			
△			
△			

设计负责人
PROJECT DIRECTOR

设计
DESIGNED BY

审核
APPROVED BY

业主(甲方)
CLIENT




制图
DRAWN BY

比例
SCALE

图号
DRAWING NO

日期
DATE

L-10

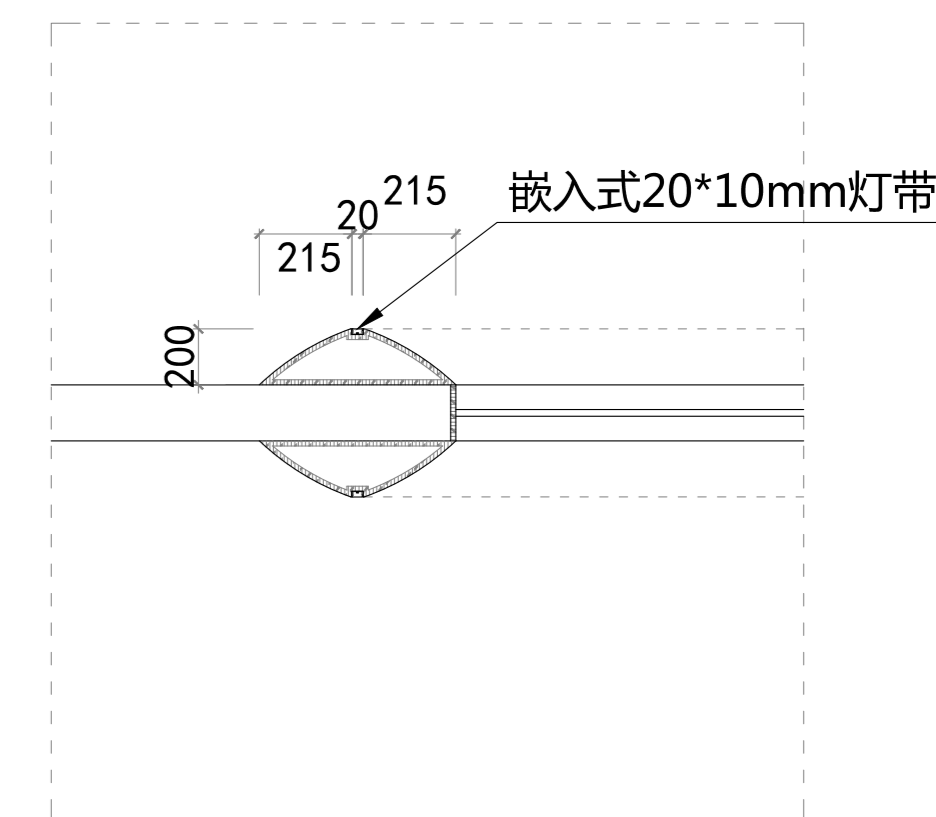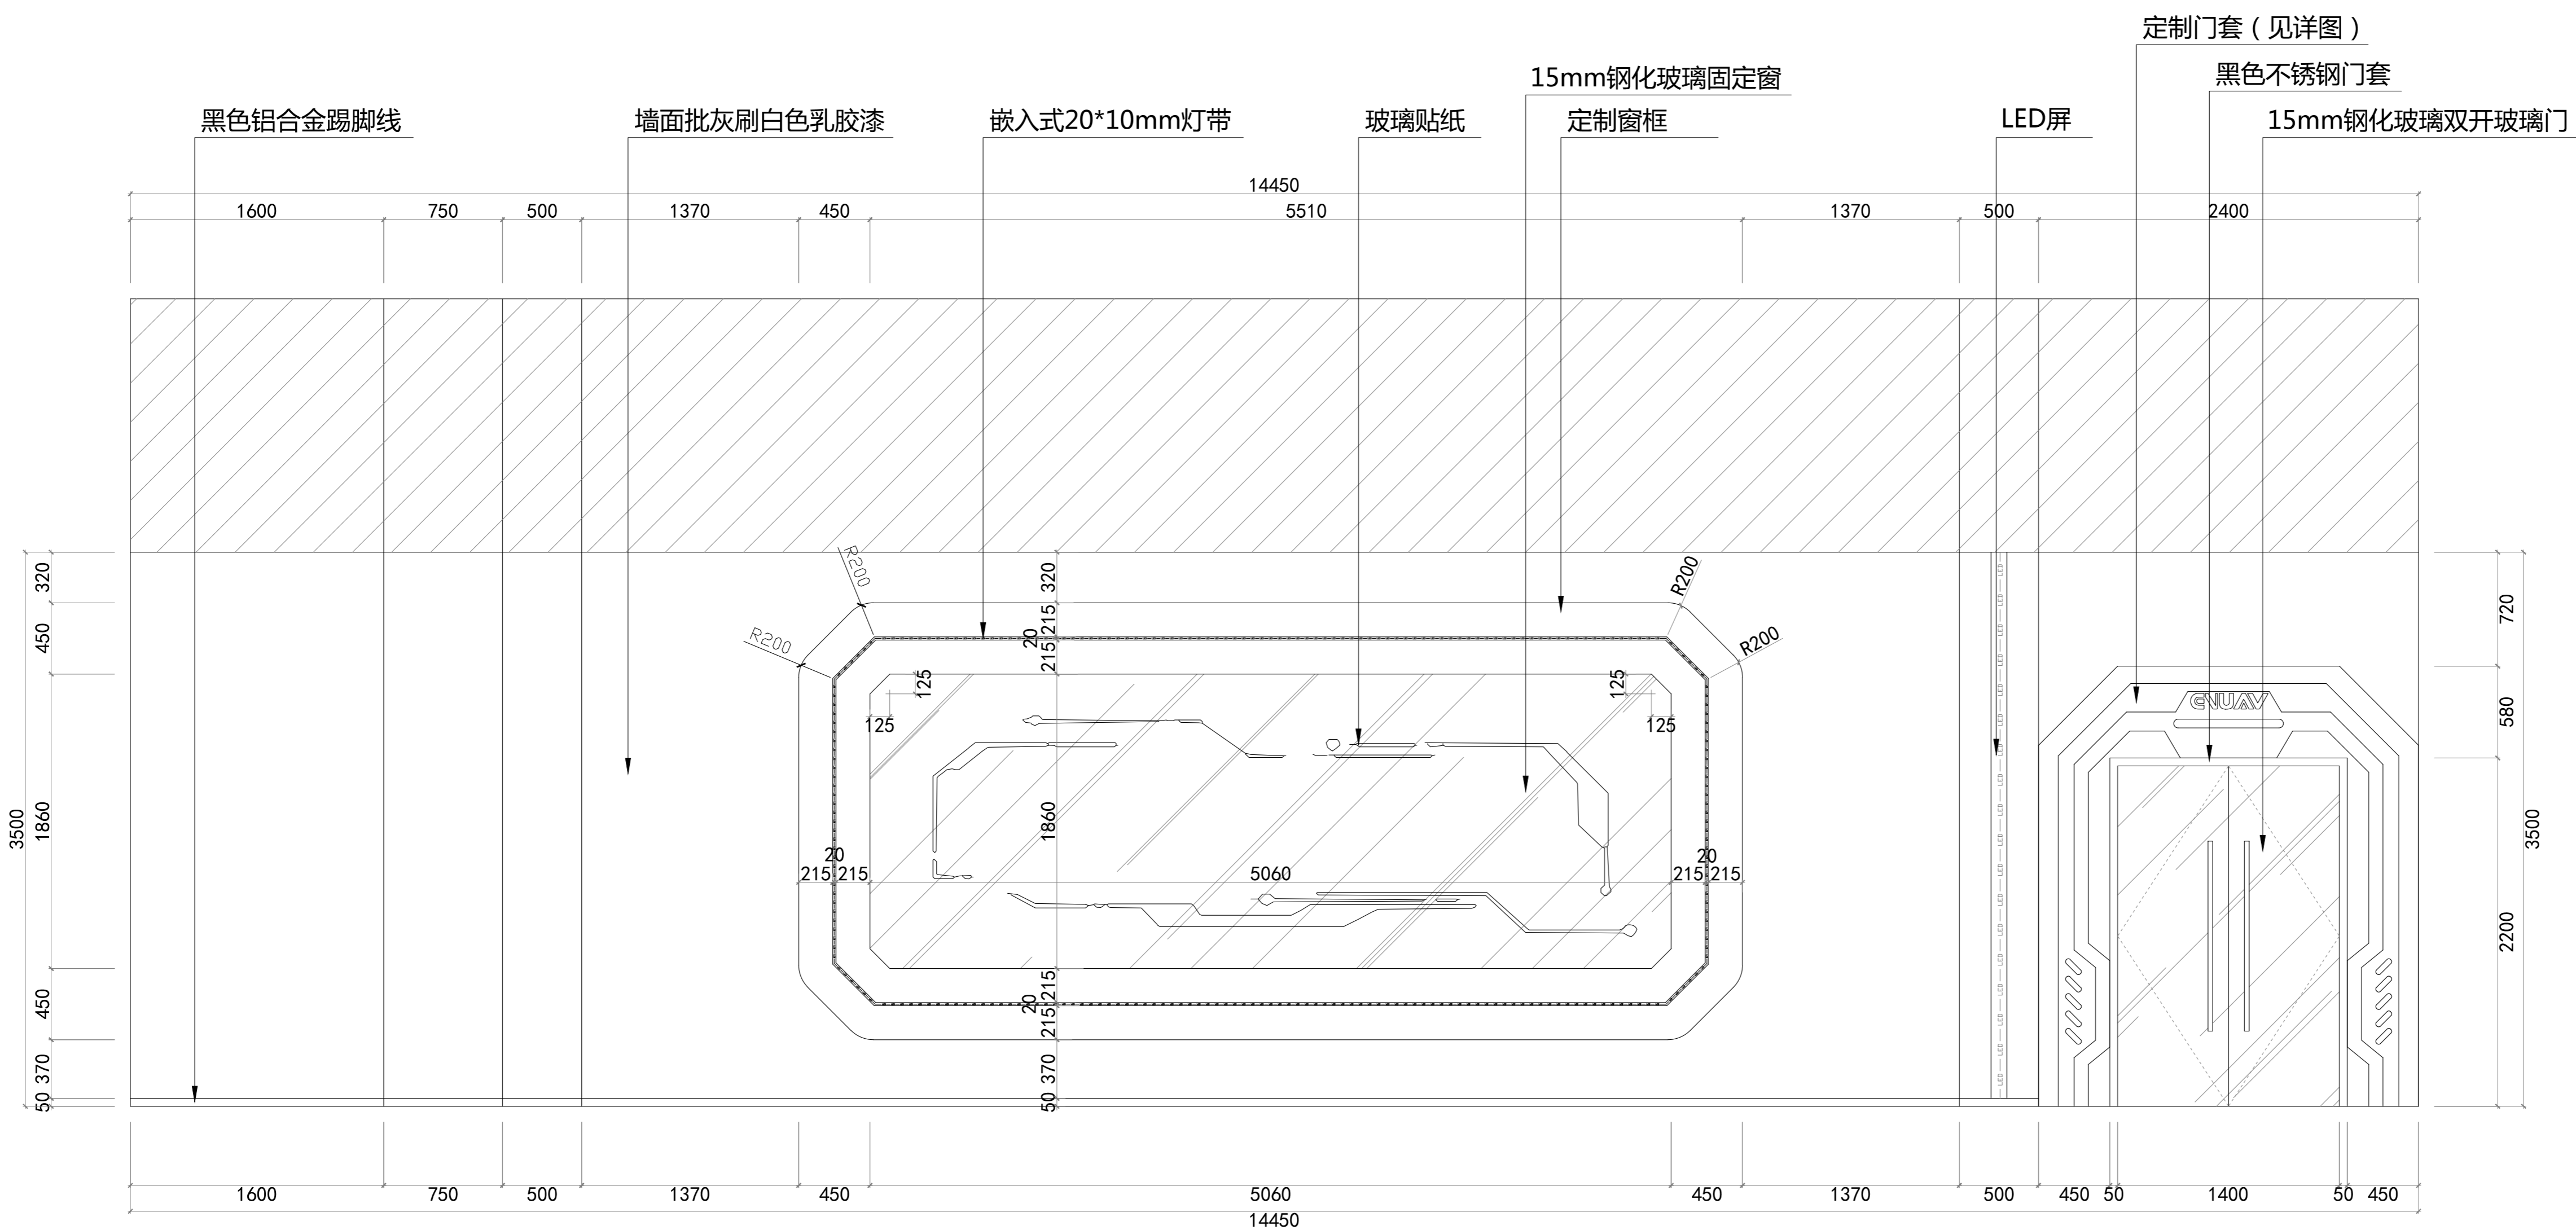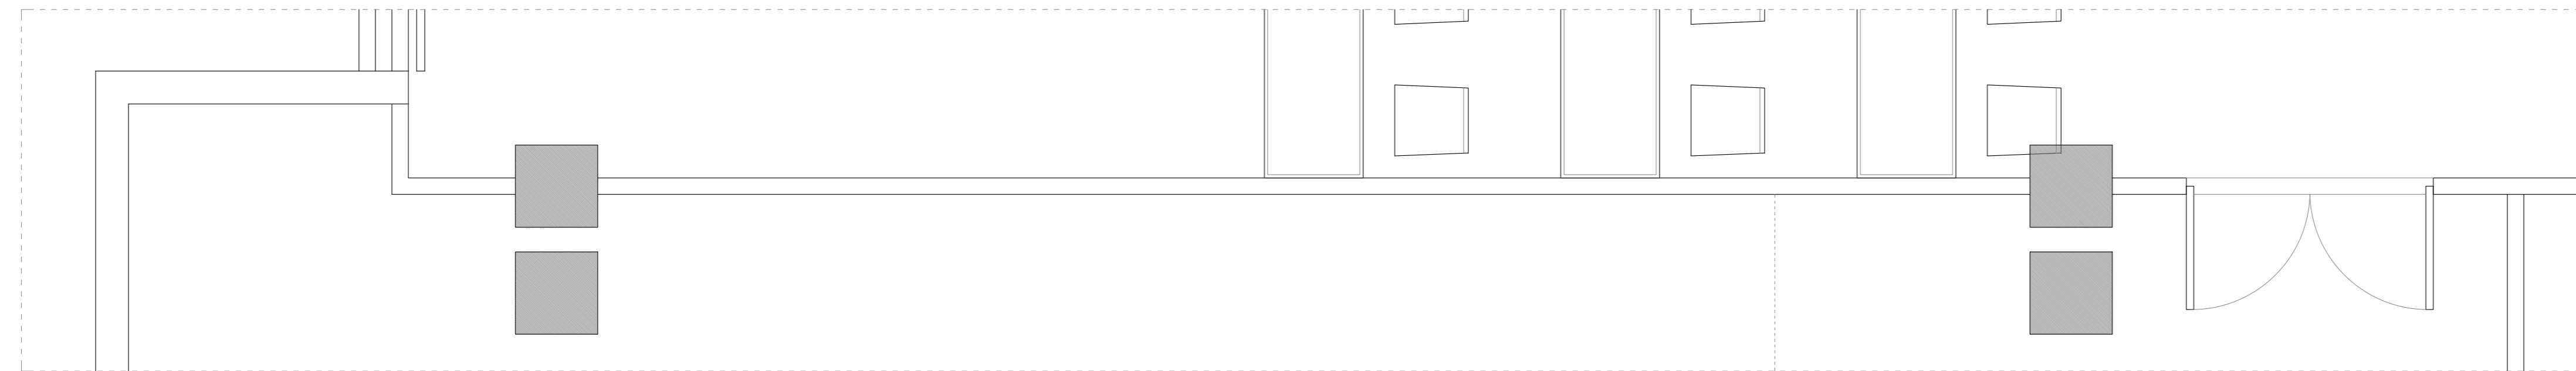

此图版权归本公司，所有尺寸以所注数字为准，并在工地核实无误，使用本图时应参阅其它有关图纸、说明和合同，如有矛盾即通知本公司，设计图若有变更应按下栏最后修改记录或变更通知单为准。
This drawings & design are copyright and portion may be reproduced without the written permission of the architect. All written dimensions or grid line measurements to existing work to be checked on site. This drawings is to be read in conjunction with the specification & conditions of contract, and with general architectural plans, structural plans and all immediately of any discrepancy found the drawings not showing the last revisions above are to be cancelled.

工程名称
PROJECT NAME
图纸名称
DRAWING TITLE



异能无人机学园
J立面图

次数	NO	修改日期	REVISIONS
△			
△			
△			
△			

设计负责人
PROJECT DIRECTOR
设计
DESIGNED BY
审核
APPROVED BY

业主(甲方)
CLIENT
制图
DRAWN BY
比例
SCALE

图号
DRAWING NO
日期
DATE
L-11

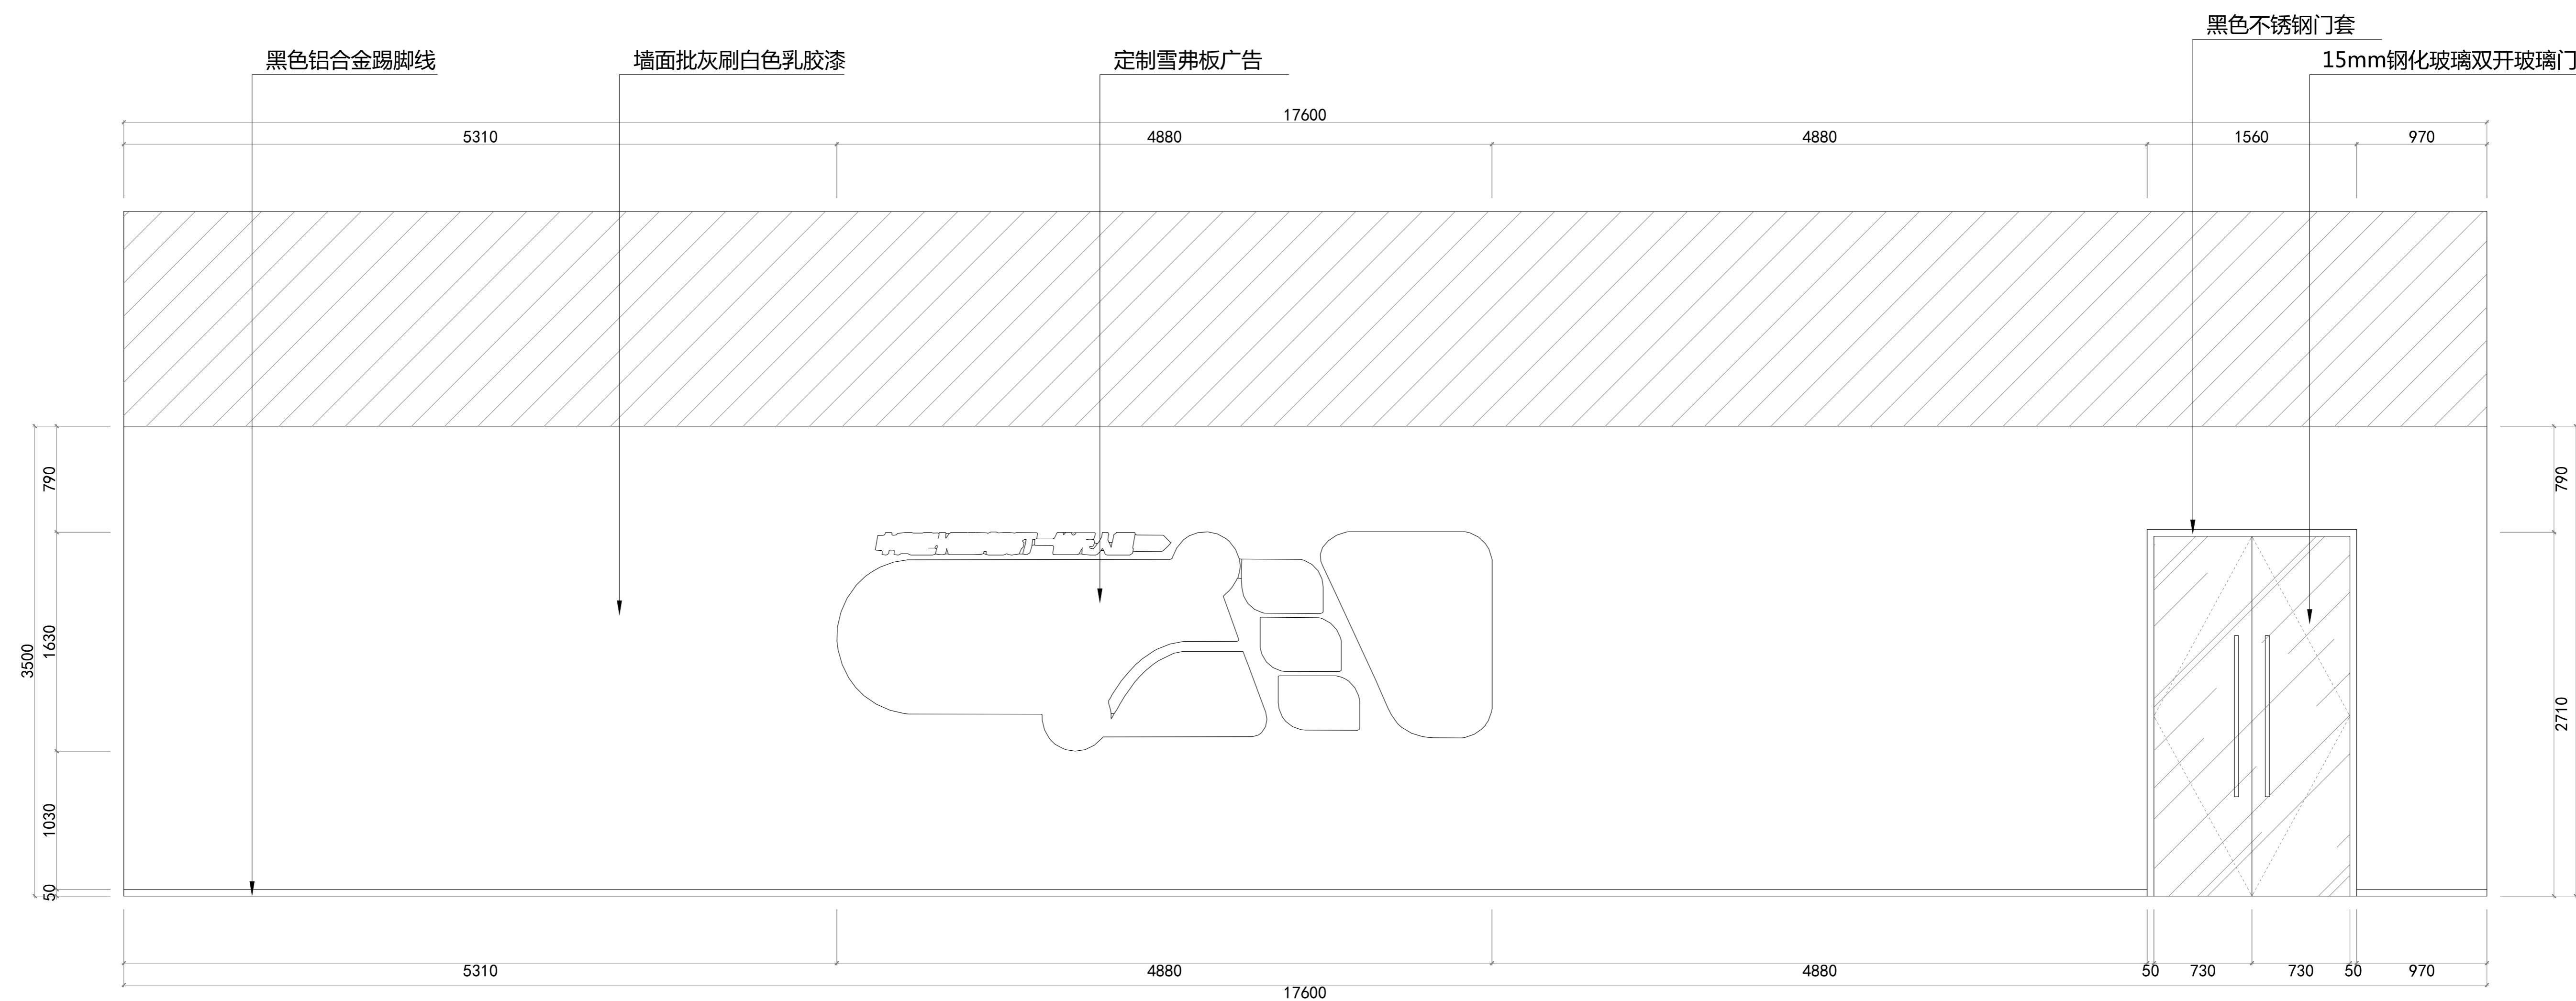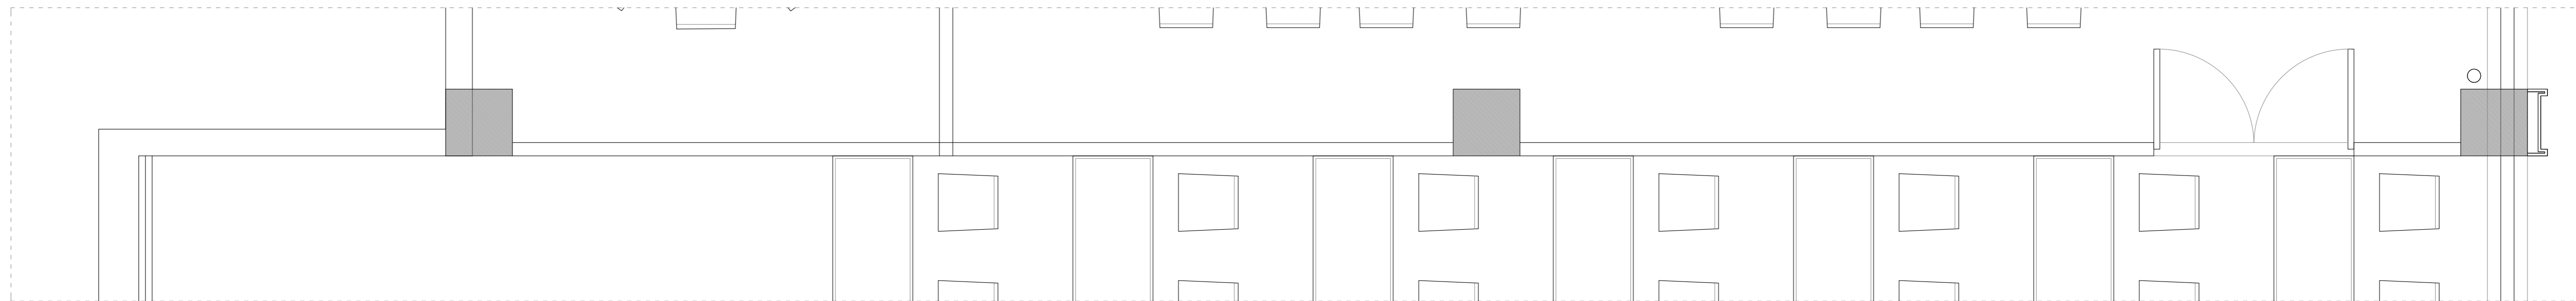

此图版权归本公司，所有尺寸以所注数字为准，并在工地核实无误，使用本图时应参阅其它有关图纸、说明和合同，如有矛盾即通知本公司，设计图若有变更应按下列最后修改记录或变更通知单为准。
 This drawings & design are copyright and portion may be reproduced without the written permission of the architect. All written dimensions or grid line measurements to existing work to be checked on site. This drawings is to be read in conjunction with the specification & conditions of contract, and with general architectural plans, structural plans and all immediately of any discrepancy found the drawings not showing the last revisions above are to be cancelled.

工程名称
 PROJECT NAME
 图纸名称
 DRAWING TITLE

异能无人机学园
 K立面图



次数	NO	修改日期	REVISIONS
△			
△			
△			
△			

设计负责人
 PROJECT DIRECTOR
 设计
 DESIGNED BY
 审核
 APPROVED BY

业主(甲方)
 CLIENT
 制图
 DRAWN BY
 比例
 SCALE

图号
 DRAWING NO
 日期
 DATE

L-12

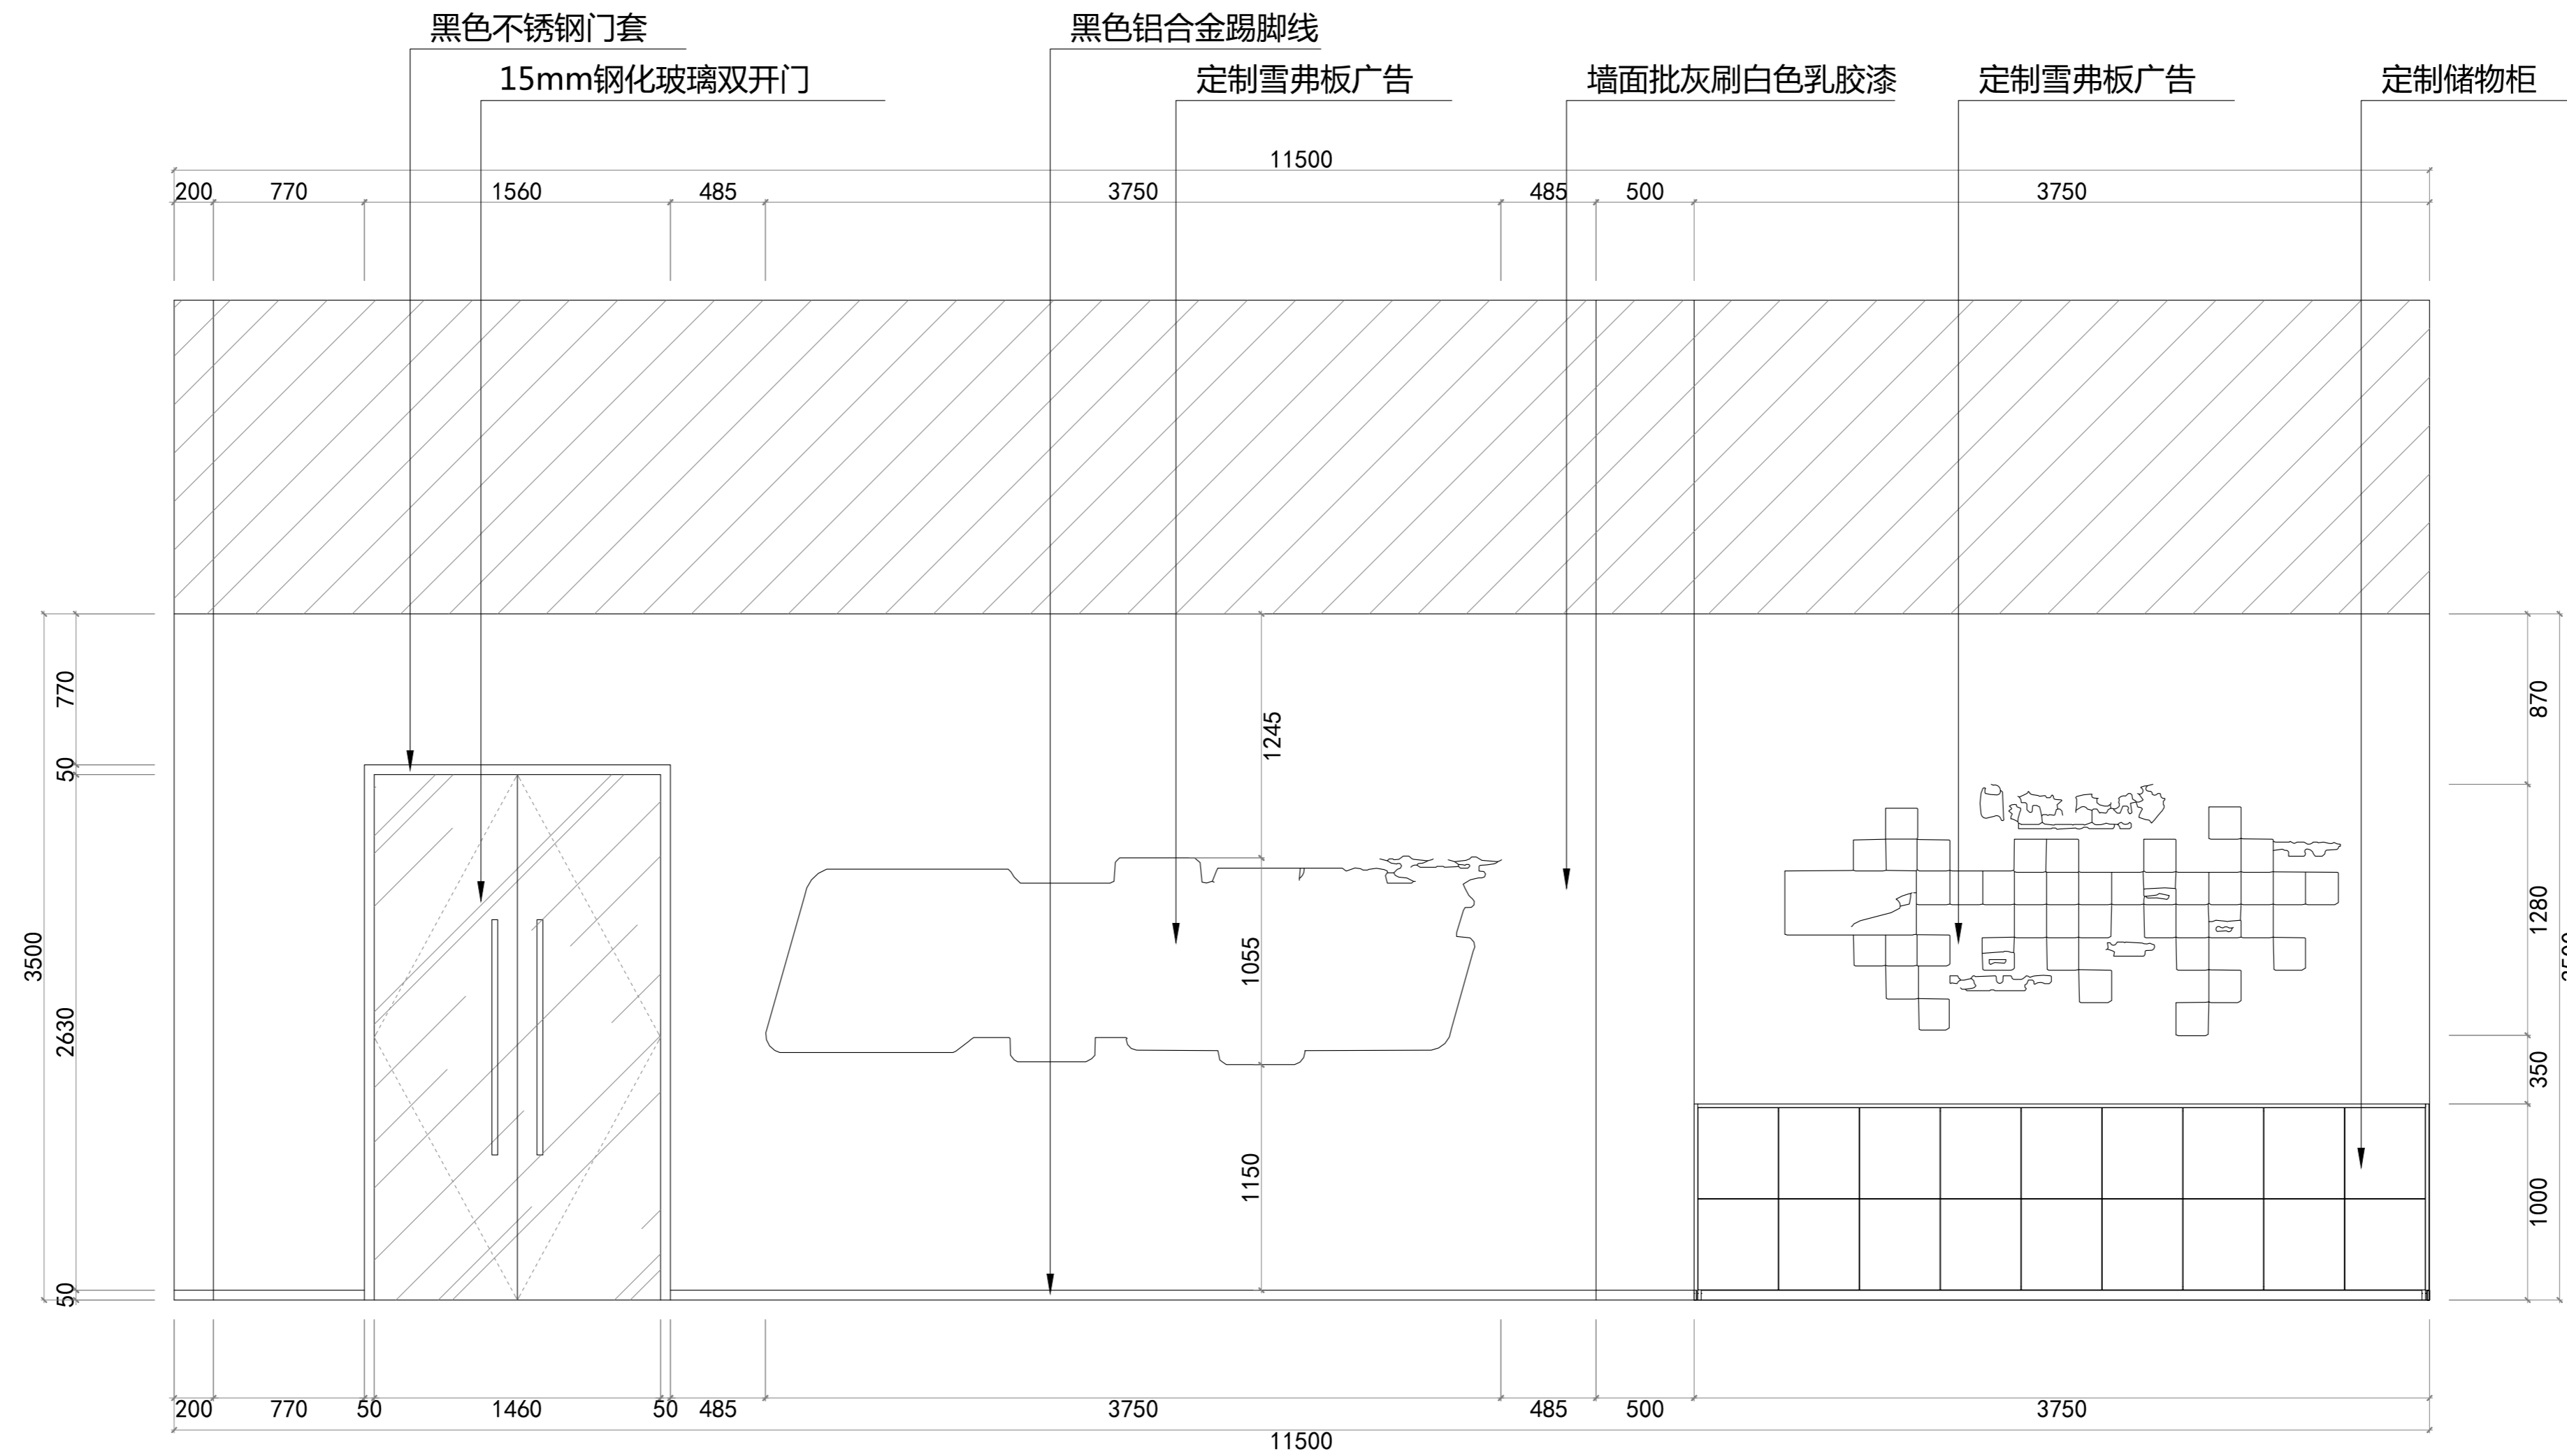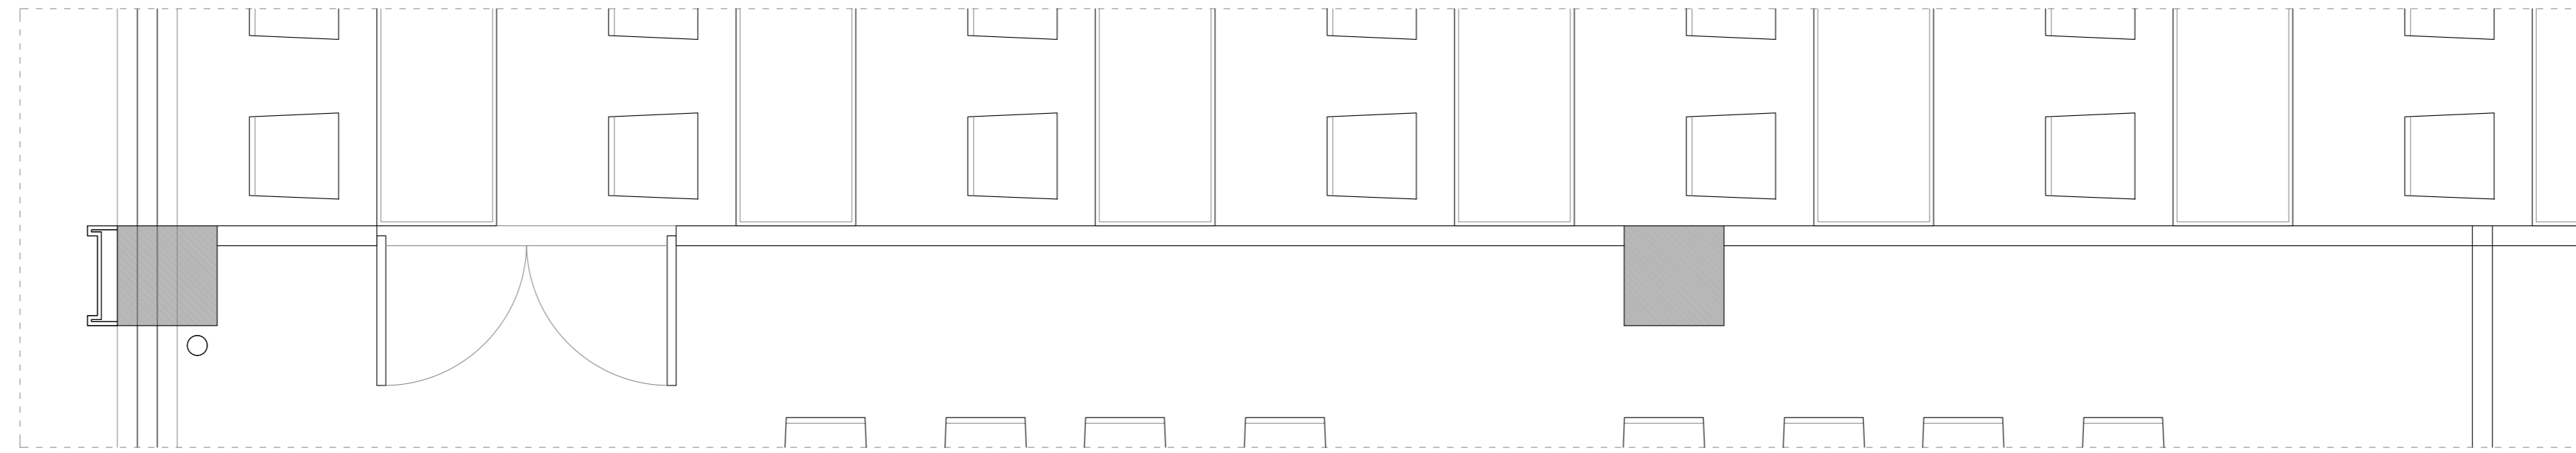

此图版权归本公司，所有尺寸以所注数字为准，并在工地核实无误，使用本图时应参阅其它有关图纸，说明和合同，如有矛盾即通知本公司，设计图若有变更应按下栏最后修改记录或变更通知单为准。
 This drawings & design are copyright and portion may be reproduced without the written permission of the architect. All written dimensions or grid line measurements to existing work to be checked on site. This drawings is to be read in conjunction with the specification & conditions of contract, and with general architectural plans, structural plans and all immediately of any discrepancy found the drawings not showing the last revisions above are to be cancelled.

工程名称
PROJECT NAME

异能无人机学园

图纸名称
DRAWING TITLE

L立面图

次数	NO	修改日期	REVISIONS
△			
△			
△			
△			

设计负责人
PROJECT DIRECTOR

设计
DESIGNED BY

审核
APPROVED BY

业主(甲方)
CLIENT


制图
DRAWN BY

比例
SCALE

图号
DRAWING NO

日期
DATE

L-13

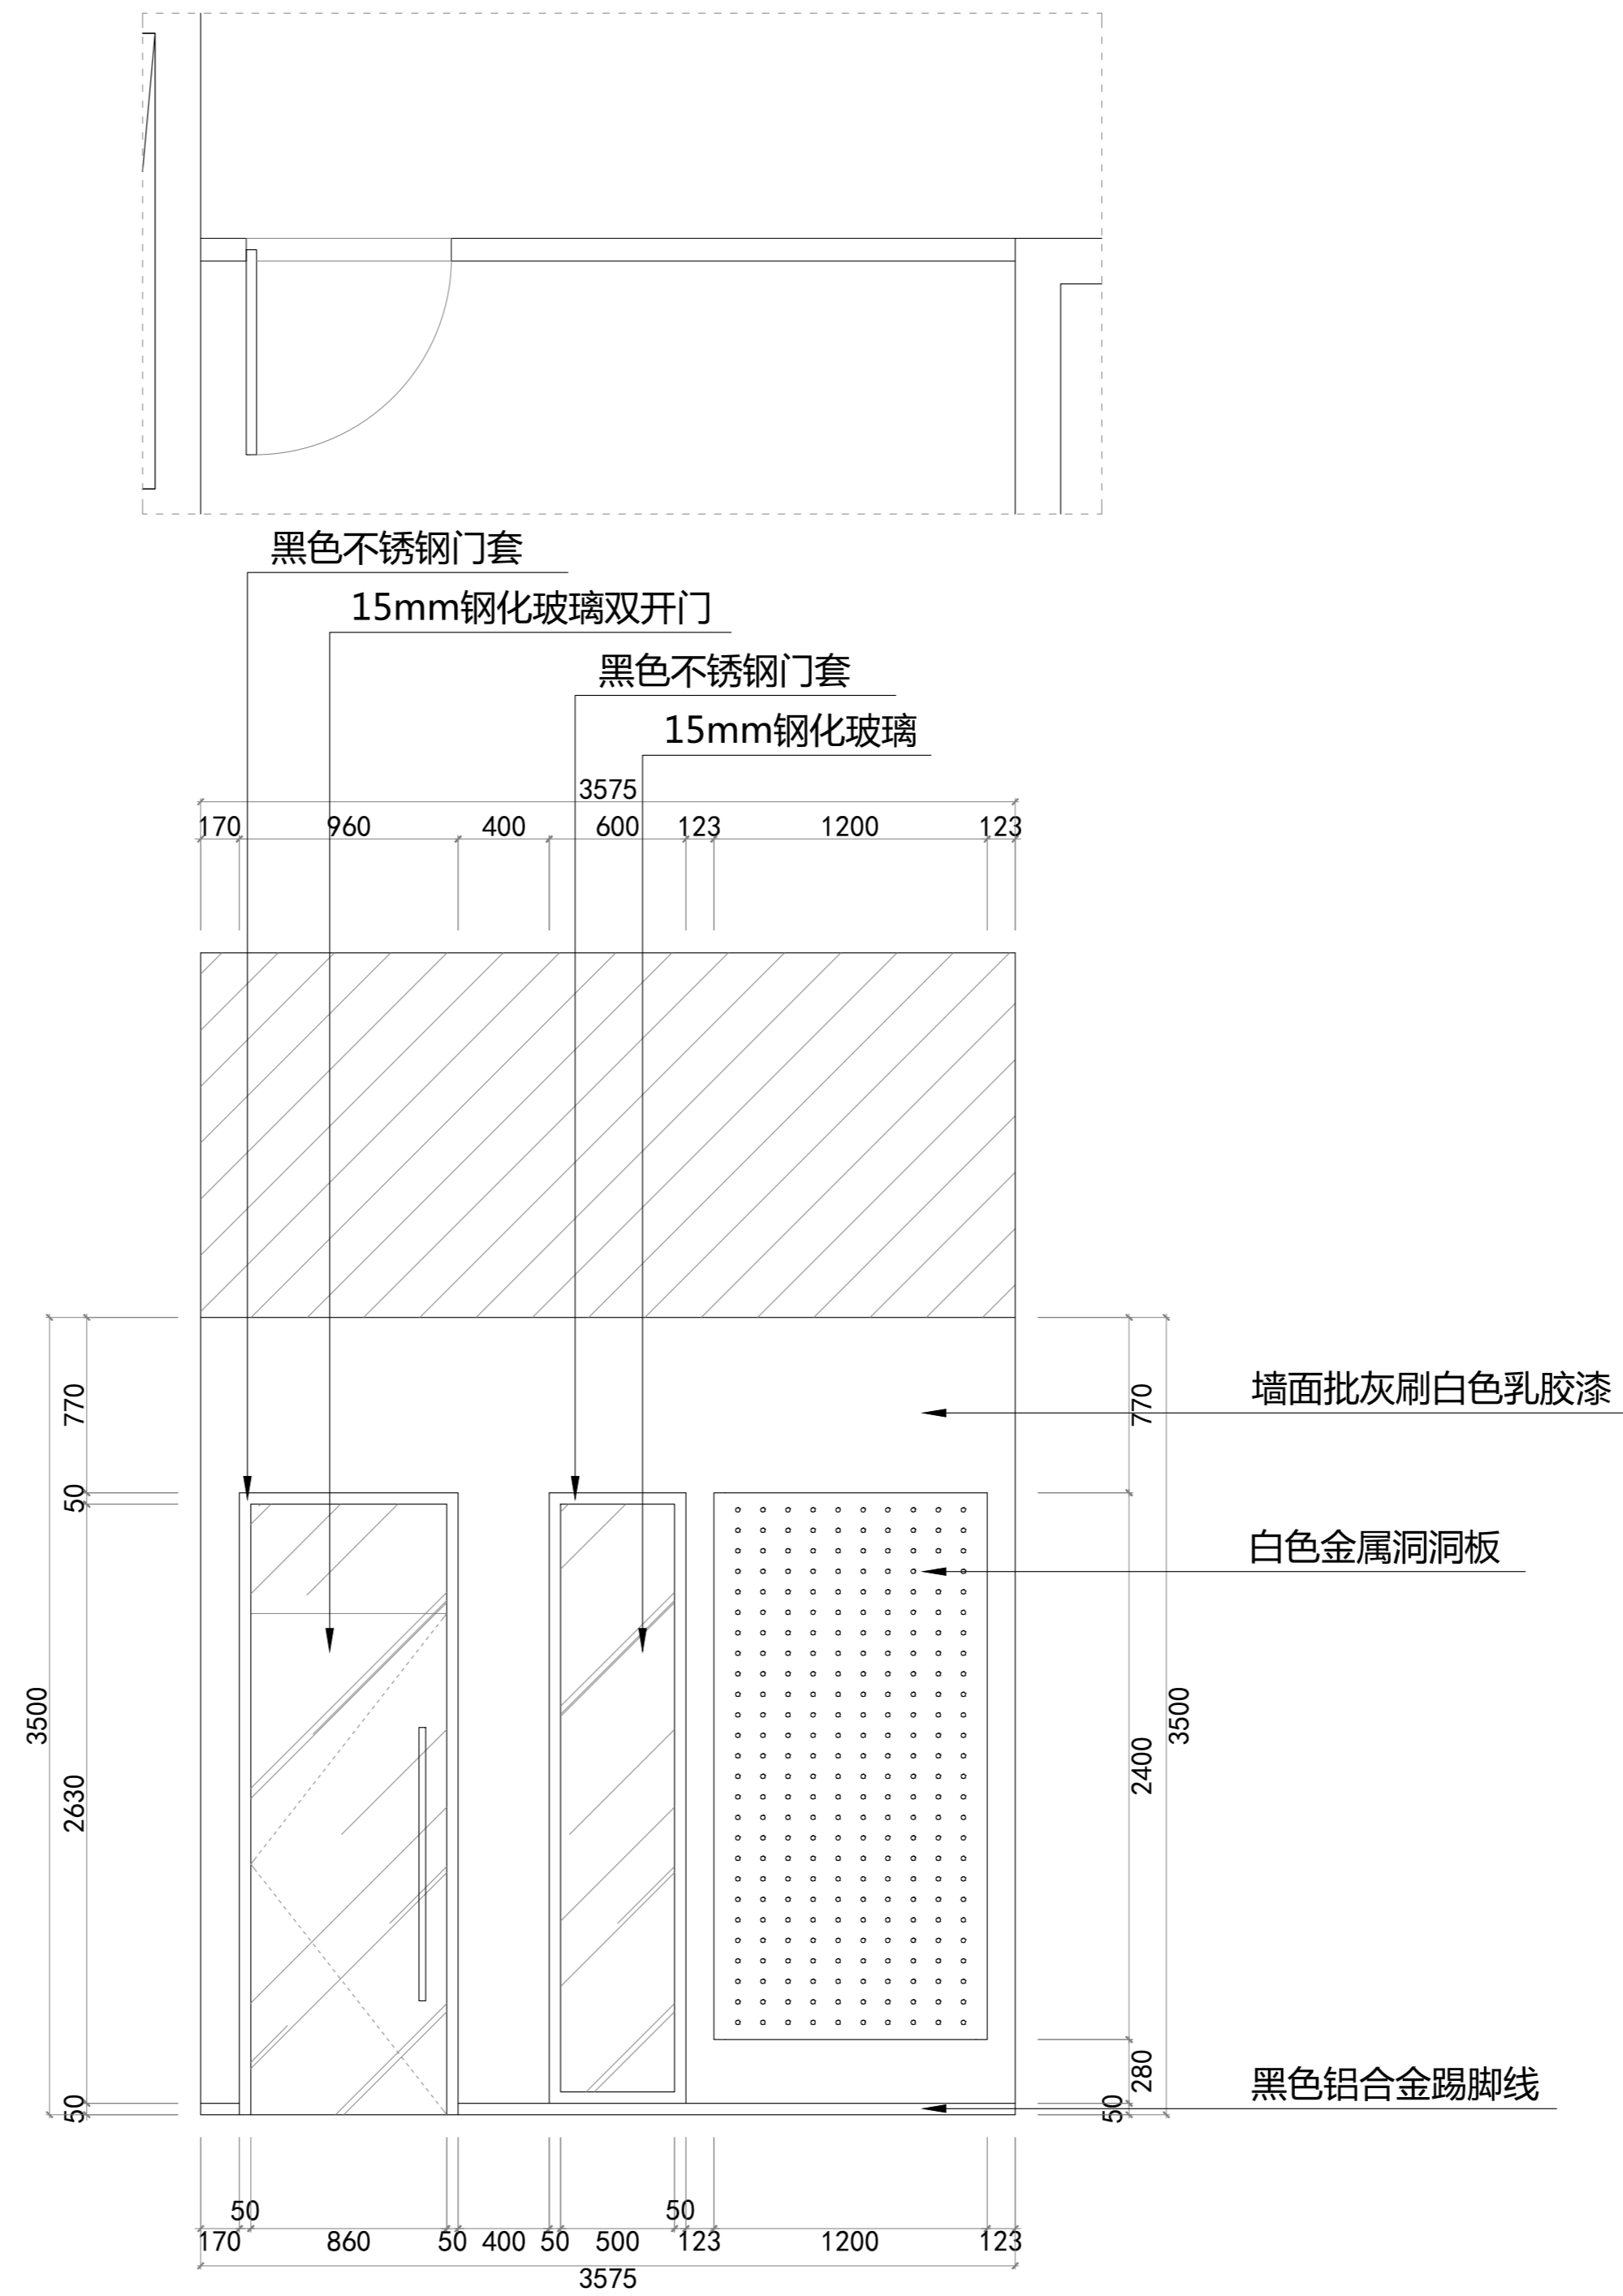

此图版权归本公司，所有尺寸以所注数字为准，并在工地核实无误，使用本图时应参阅其它有关图纸，说明和合同，如有矛盾即通知本公司，设计图若有变更应按下栏最后修改记录或变更通知单为准。

This drawings & design are copyright and portion may be reproduced without the written permission of the architect. All written dimensions or grid line measurements to existing work to be checked on site. This drawings is to be read in conjunction with the specification & conditions of contract, and with general architectural plans, structural plans and all immediately of any discrepancy found the drawings not showing the last revisions above are to be cancelled.

工程名称
PROJECT NAME

图纸名称
DRAWING TITLE

异能无人机学园
M立面图

次数	NO	修改日期	REVISIONS
△			
△			
△			
△			

设计负责人
PROJECT DIRECTOR

设计
DESIGNED BY

审核
APPROVED BY

业主(甲方)
CLIENT



制图
DRAWN BY

比例
SCALE

图号
DRAWING NO

日期
DATE

L-14

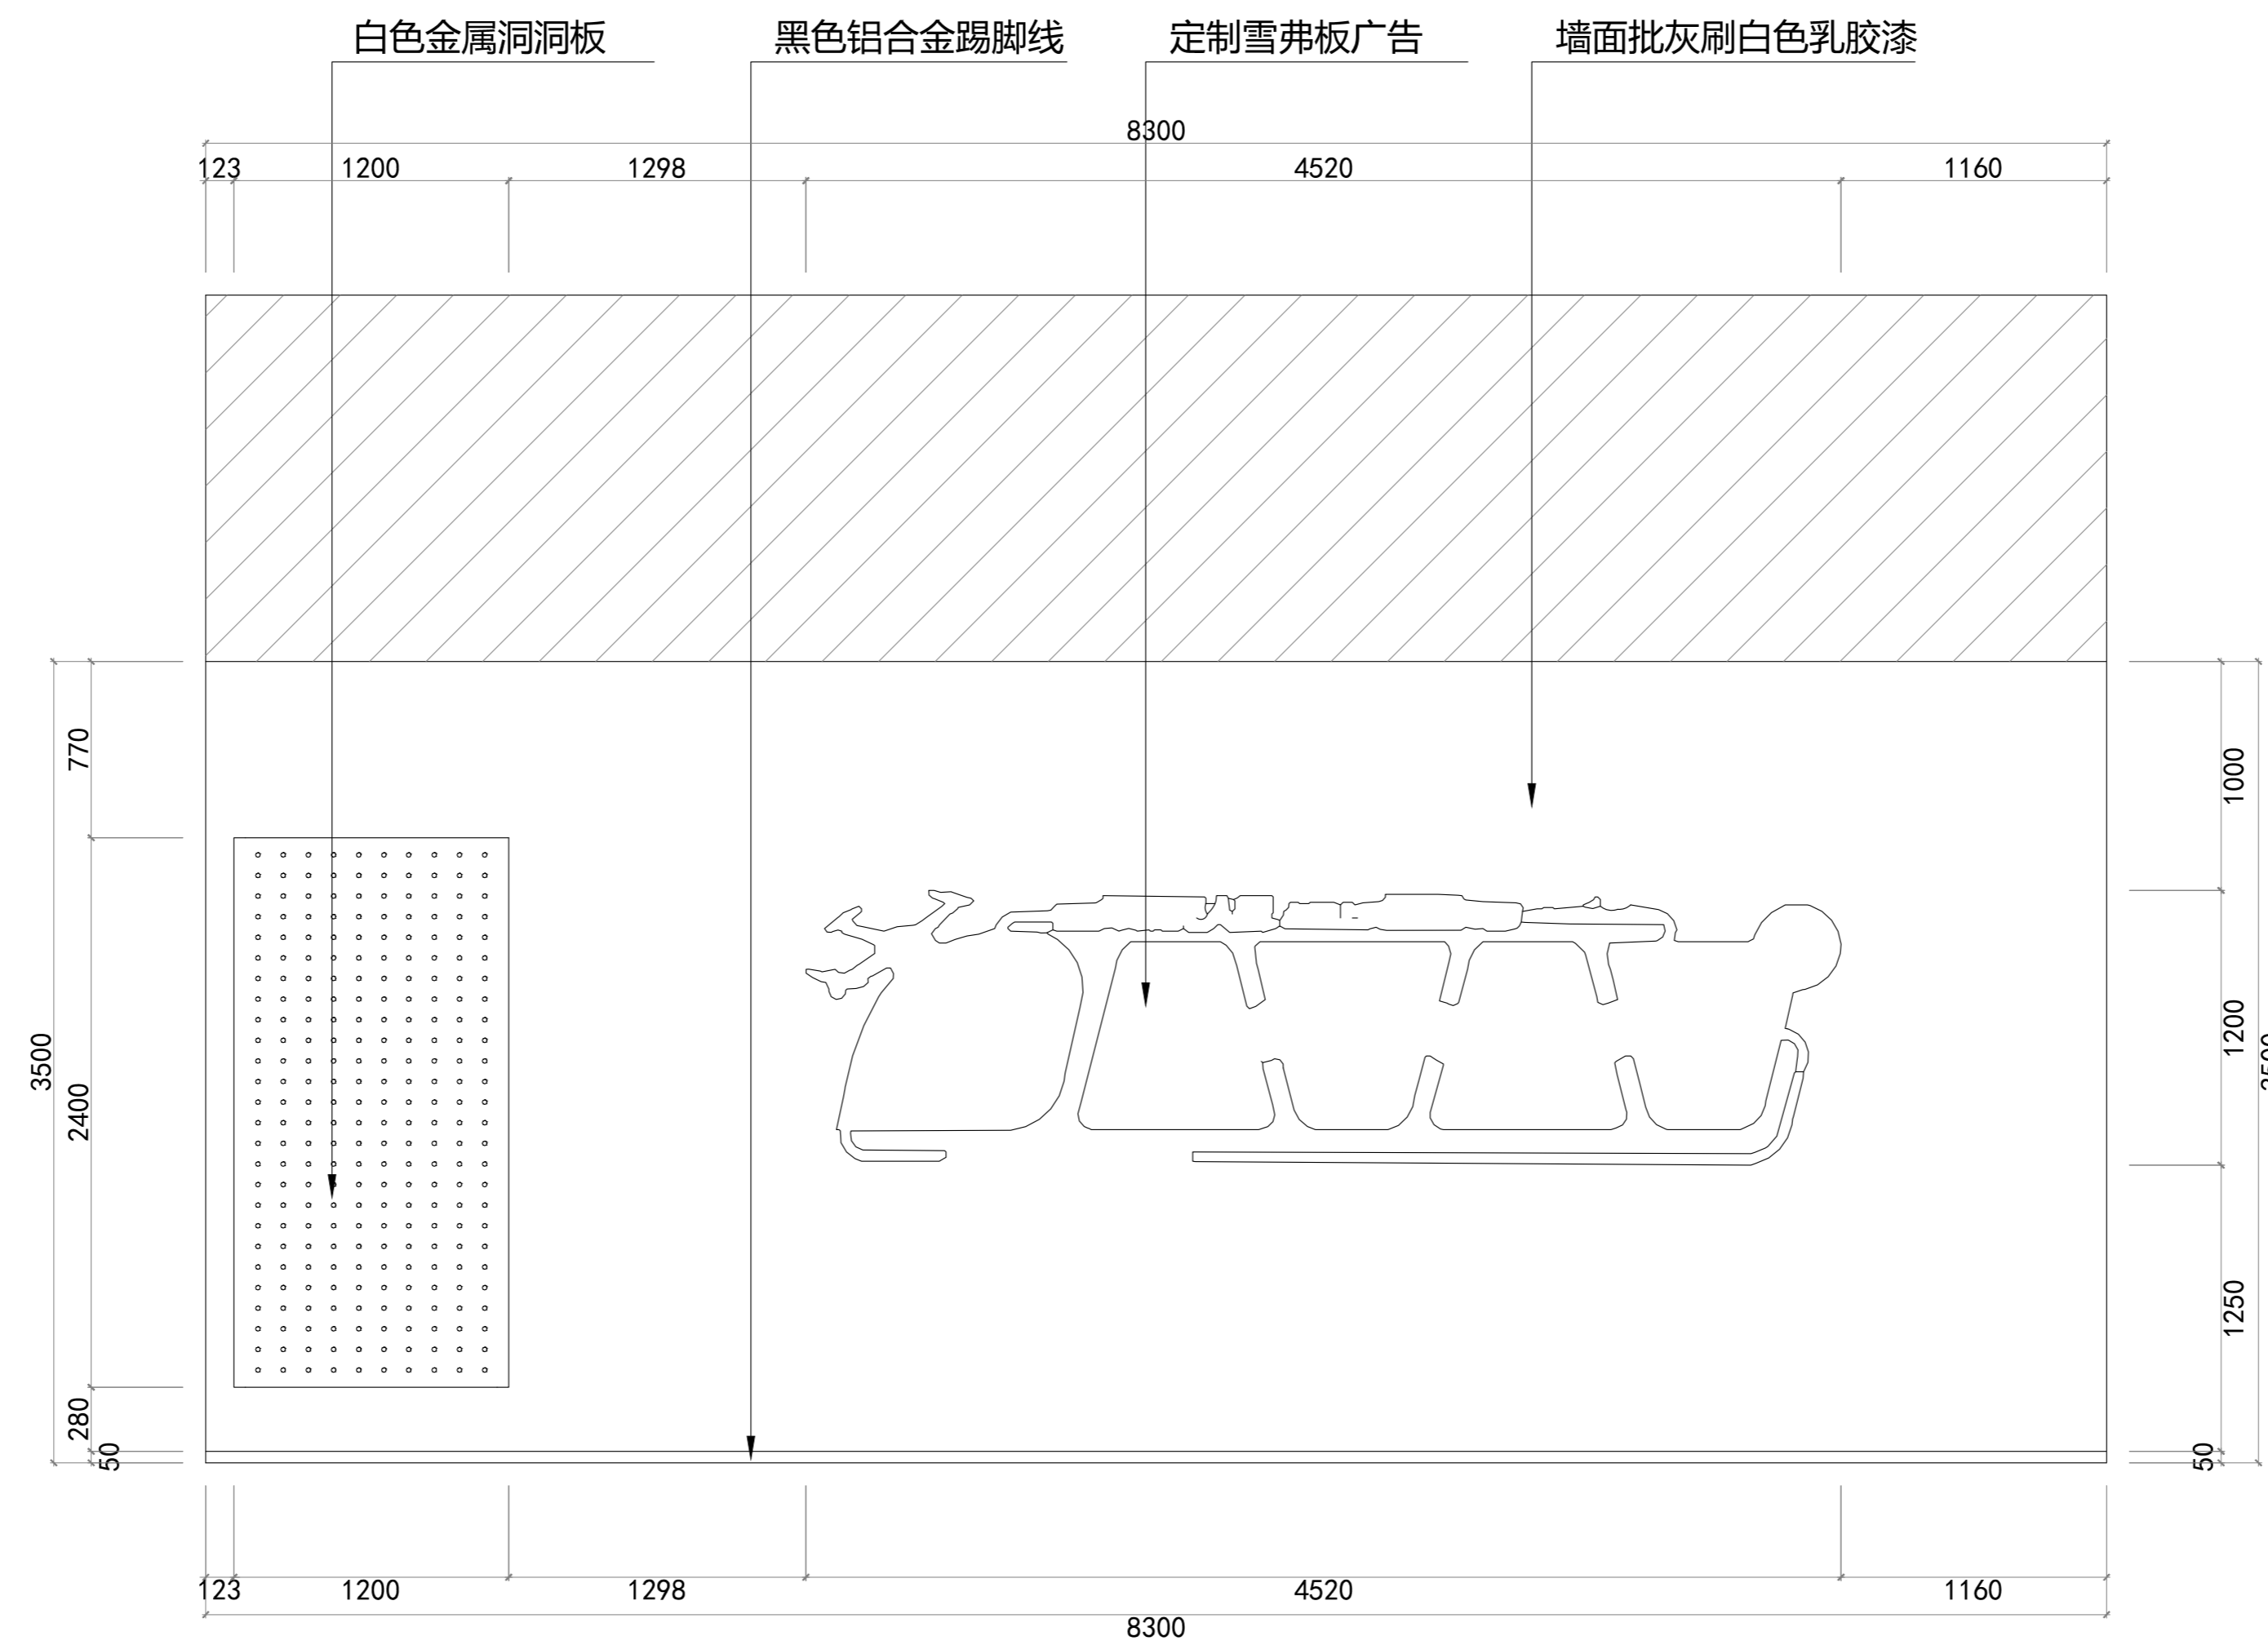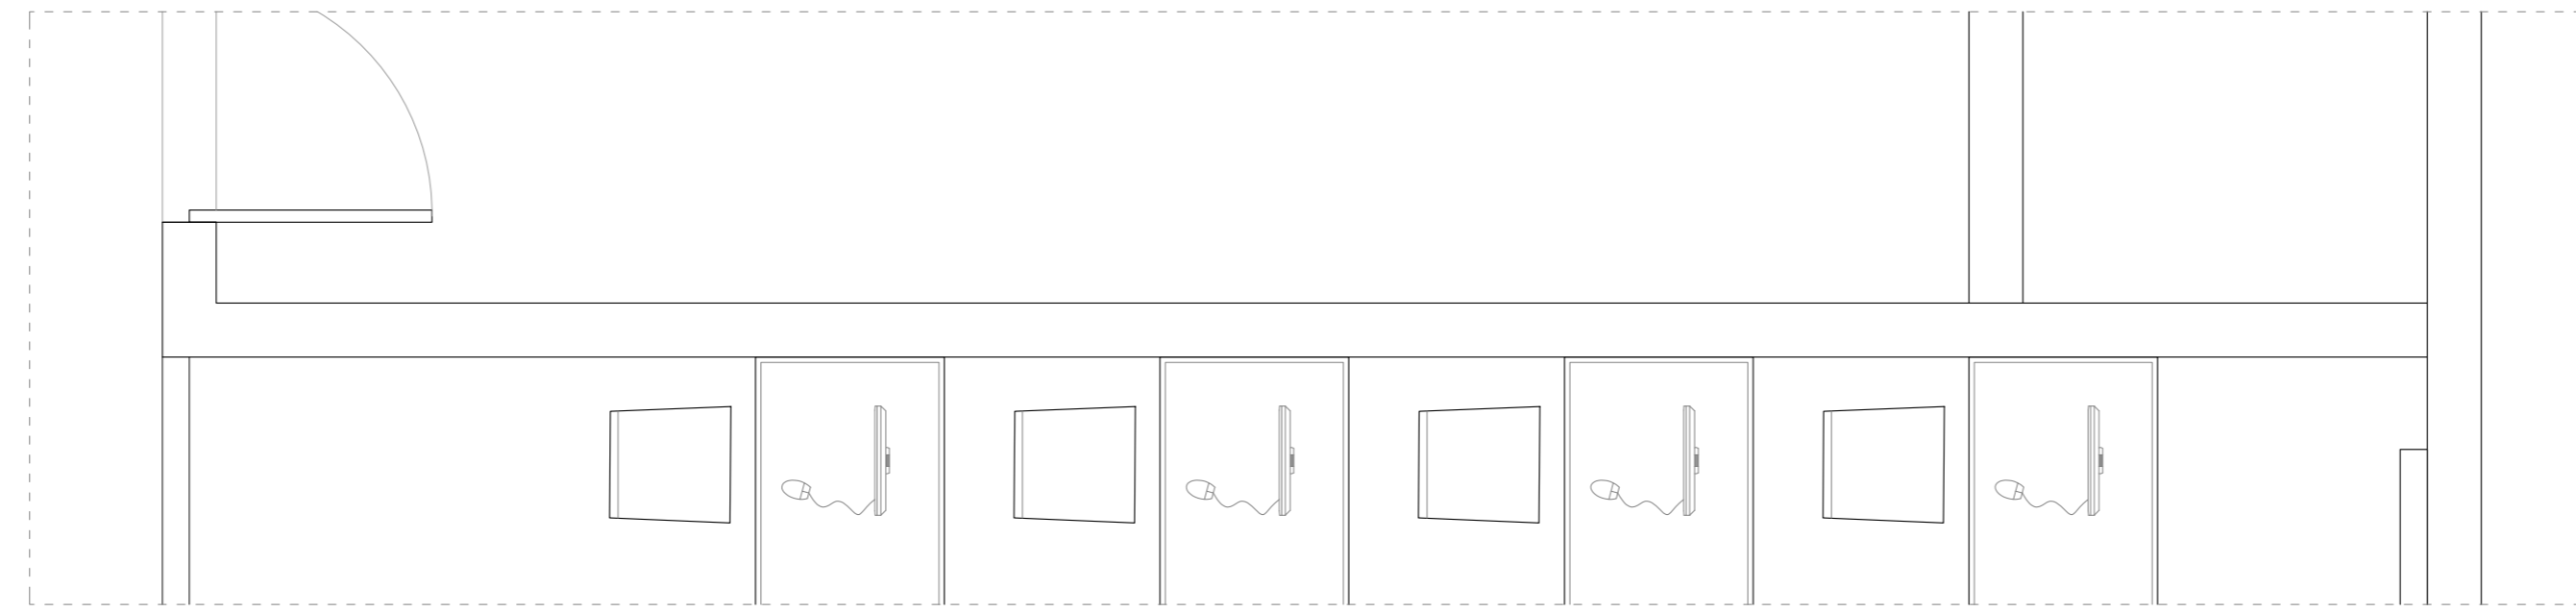

此图版权归本公司，所有尺寸以所注数字为准，并在工地核实无误，使用本图时应参阅其它有关图纸、说明和合同，如有矛盾即通知本公司，设计图若有变更应按下栏最后修改记录或变更通知单为准。
 This drawings & design are copyright and portion may be reproduced without the written permission of the architect. All written dimensions or grid line measurements to existing work to be checked on site. This drawings is to be read in conjunction with the specification & conditions of contract, and with general architectural plans, structural plans and all immediately of any discrepancy found the drawings not showing the last revisions above are to be cancelled.

工程名称
 PROJECT NAME

 图纸名称
 DRAWING TITLE

异能无人机学园

 N立面图

次数	NO	修改日期	REVISIONS
△			
△			
△			
△			

设计负责人
 PROJECT DIRECTOR

 设计
 DESIGNED BY

 审核
 APPROVED BY

业主(甲方)
 CLIENT



 制图
 DRAWN BY

 比例
 SCALE

图号
 DRAWING NO

 日期
 DATE

L-15

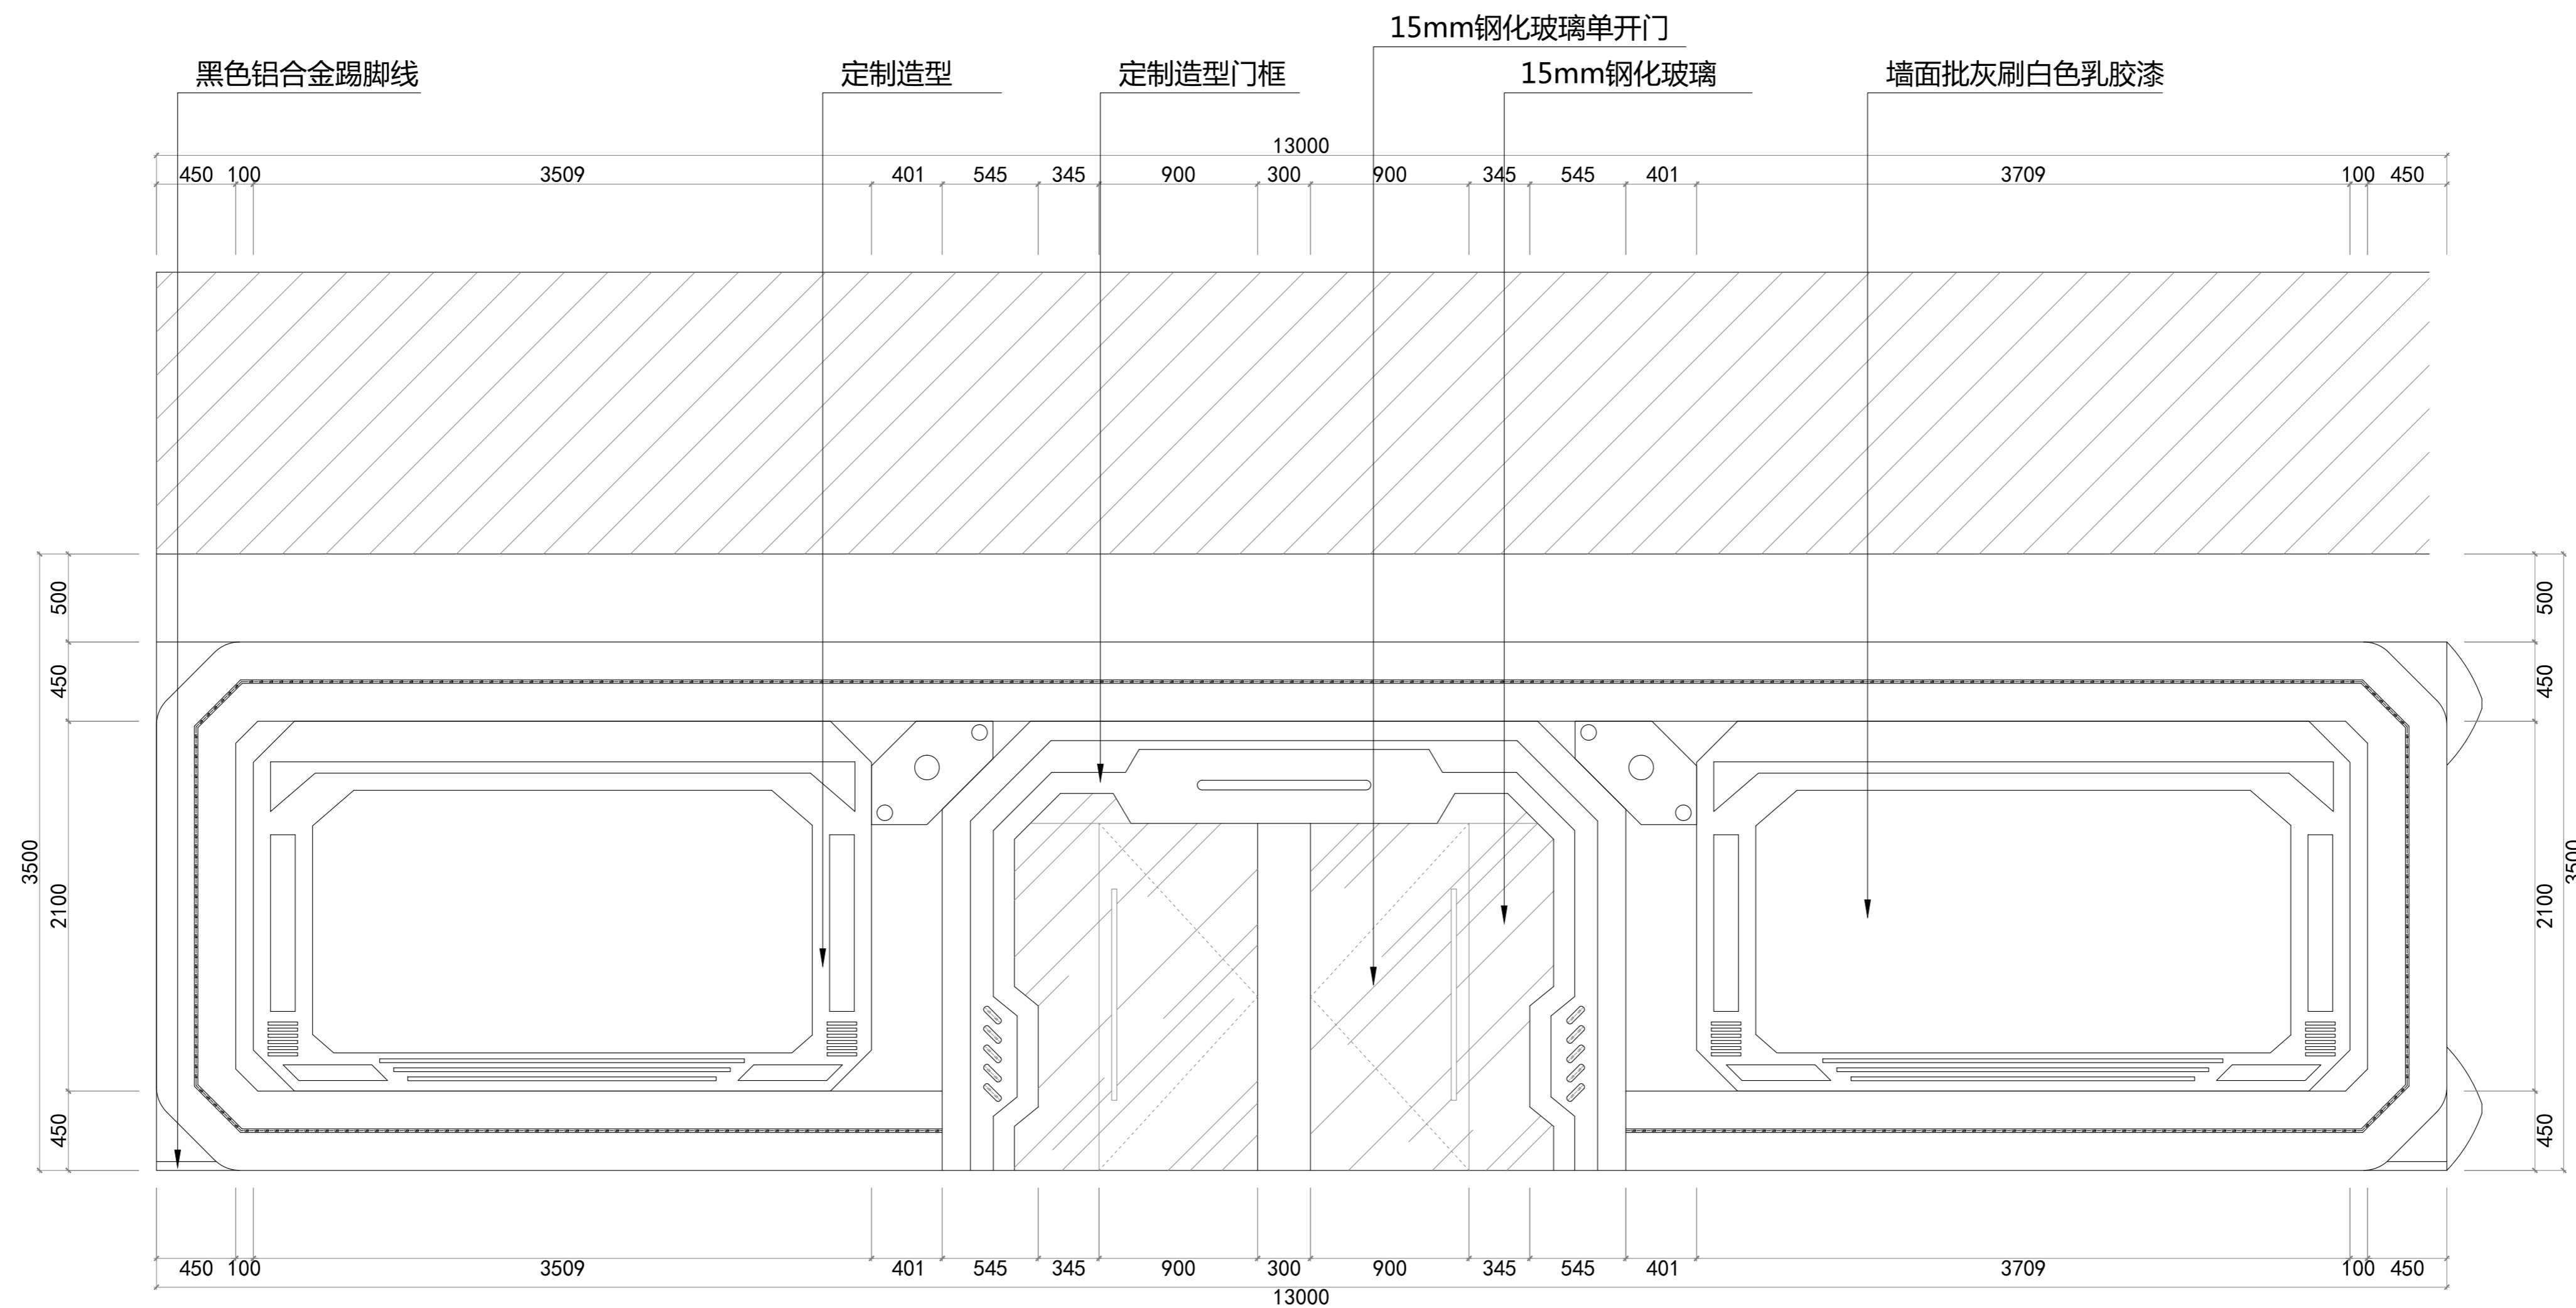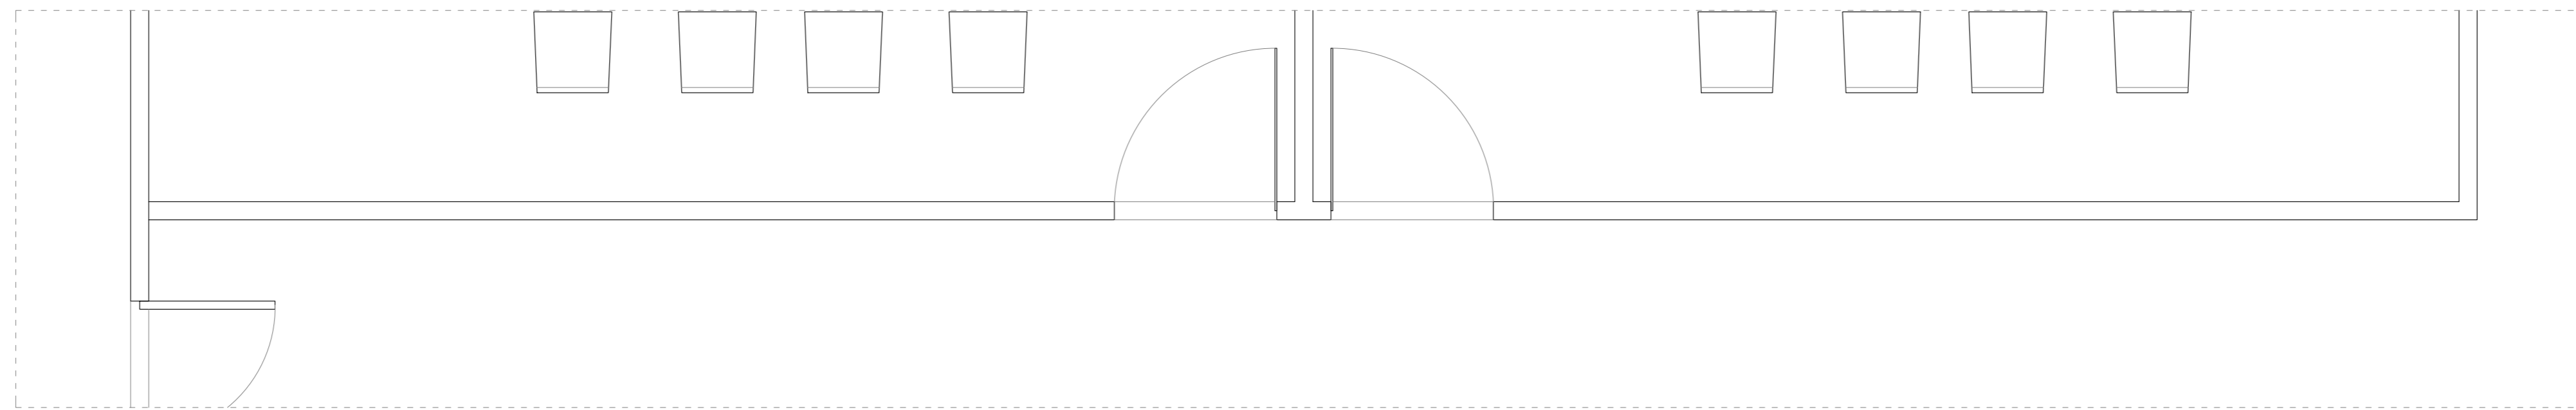

此图版权归本公司，所有尺寸以所注数字为准，并在工地核实无误，使用本图时应参阅其它有关图纸、说明和合同，如有矛盾即通知本公司，设计图若有变更应按下栏最后修改记录或变更通知单为准。

This drawings & design are copyright and portion may be reproduced without the written permission of the architect. Written dimensions or grid line measurements to existing work to be checked on site. This drawings is to be read in conjunction with the specification & conditions of contract, and with general architectural plans, structural plans and all immediately of any discrepancy found the drawings not showing the last revisions above are to be cancelled.

工程名称
PROJECT NAME

图纸名称
DRAWING TITLE

异能无人机学园

0立面图

次数	NO	修改日期	REVISIONS
△			
△			
△			
△			

设计负责人
PROJECT DIRECTOR

设计
DESIGNED BY

审核
APPROVED BY

业主(甲方)
CLIENT


制图
DRAWN BY

比例
SCALE

图号
DRAWING NO

日期
DATE

L-16

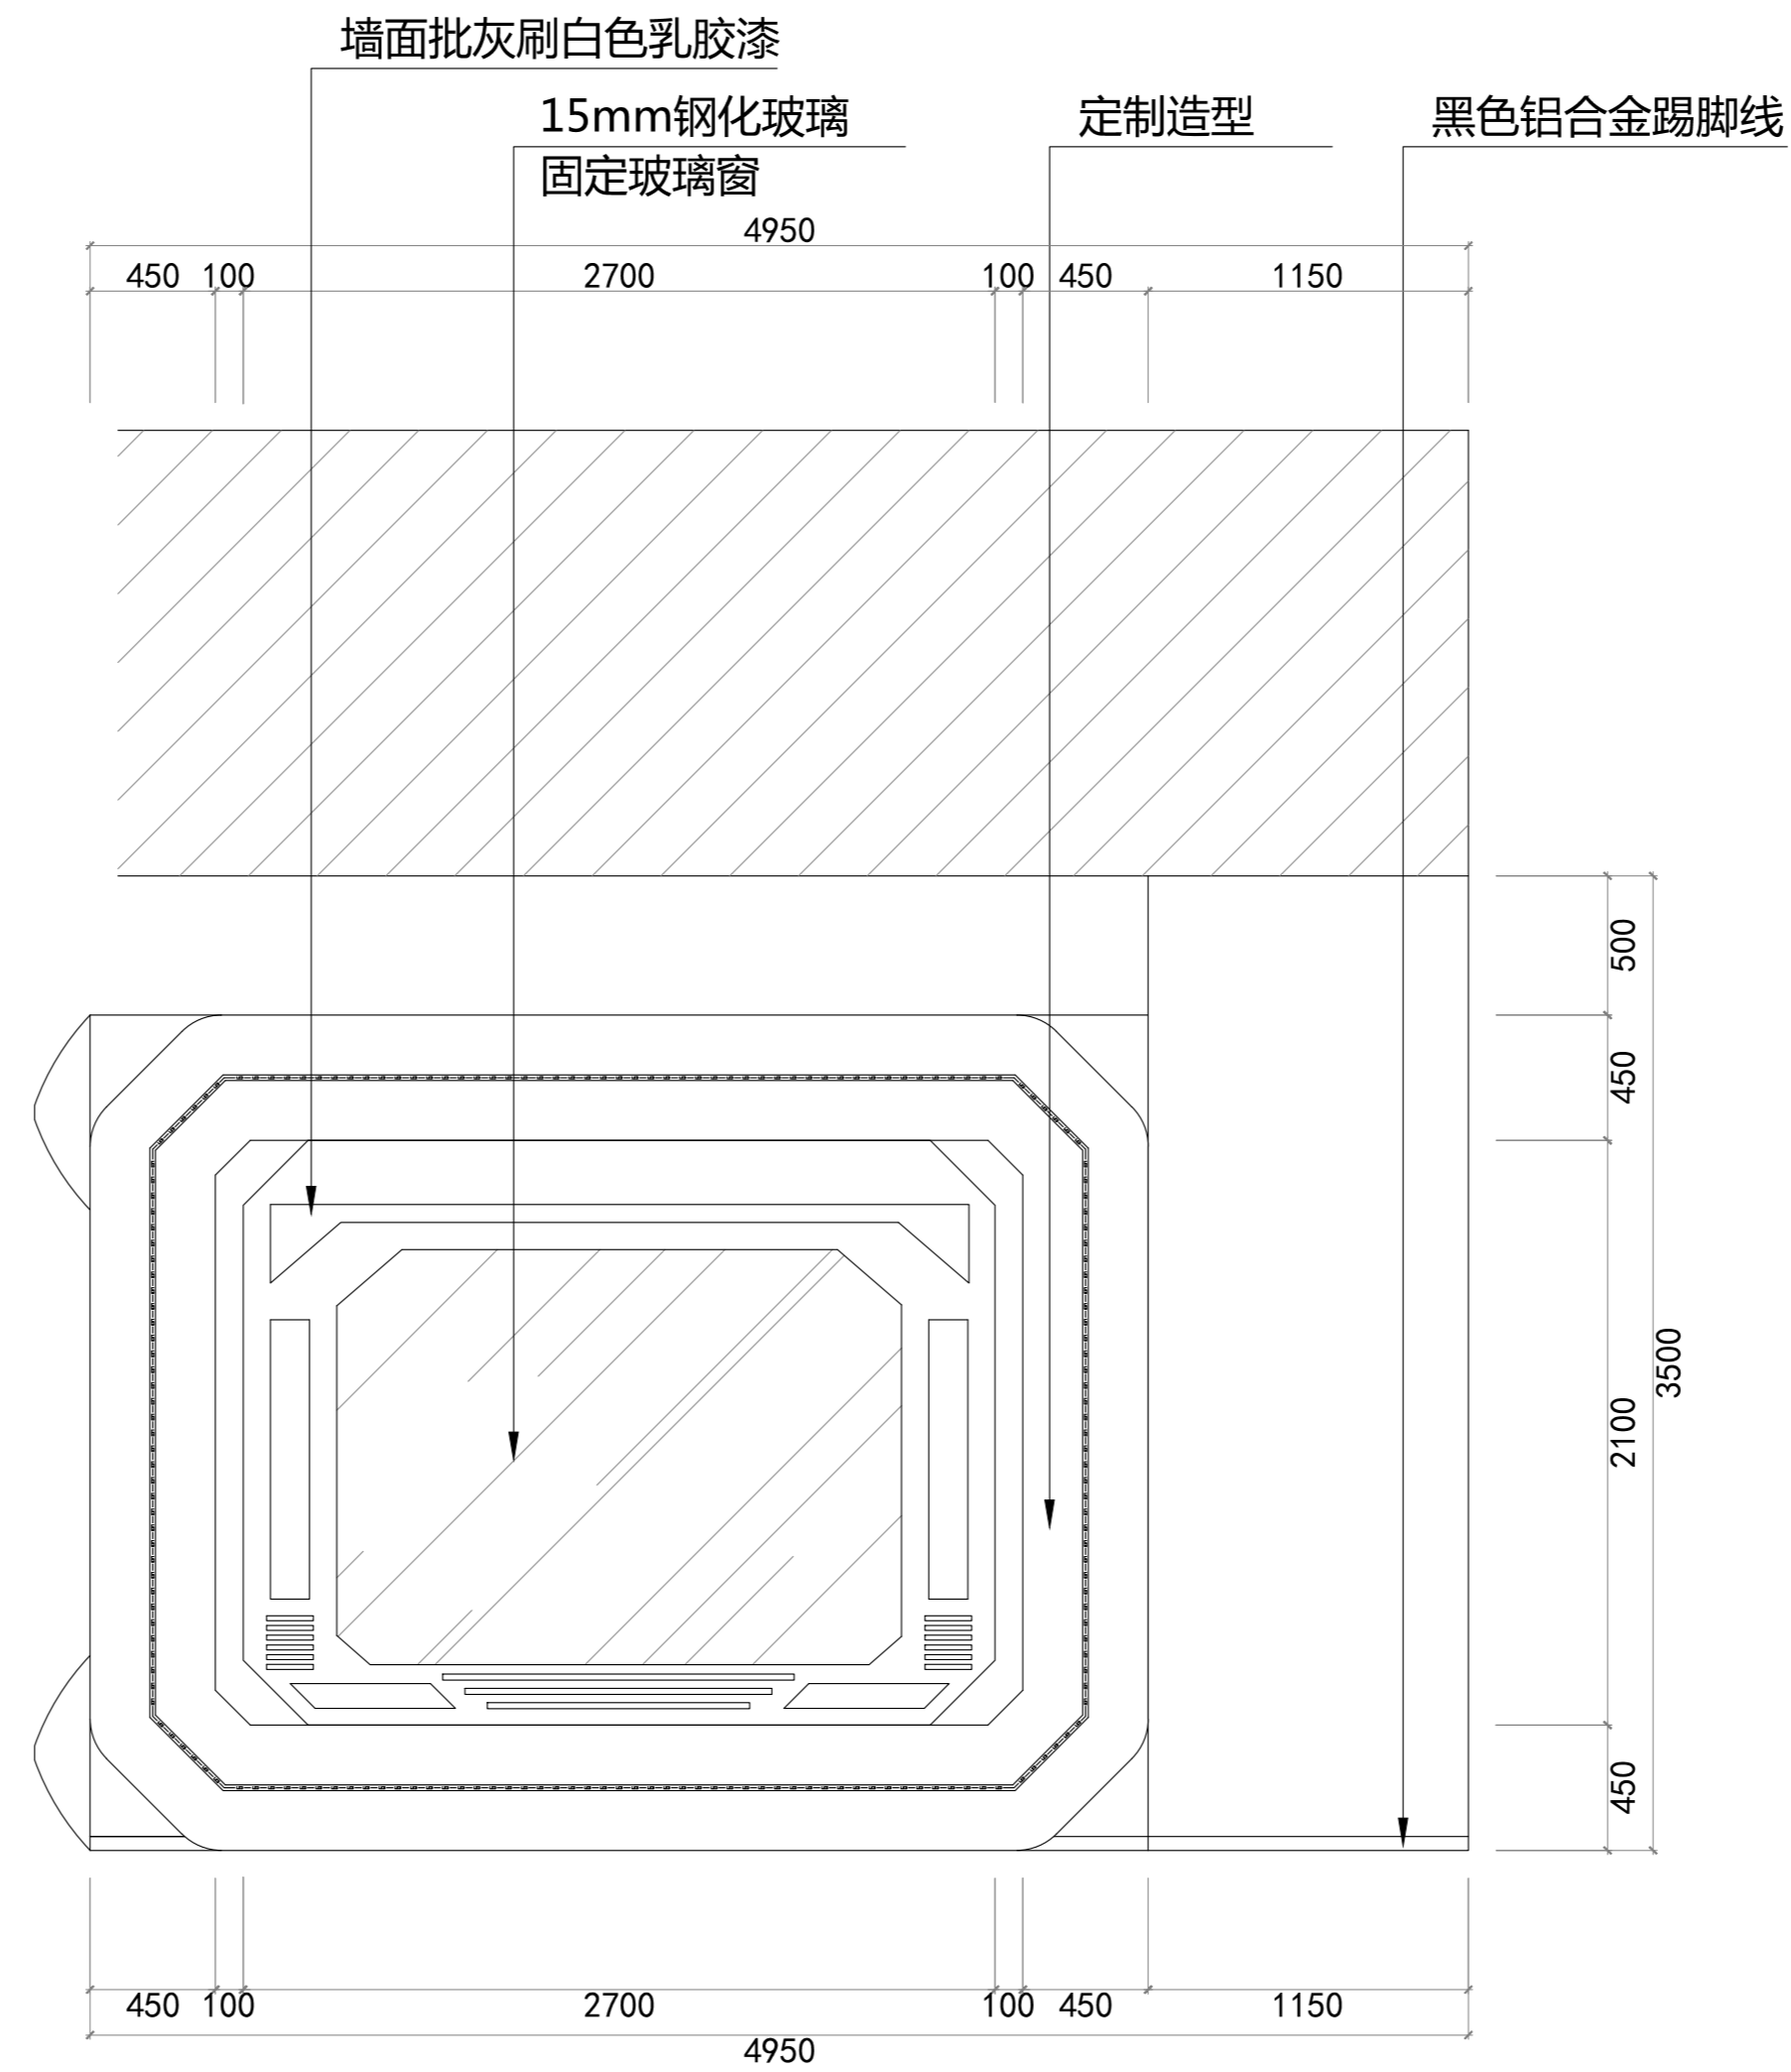


此图版权归本公司，所有尺寸以所注数字为准，并在工地核实无误，使用本图时应参阅其它有关图纸，说明和合同，如有矛盾即通知本公司，设计图若有变更应按下栏最后修改记录或变更通知单为准。
 This drawings & design are copyright and portion may be reproduced without the written permission of the architect. All written dimensions or grid line measurements to existing work to be checked on site. This drawings is to be read in conjunction with the specification & conditions of contract, and with general architectural plans, structural plans and all immediately of any discrepancy found the drawings not showing the last revisions above are to be cancelled.

工程名称
 PROJECT NAME
 图纸名称
 DRAWING TITLE


异能无人机学园
 P立面图

次数	NO	修改日期	REVISIONS
△			
△			
△			
△			

设计负责人 PROJECT DIRECTOR	业主(甲方) CLIENT	图号 DRAWING NO	L-17
设计 DESIGNED BY	制图 DRAWN BY	日期 DATE	
审核 APPROVED BY	比例 SCALE		

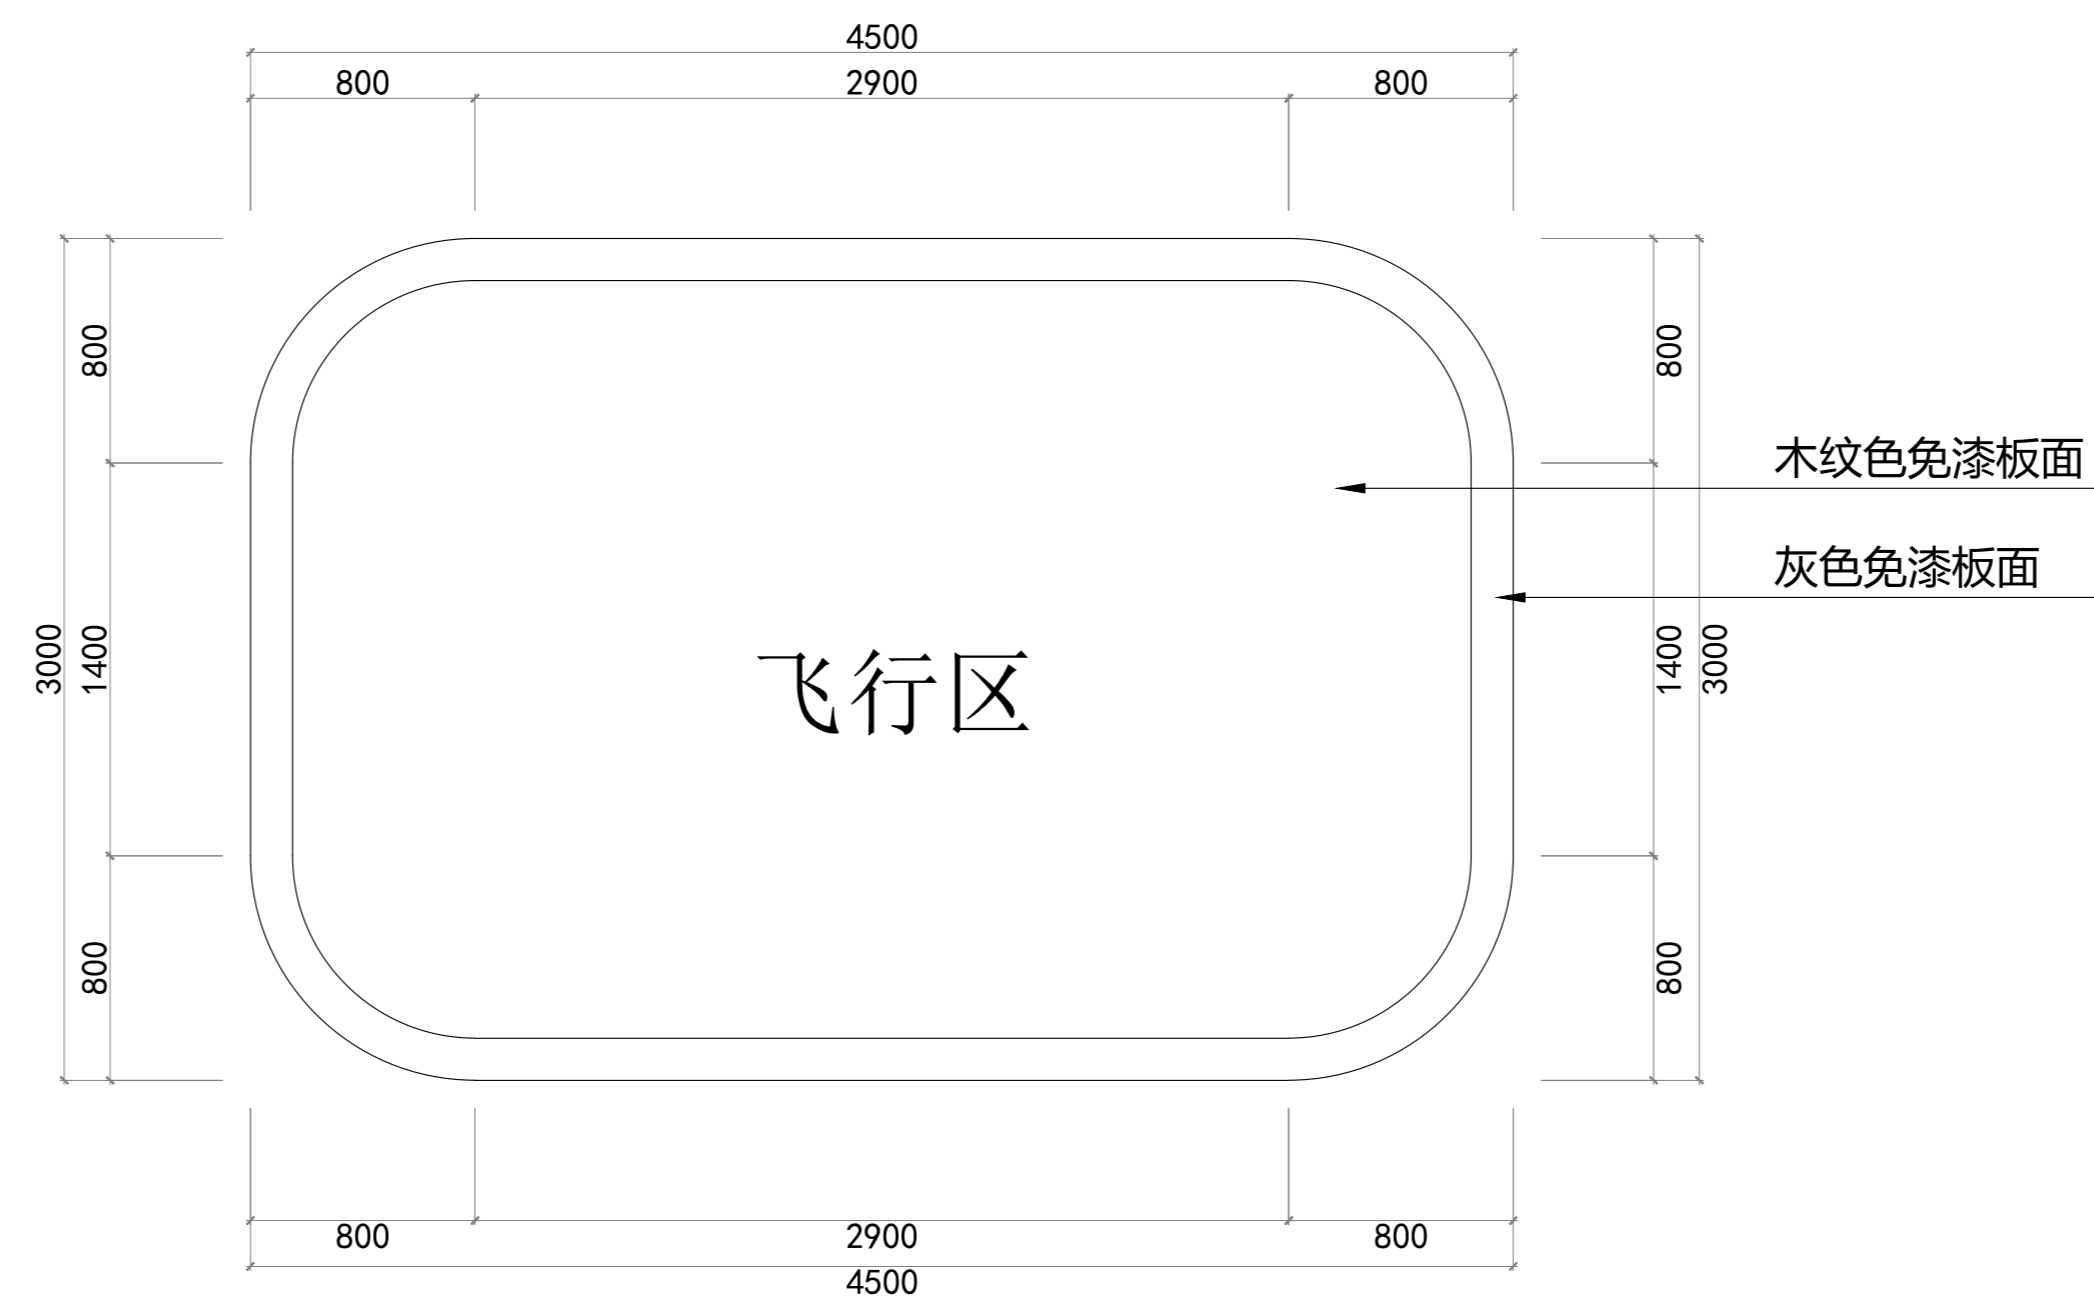

飞行区平面尺寸图

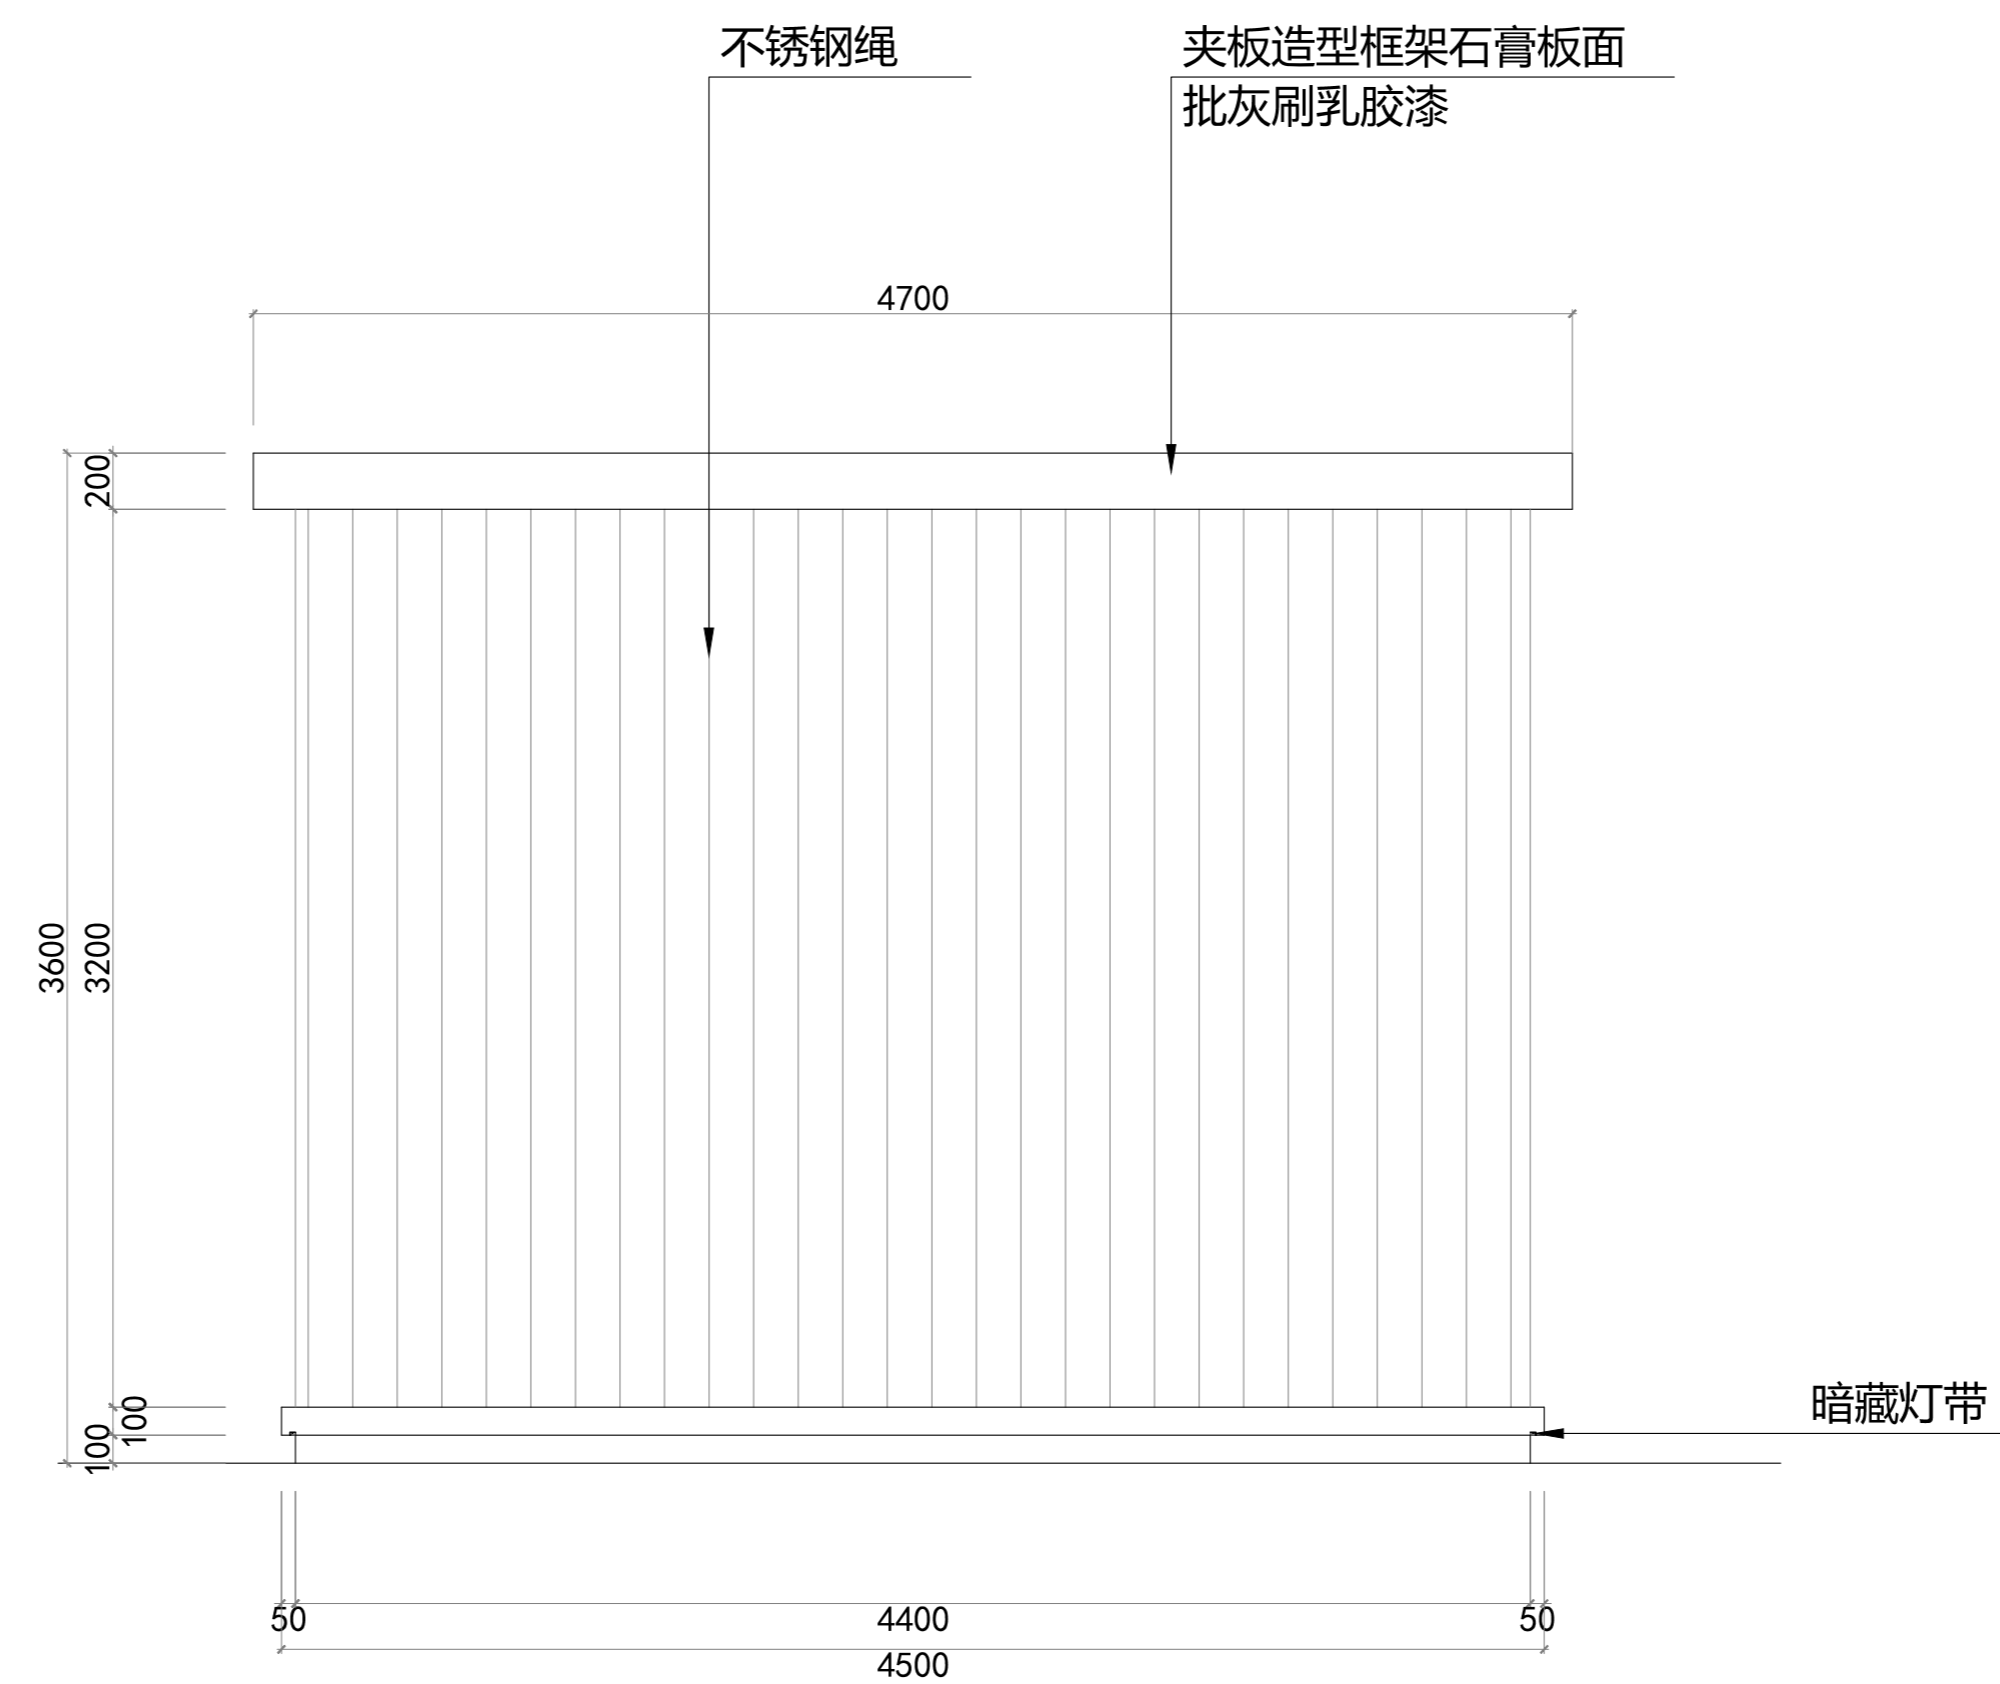

飞行区立面尺寸图

此图版权归本公司，所有尺寸以所注数字为准，并在工地核实无误，使用本图时应参阅其它有关图纸，说明和合同，如有矛盾即通知本公司，设计图若有变更应按下栏最后修改记录或变更通知单为准。
This drawings & design are copyright and portion may be reproduced without the written permission of the architect. All written dimensions or grid line measurements to existing work to be checked on site. This drawings is to be read in conjunction with the specification & conditions of contract, and with general architectural plans, structural plans and all immediately of any discrepancy found the drawings not showing the last revisions above are to be cancelled.

工程名称
PROJECT NAME
图纸名称
DRAWING TITLE

异能无人机学园
飞行区尺寸图

次数	NO	修改日期	REVISIONS
△			
△			
△			
△			

设计负责人
PROJECT DIRECTOR
设计
DESIGNED BY
审核
APPROVED BY

业主(甲方)
CLIENT
制图
DRAWN BY
比例
SCALE

图号
DRAWING NO
日期
DATE
L-18